


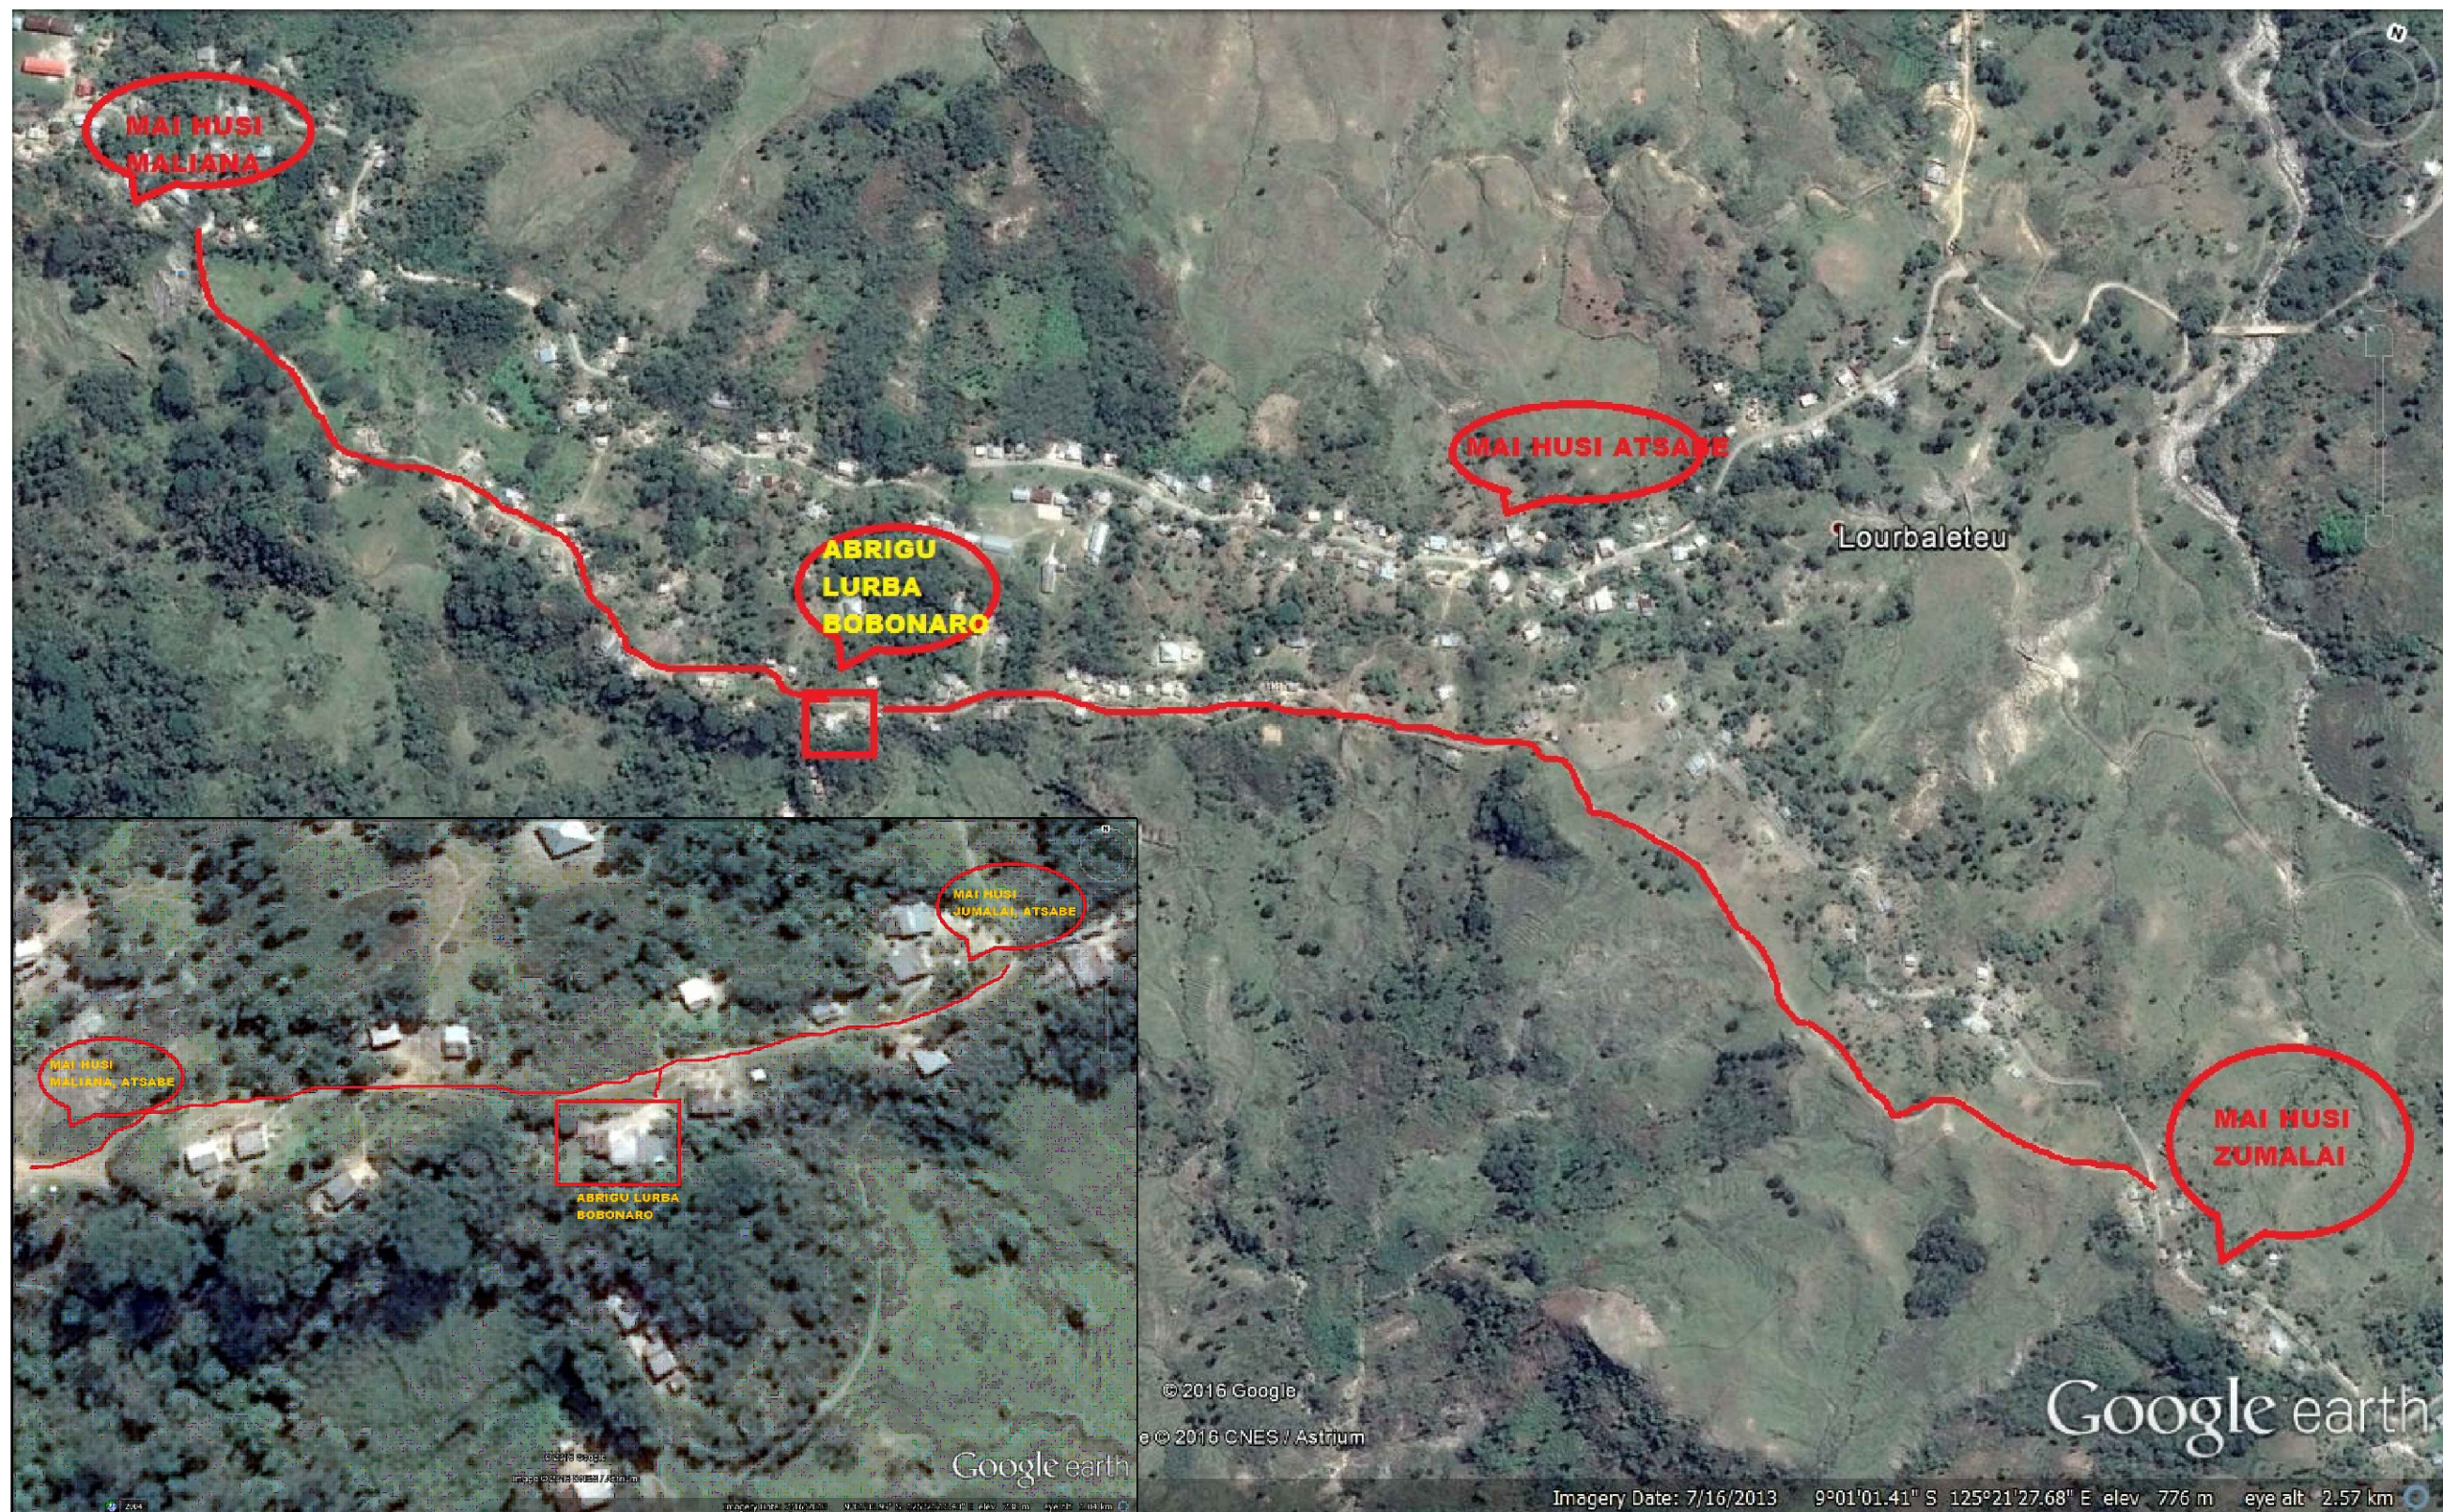

CLIENT / PROJECT OWNER		PREPARED BY	PROJECT TITLE	DRAWING TITLE	CONSULTANT DESIGN: A3R CONSULTANT		PROJECT OWNER		DEMOCRATIC REPUBLIC OF TIMOR LESTE				SHEET NO:
 ARQUIVO & MUSEU RESISTÊNCIA TIMORENSE INSTITUTO PÚBLICO REPÚBLICA DEMOCRÁTICA DE TIMOR LESTE Avenida Cidade de Lisboa, Dili, Timor Leste Phone: +670 - 77305782		 ANGEL/AQUIRA Consultant, Unipessoal Lda. Architectural & Engineering Design, Supervision and Project Management Vila Verde, Dili, Timor - Leste, Phone: +670 - 7238140 E-mail: ino_neves@yahoo.com	REHABILITAÇÃO DE ABRIGUS DA RESISTÊNCIA ABRIGU LURBA LURBA, BOBONARO TIMOR LESTE	LOCATION MAP	DRAWING BY:	APPROVED BY:	APPROVED BY:		 MINISTRY OF PUBLIC WORK, TRANSPORT AND COMMUNICATION GENERAL DIRECTORATE OF PUBLIC WORKS NATIONAL DIRECTORATE OF BUILDING				
					Arch. Aquilino F. das Neves	Eng. Jesuino J.X. Neves	Sr. Hamar Antoninho Baptista Alves Director e Presidente AMRT	Eng. Octavio P. Marques, M.Eng. HEAD OF PROJECT DEPARTMENT	Arch. Rosa Amaral Vong Directress of DNE				
DATE :	DATE :	DATE :										DRAWING NO:	

TABLE OF CONTENTS


I. "ABRIGU" HOUSE AND "ABRIGU"

- A 01. EXISTING SITUATION
- A 02. EXISTING SITE PLAN
- A 03. EXISTING PLAN
- A 04. ELEVATION
- A 05. ELEVATION
- A 06. ELEVATION
- A 07. SECTION
- A 08. "ABRIGU" EXISTING PLAN
- A 09. "ABRIGU" SECTION
- A 10. "ABRIGU" SECTION
- A 11. REHABILITATION ITEMS
- A 12. TOP ROOF REHABILITATION ITEMS
- A 13. ZINC WALL
- A 14. ZINC WALL
- A 15. WALL PLASTERING
- A 16. WALL PLASTERING
- A 17. WALL PLASTERING
- A 18. WALL PLASTERING
- A 19. WALL PLASTERING
- A 20. STAIR AND DETAILS
- A 21. LEAN CONCRETE "ABRIGU" FLOOR
- A 22. RETAINING WALL AND STRUCTURE PLAN
- A 23. UNDERGROUND DRAINAGE PLAN
- A 24. DRAINAGE SECTION
- A 25. DRAINAGE SECTION
- A 26. DRAINAGE SECTION
- A 27. WATER TANK PLAN
- A 28. WATER TANK SECTION
- A 29. WATER TANK COVER AND DETAILS
- A 30. DRAINAGE DETAILS
- A 31. DRAINAGE PIPE DETAILS
- A 32. REINFORCEMENT DETAILS


II. TOILET FOR ABRIGU


- A 33. TOILET PLAN
- A 34. ELEVATION
- A 35. ELEVATION
- A 36. SECTION
- A 37. SECTION
- A 38. FOUNDATION PLAN
- A 39. TRUSS FRAME PLAN
- A 40. ELECTRICAL PLAN
- A 41. PLUMBING PLAN
- A 42. CLEAN WATER PLAN
- A 43. SEPTIC TANK PLAN AND DETAILS
- A 44. FOUNDATION AND DOORS DETAILS


CLIENT / PROJECT OWNER		PREPARED BY	PROJECT TITLE	DRAWING TITLE	CONSULTANT DESIGN: A3R CONSULTANT		PROJECT OWNER			DEMOCRATIC REPUBLIC OF TIMOR LESTE MINISTRY OF PUBLIC WORK, TRANSPORT AND COMMUNICATION GENERAL DIRECTORATE OF PUBLIC WORKS NATIONAL DIRECTORATE OF BUILDING				SHEET NO:
 ARQUIVO & MUSEU RESISTÊNCIA TIMORENSE INSTITUTO PÚBLICO REPÚBLICA DEMOCRÁTICA DE TIMOR LESTE Avenida Cidade de Lisboa, Dili, Timor Leste Phone: +670 - 77305782		 ANGEL'AQUIRA Consultant, Unipessoal Lda. Architectural & Engineering Design, Supervision and Project Management Vila Verde, Dili, Timor - Leste, Phone: +670 - 7238140 E-mail: ino_neves@yahoo.com	REHABILITAÇÃO DE ABRIGUS DA RESISTÊNCIA ABRIGU LURBA LURBA, BOBONARO TIMOR LESTE	TABLE OF CONTENT	DRAWING BY:	APPROVED BY:	APPROVED BY:			VERIFIED BY:	DATE	APPROVED BY:	DATE	00 OF 44
					Arch. Aquilino F. das Neves	Eng. Jesuino J.X. Neves	Sr. Hamar Antoninho Baptista Alves Director e Presidente AMRT			Eng. Octavio P. Marques, M.Eng. HEAD OF PROJECT DEPARTMENT		Arch. Rosa Amaral Vong Directress of DNE		
			LOCATION : BOBONARO	SCALE : 1:3000	DATE :	DATE :	DATE :						ARCH 00 OF 44	

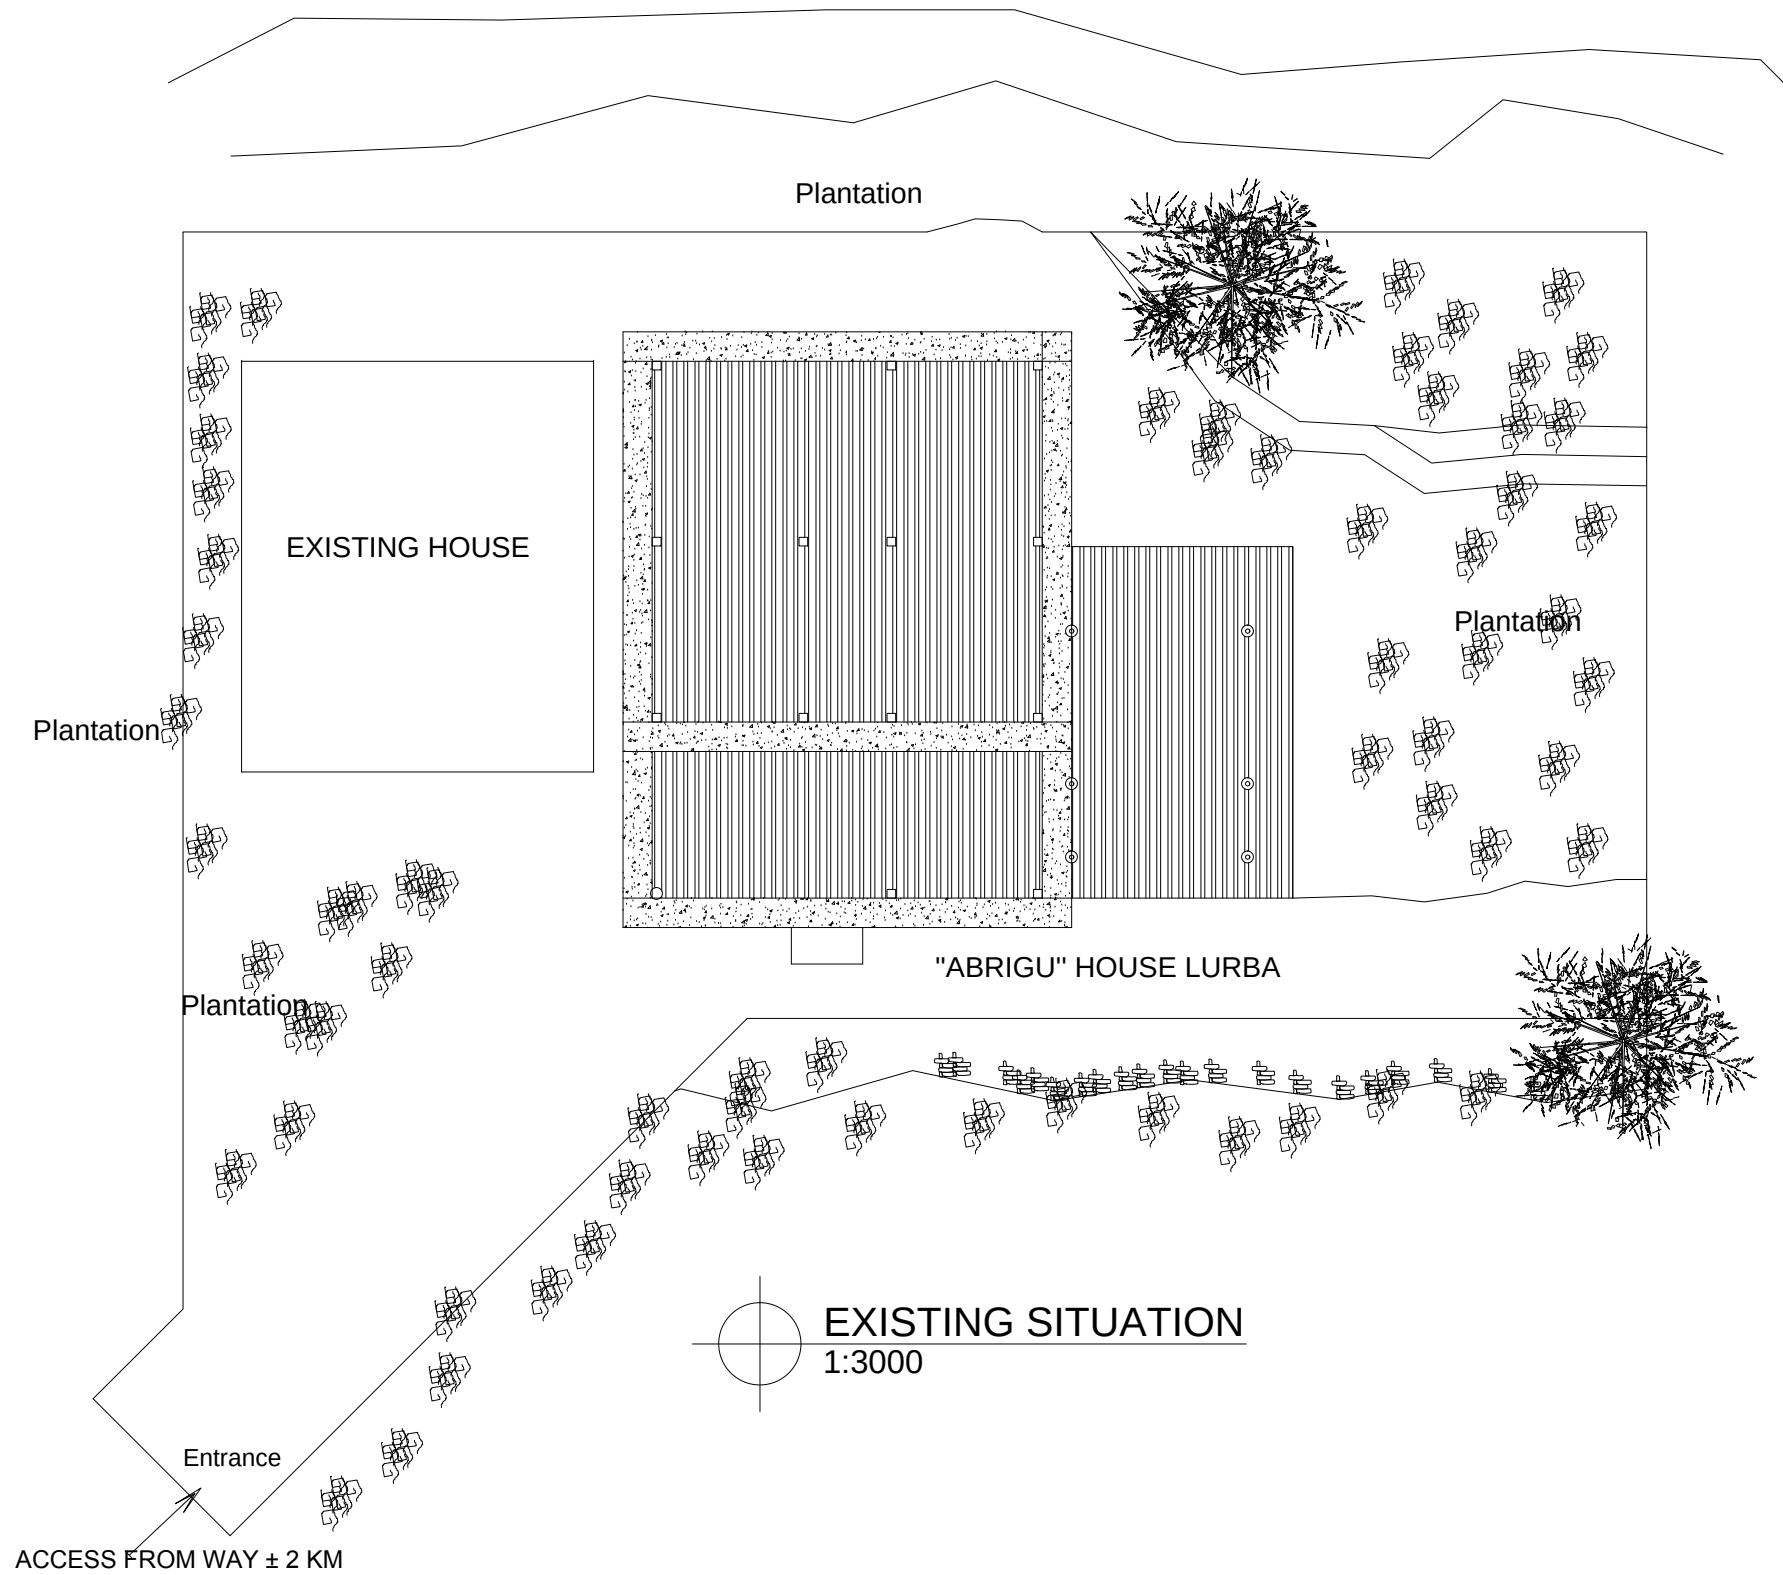


CLIENT / PROJECT OWNER		PREPARED BY	PROJECT TITLE	DRAWING TITLE		CONSULTANT DESIGN: A3R CONSULTANT		PROJECT OWNER	DEMOCRATIC REPUBLIC OF TIMOR LESTE				SHEET NO:
 ARQUIVO & MUSEU RESISTÊNCIA TIMORENSE INSTITUTO PÚBLICO REPÚBLICA DEMOCRÁTICA DE TIMOR LESTE Avenida Cidade de Lisboa, Díli, Timor Leste Phone: +670 - 77305782		 ANGEL'AQUIRA Consultant, Unipessoal Lda. Architectural & Engineering Design, Supervision and Project Management Vila Verde, Díli, Timor - Leste, Phone: +670 - 7238140 E-mail: ino_neves@yahoo.com	REHABILITAÇÃO DE ABRIGUS DA RESISTÊNCIA	EXISTING SITUATION	DRAWING BY:	APPROVED BY:	APPROVED BY:	MINISTRY OF PUBLIC WORK, TRANSPORT AND COMMUNICATION GENERAL DIRECTORATE OF PUBLIC WORKS NATIONAL DIRECTORATE OF BUILDING				01 OF 44	
								VERIFIED BY:	DATE	APPROVED BY:	DATE		
								Arch. Aquilino F. das Neves	Eng. Jesuino J.X. Neves	Sr. Hamar Antoninho Baptista Alves Director e Presidente AMRT	Eng. Octavio P. Marques, M.Eng. HEAD OF PROJECT DEPARTMENT	Arch. Rosa Amaral Vong Directress of DNE	DRAWING NO: ARCH 01 OF 44

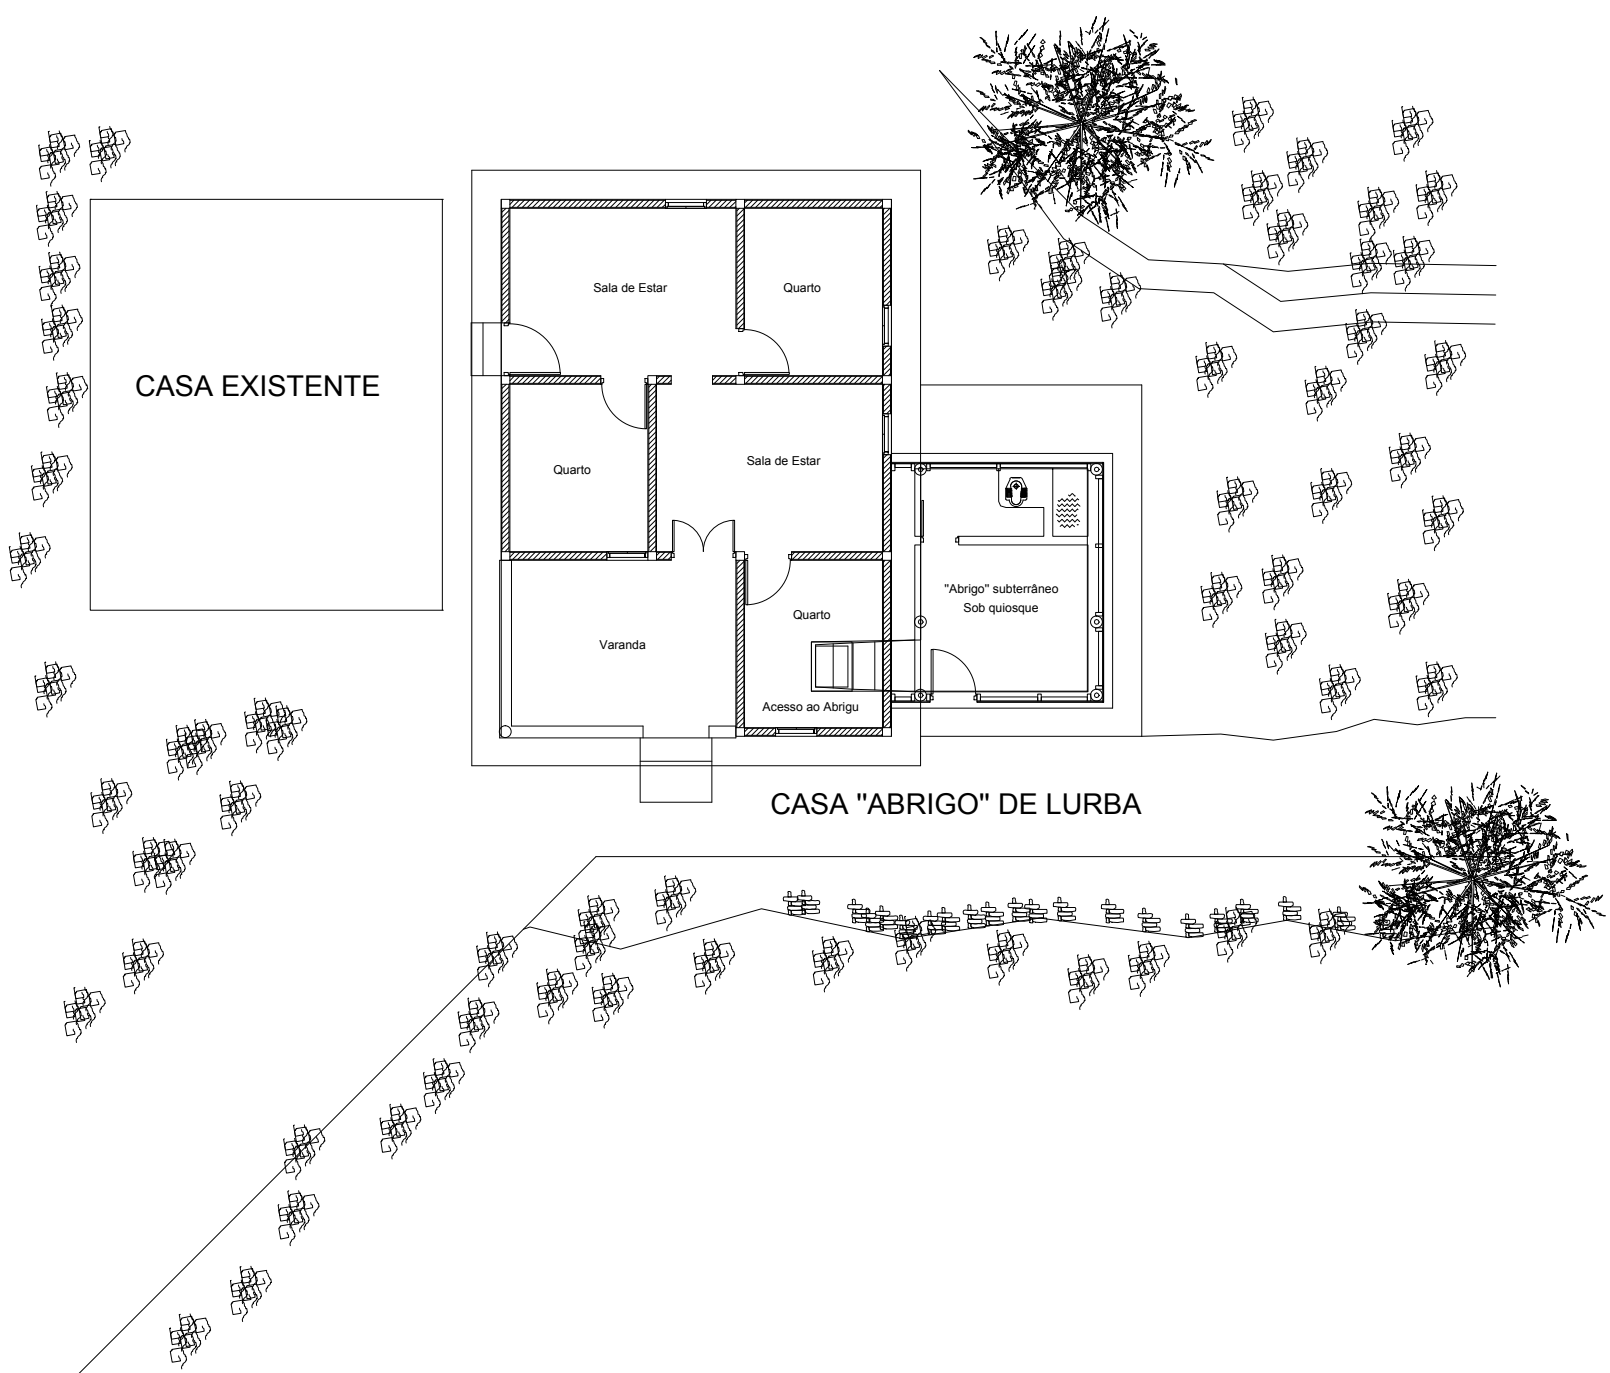

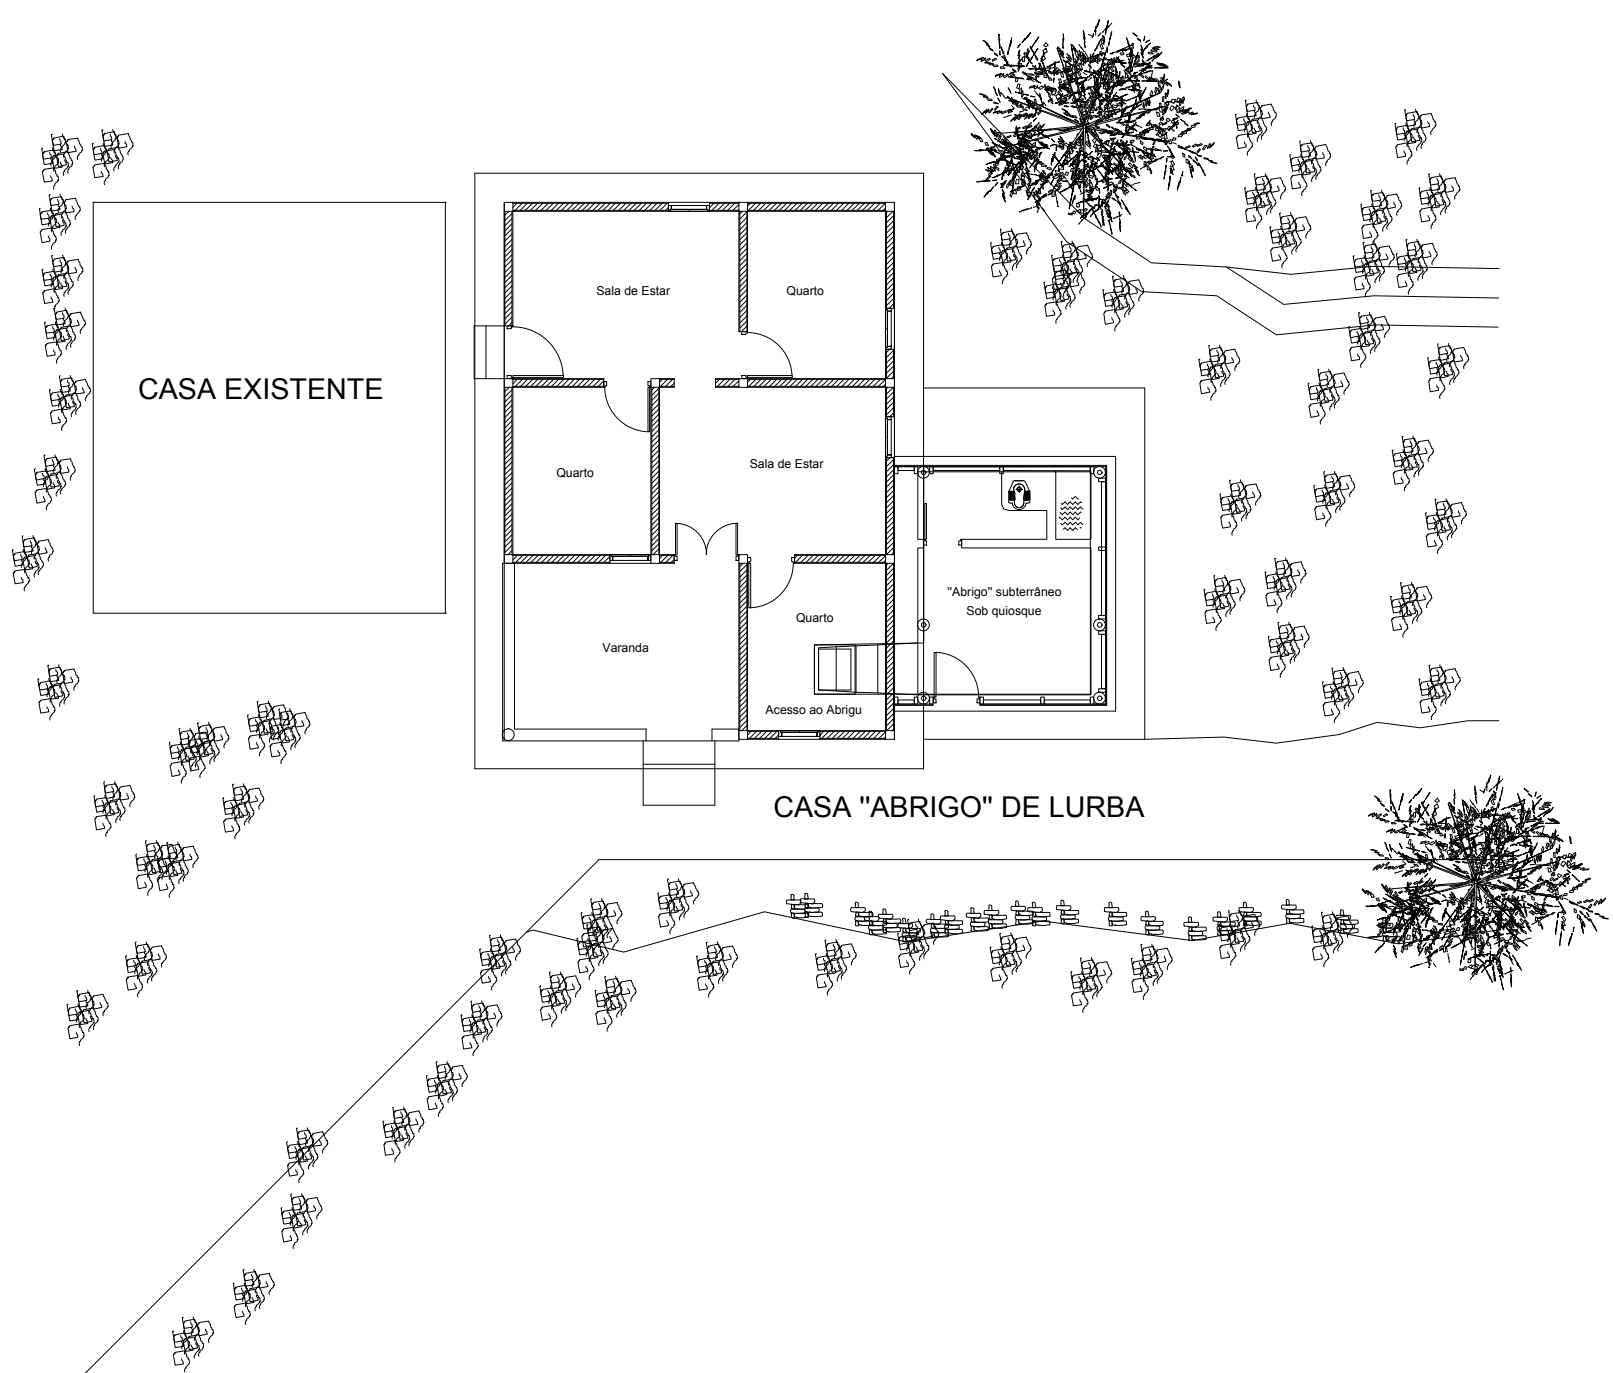


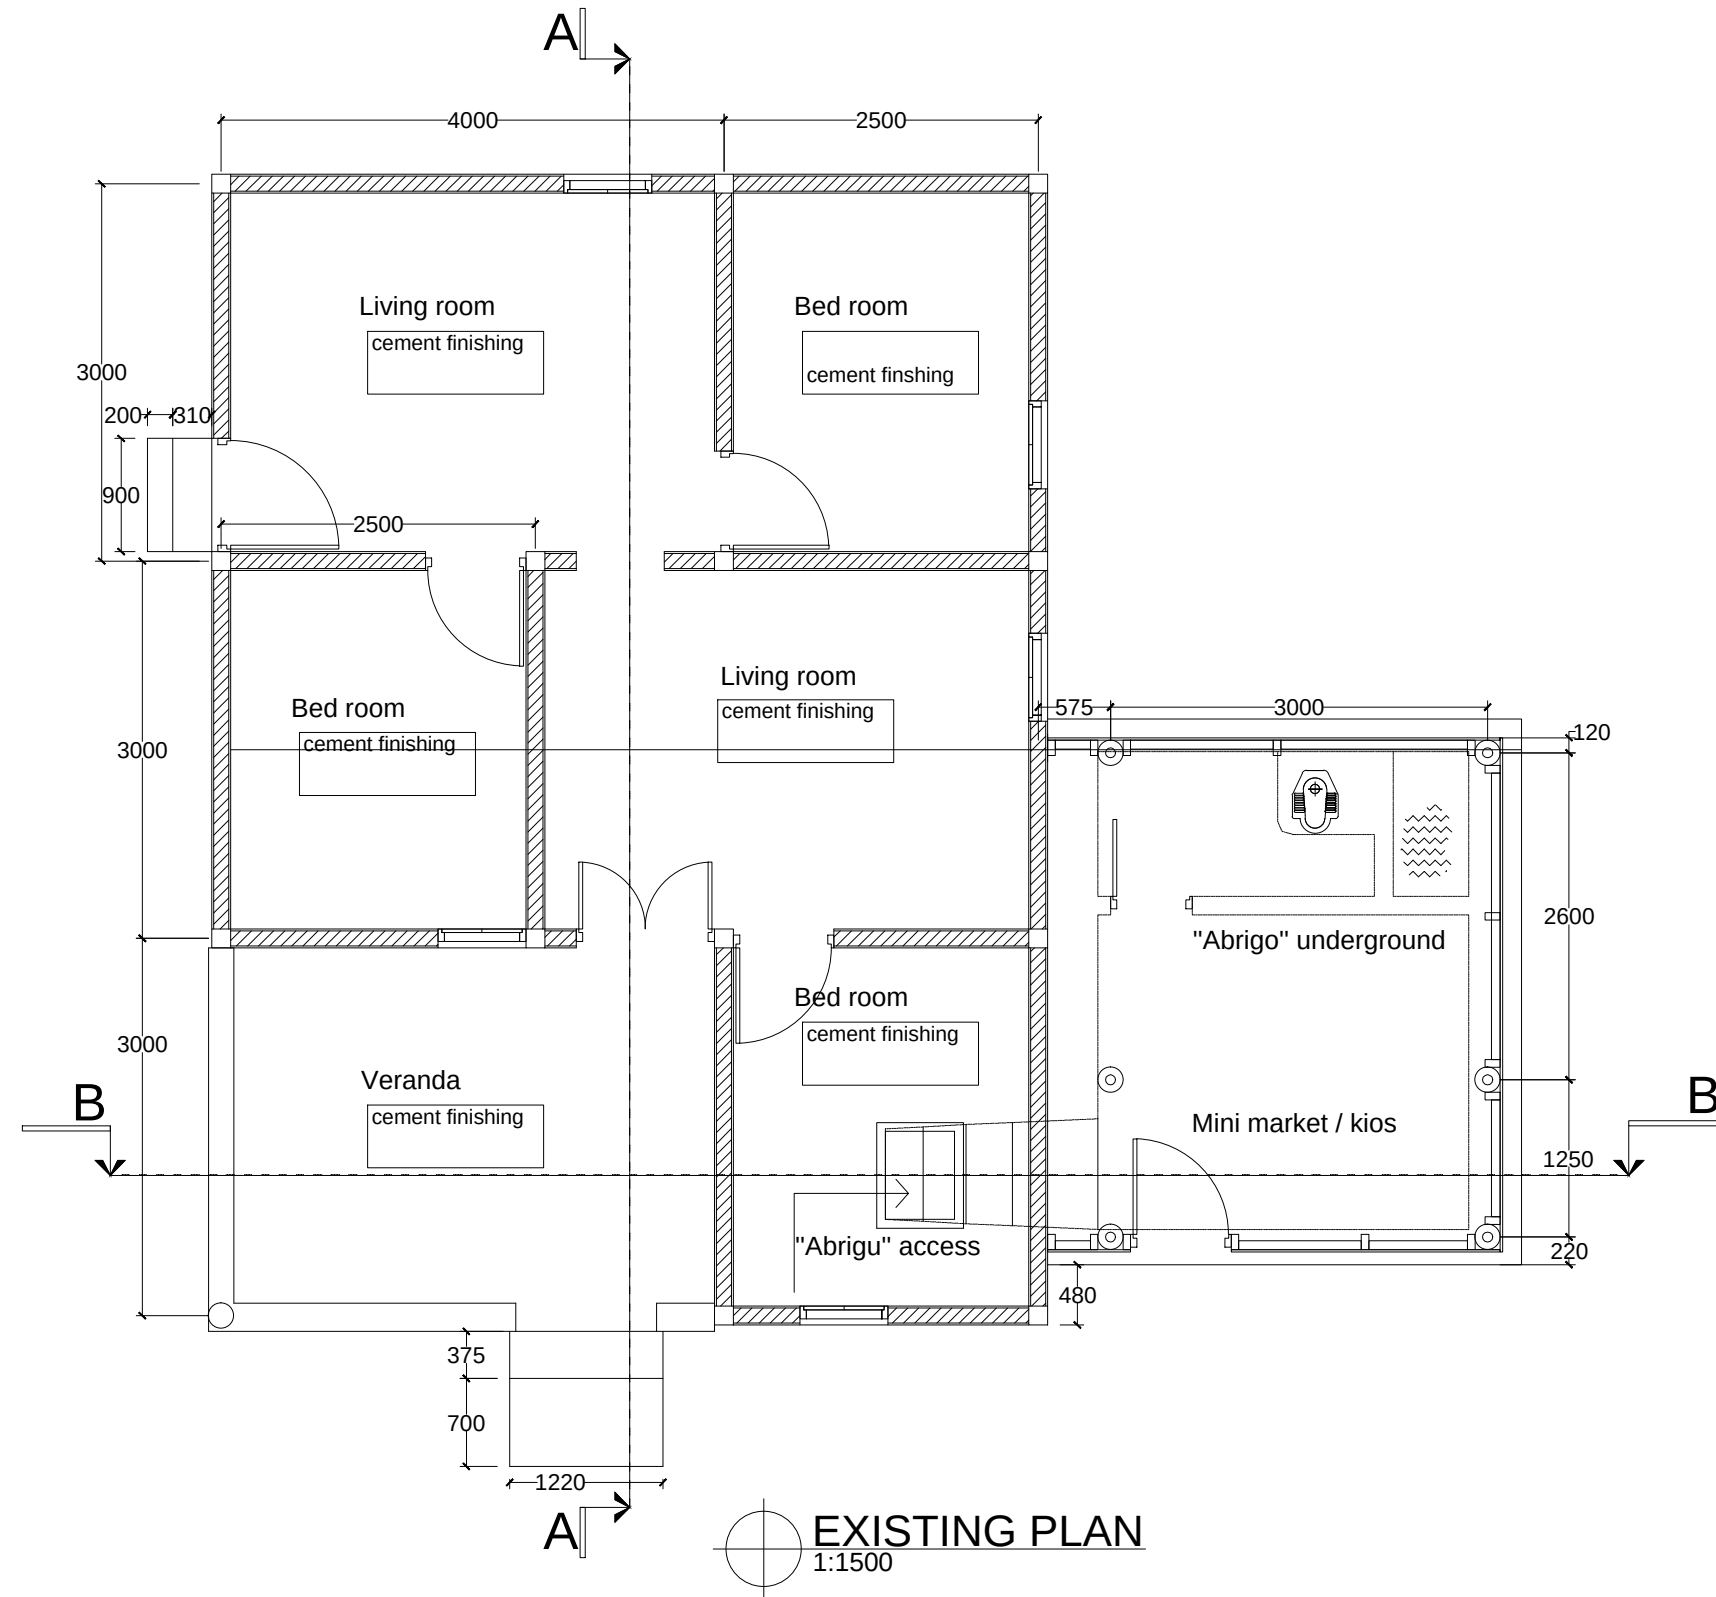

CLIENT / PROJECT OWNER	PREPARED BY	PROJECT TITLE	DRAWING TITLE	CONSULTANT DESIGN: A3R CONSULTANT		PROJECT OWNER		 DEMOCRATIC REPUBLIC OF TIMOR LESTE MINISTRY OF PUBLIC WORK, TRANSPORT AND COMMUNICATION GENERAL DIRECTORATE OF PUBLIC WORKS NATIONAL DIRECTORATE OF BUILDING	SHEET NO:			
 ARQUIVO & MUSEU RESISTÊNCIA TIMORENSE INSTITUTO PÚBLICO REPÚBLICA DEMOCRÁTICA DE TIMOR LESTE Avenida Cidade de Lisboa, Dili, Timor Leste Phone: +670 - 77305782	 ANGEL'AQUIRA Consultant, Unipessoal Lda. Architectural & Engineering Design, Supervision and Project Management Vila Verde, Dili, Timor - Leste, Phone: +670 - 7238140 E-mail: ino_neves@yahoo.com	REHABILITAÇÃO DE ABRIGUS DA RESISTÊNCIA ABRIGU LURBA LURBA, BOBONARO TIMOR LESTE	EXISTING PLAN	DRAWING BY:	APPROVED BY:	APPROVED BY:	VERIFIED BY:		DATE	APPROVED BY:	DATE	DRAWING NO: ARCH 03 OF 44
				Arch. Aquilino F. das Neves	Eng. Jesuino J.X. Neves	Sr. Hamar Antoninho Baptista Alves Director e Presidente AMRT	Eng. Octavio P. Marques, M.Eng. HEAD OF PROJECT DEPARTMENT			Arch. Rosa Amaral Vong Directress of DNE		

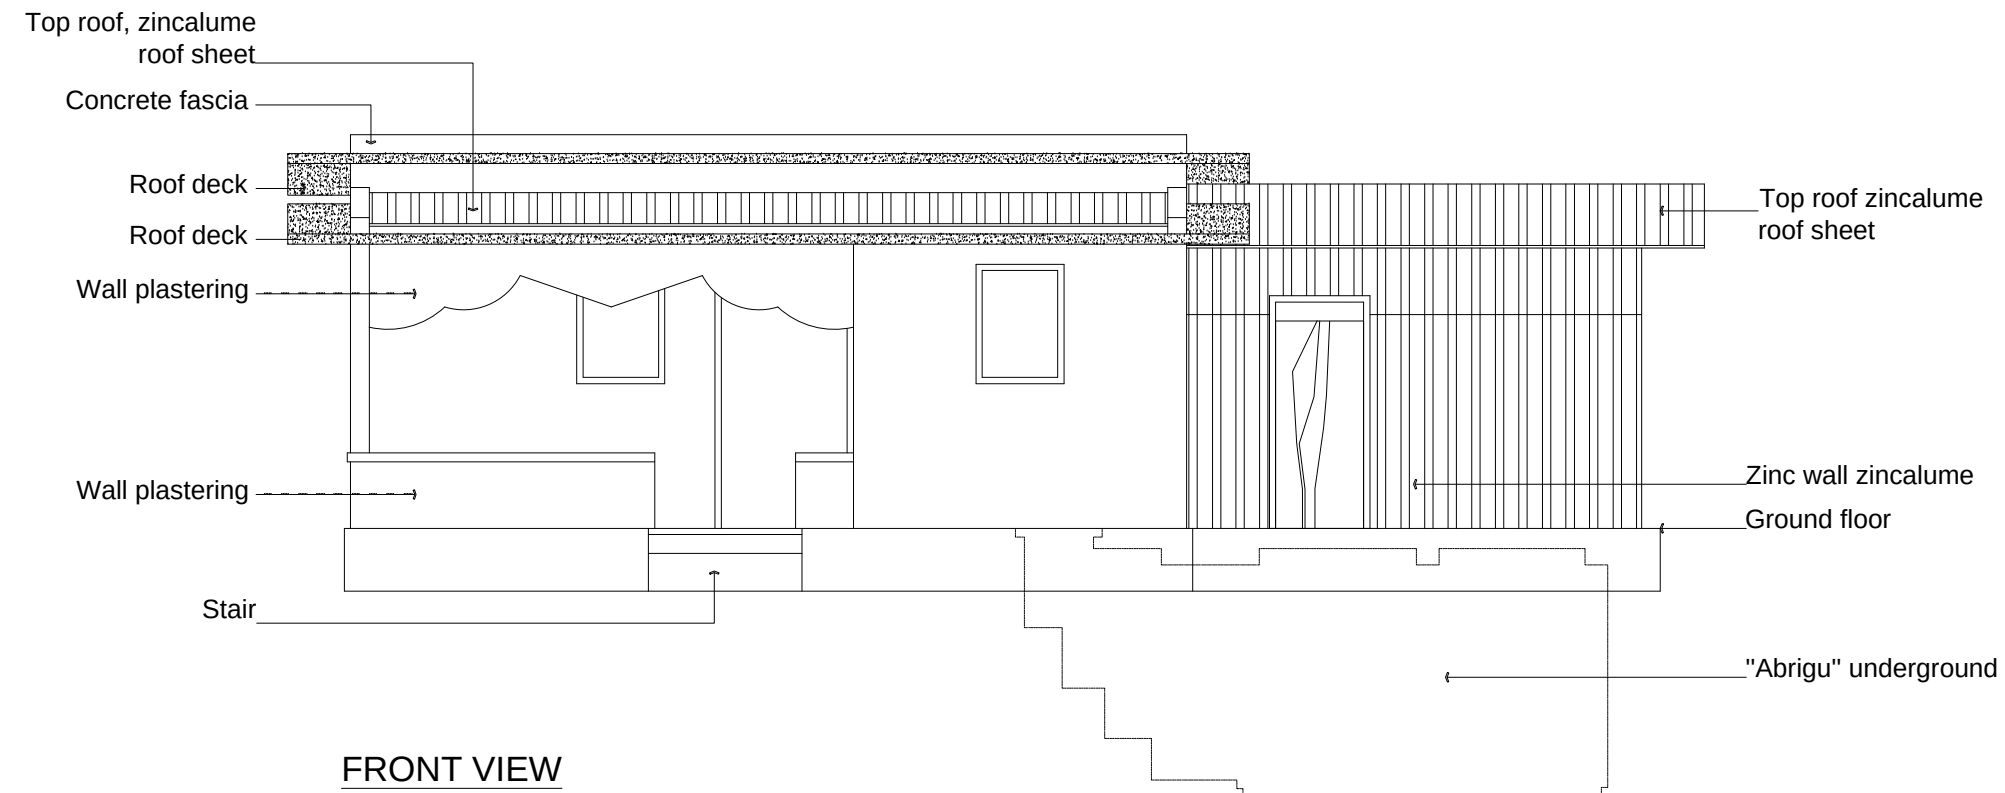



FRONT VIEW

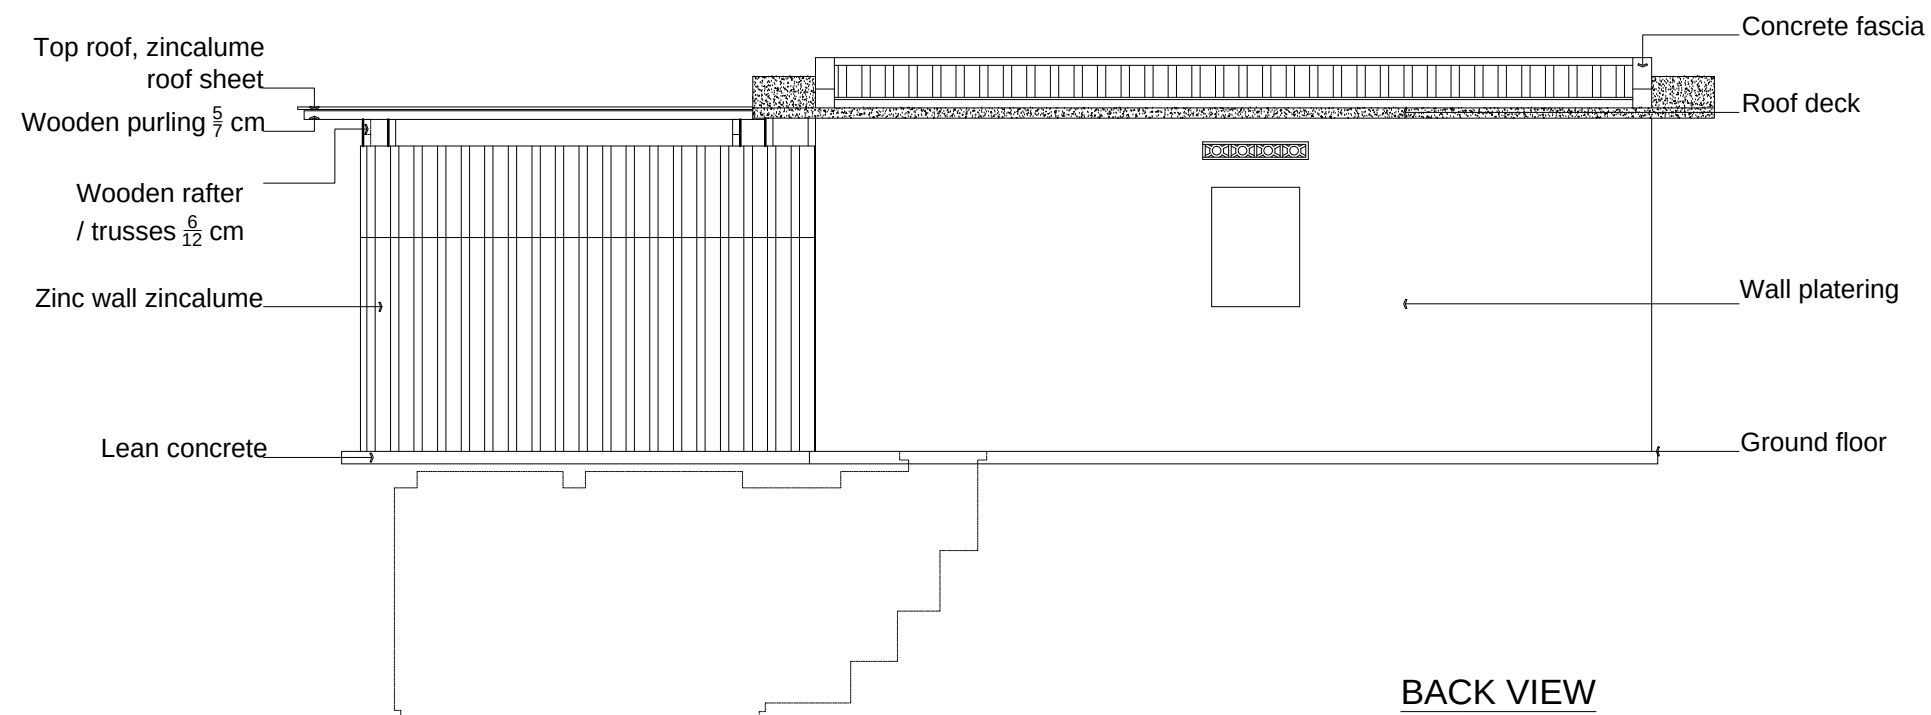


BACK VIEW



CLIENT / PROJECT OWNER	PREPARED BY	PROJECT TITLE	DRAWING TITLE	CONSULTANT DESIGN: A3R CONSULTANT		PROJECT OWNER	 DEMOCRATIC REPUBLIC OF TIMOR LESTE MINISTRY OF PUBLIC WORK, TRANSPORT AND COMMUNICATION GENERAL DIRECTORATE OF PUBLIC WORKS NATIONAL DIRECTORATE OF BUILDING				SHEET NO:
				DRAWING BY:	APPROVED BY:	APPROVED BY:					04 OF 44
 ARQUIVO & MUSEU RESISTÊNCIA TIMORENSE INSTITUTO PÚBLICO REPÚBLICA DEMOCRÁTICA DE TIMOR LESTE Avenida Cidade de Lisboa, Díli, Timor Leste Phone: +670 - 77305782	 ANGEL'AQUIRA Consultant, Unipessoal Lda. Architectural & Engineering Design, Supervision and Project Management Vila Verde, Díli, Timor - Leste, Phone: +670 - 7238140 E-mail: ino_neves@yahoo.com	REHABILITAÇÃO DE ABRIGUS DA RESISTÊNCIA ABRIGU LURBA LURBA, BOBONARO TIMOR LESTE	ELEVATION	Arch. Aquilino F. das Neves	Eng. Jesuino J.X. Neves	Sr. Hamar Antoninho Baptista Alves Director e Presidente AMRT	Eng. Octavio P. Marques, M.Eng. HEAD OF PROJECT DEPARTMENT	DATE	APPROVED BY:	DATE	DRAWING NO: ARCH 04 OF 44
		LOCATION : BOBONARO	SCALE : 1:1500	DATE :	DATE :	DATE :			Arch. Rosa Amaral Vong Directress of DNE		

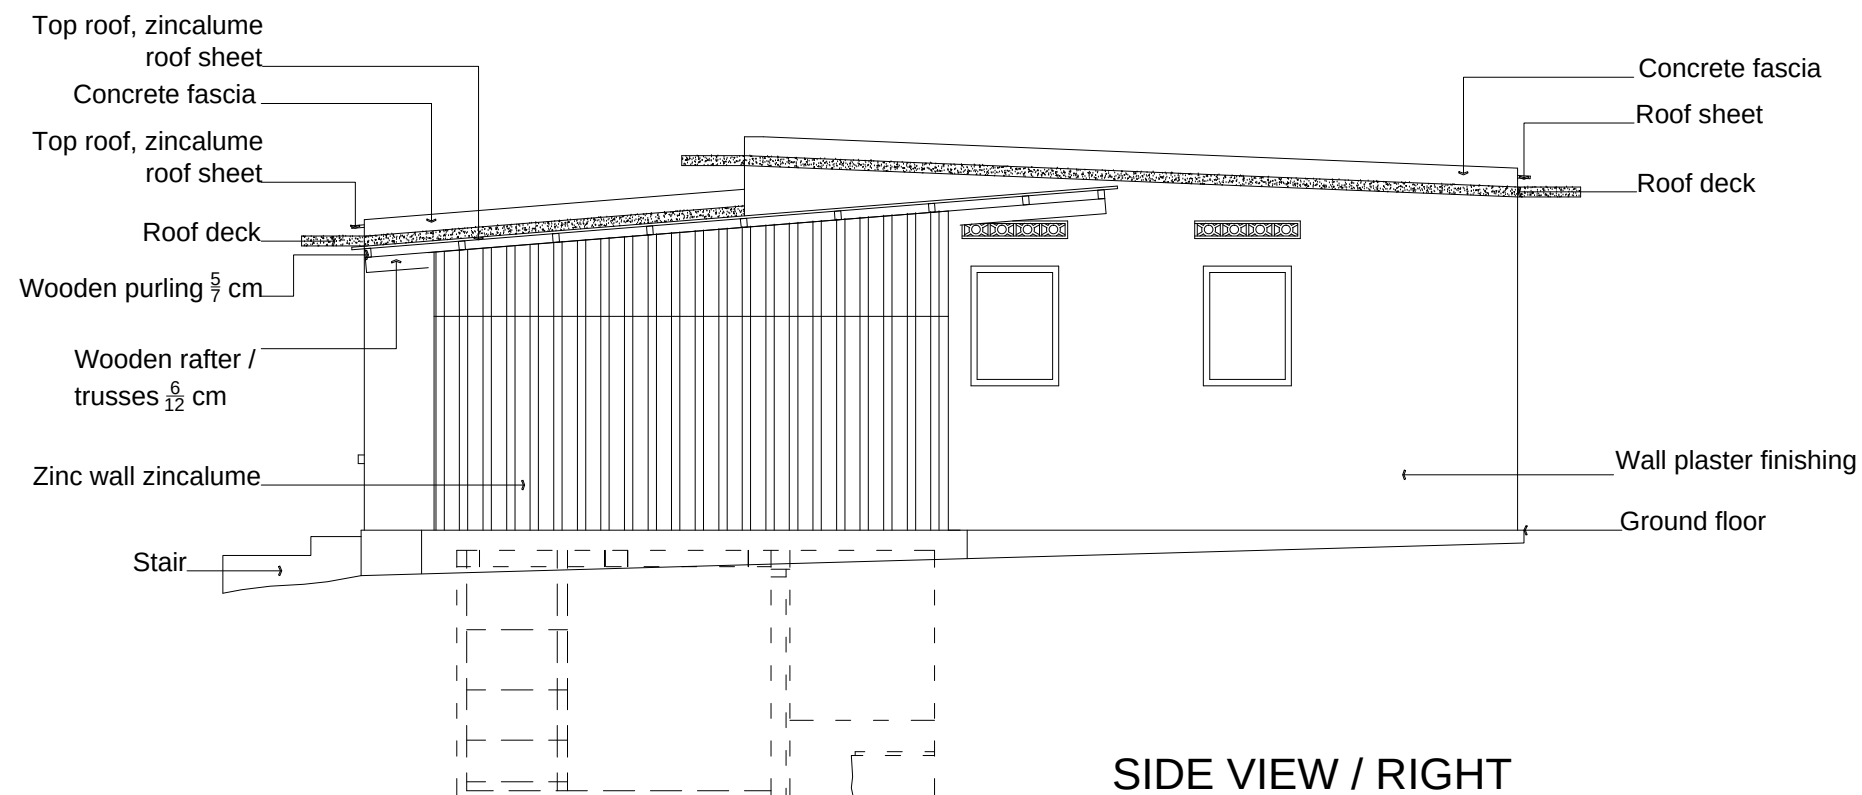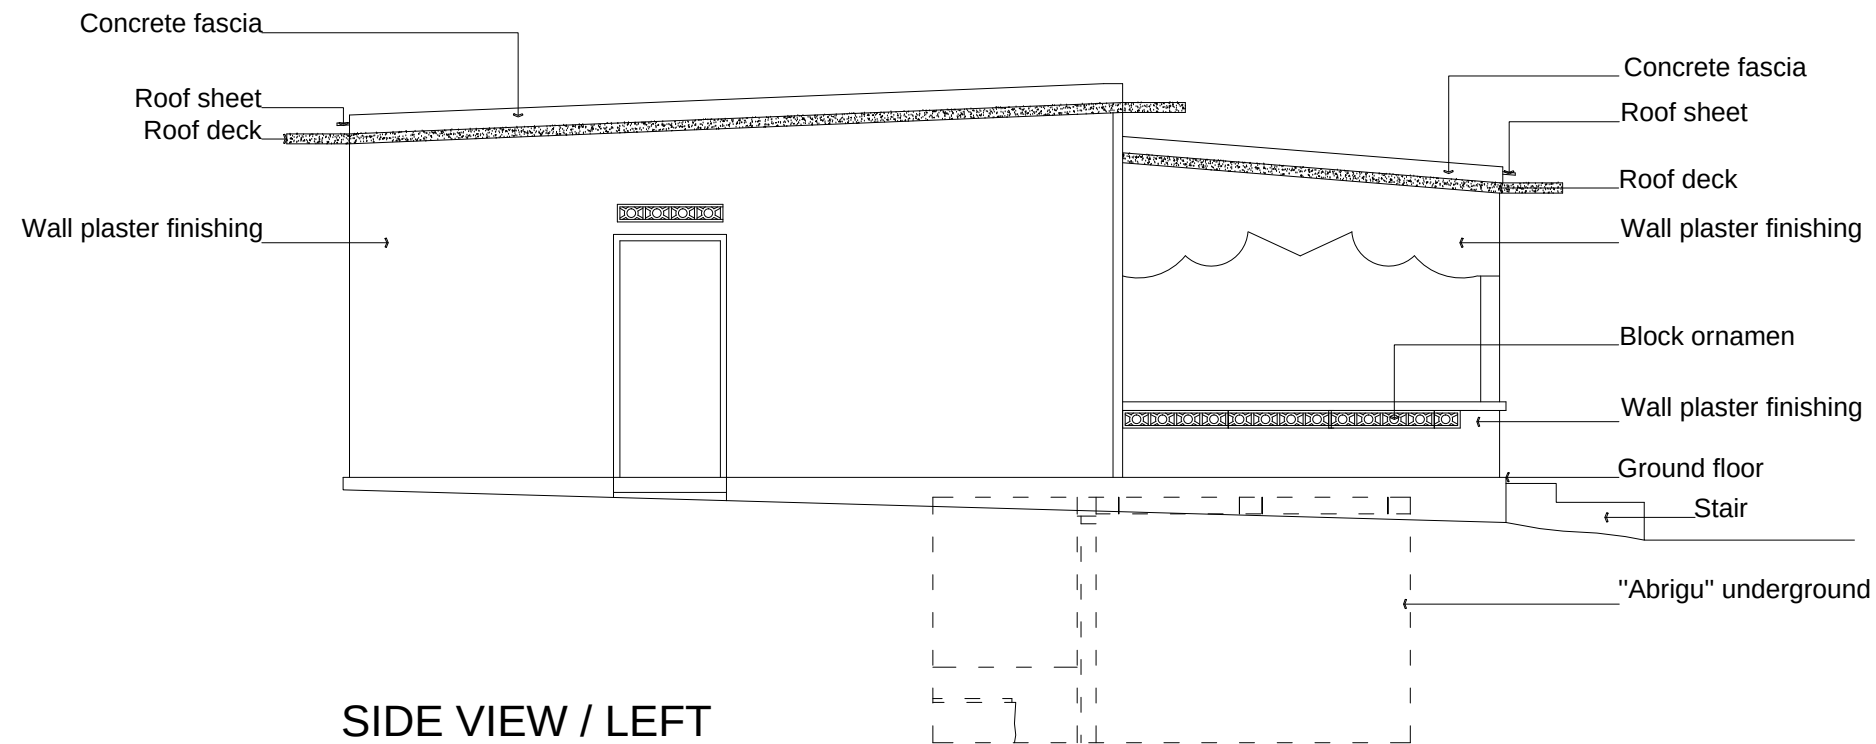

CLIENT / PROJECT OWNER	PREPARED BY	PROJECT TITLE	DRAWING TITLE	CONSULTANT DESIGN: A3R CONSULTANT		PROJECT OWNER	DEMOCRATIC REPUBLIC OF TIMOR LESTE MINISTRY OF PUBLIC WORK, TRANSPORT AND COMMUNICATION GENERAL DIRECTORATE OF PUBLIC WORKS NATIONAL DIRECTORATE OF BUILDING				SHEET NO:
		REHABILITAÇÃO DE ABRIGUS DA RESISTÊNCIA	ELEVATION	DRAWING BY:	APPROVED BY:	APPROVED BY:					05 OF 44
 ARQUIVO & MUSEU RESISTÊNCIA TIMORENSE INSTITUTO PÚBLICO REPÚBLICA DEMOCRÁTICA DE TIMOR LESTE Avenida Cidade de Lisboa, Dili, Timor Leste Phone: +670 - 77305782	ANGEL/AQUIRA Consultant, Unipessoal Lda. Architectural & Engineering Design, Supervision and Project Management Vila Verde, Dili, Timor - Leste, Phone: +670 - 7238140 E-mail: ino_neves@yahoo.com	ABRIGU LURBA LURBA, BOBONARO TIMOR LESTE LOCATION : BOBONARO	SCALE : 1:1500	Arch. Aquilino F. das Neves	Eng. Jesuino J.X. Neves	Sr. Hamar Antoninho Baptista Alves Director e Presidente AMRT	VERIFIED BY:	DATE	APPROVED BY:	DATE	DRAWING NO:
				DATE :	DATE :	DATE :	Eng. Octavio P. Marques, M.Eng. HEAD OF PROJECT DEPARTMENT		Arch. Rosa Amaral Vong Directress of DNE		ARCH 05 OF 44

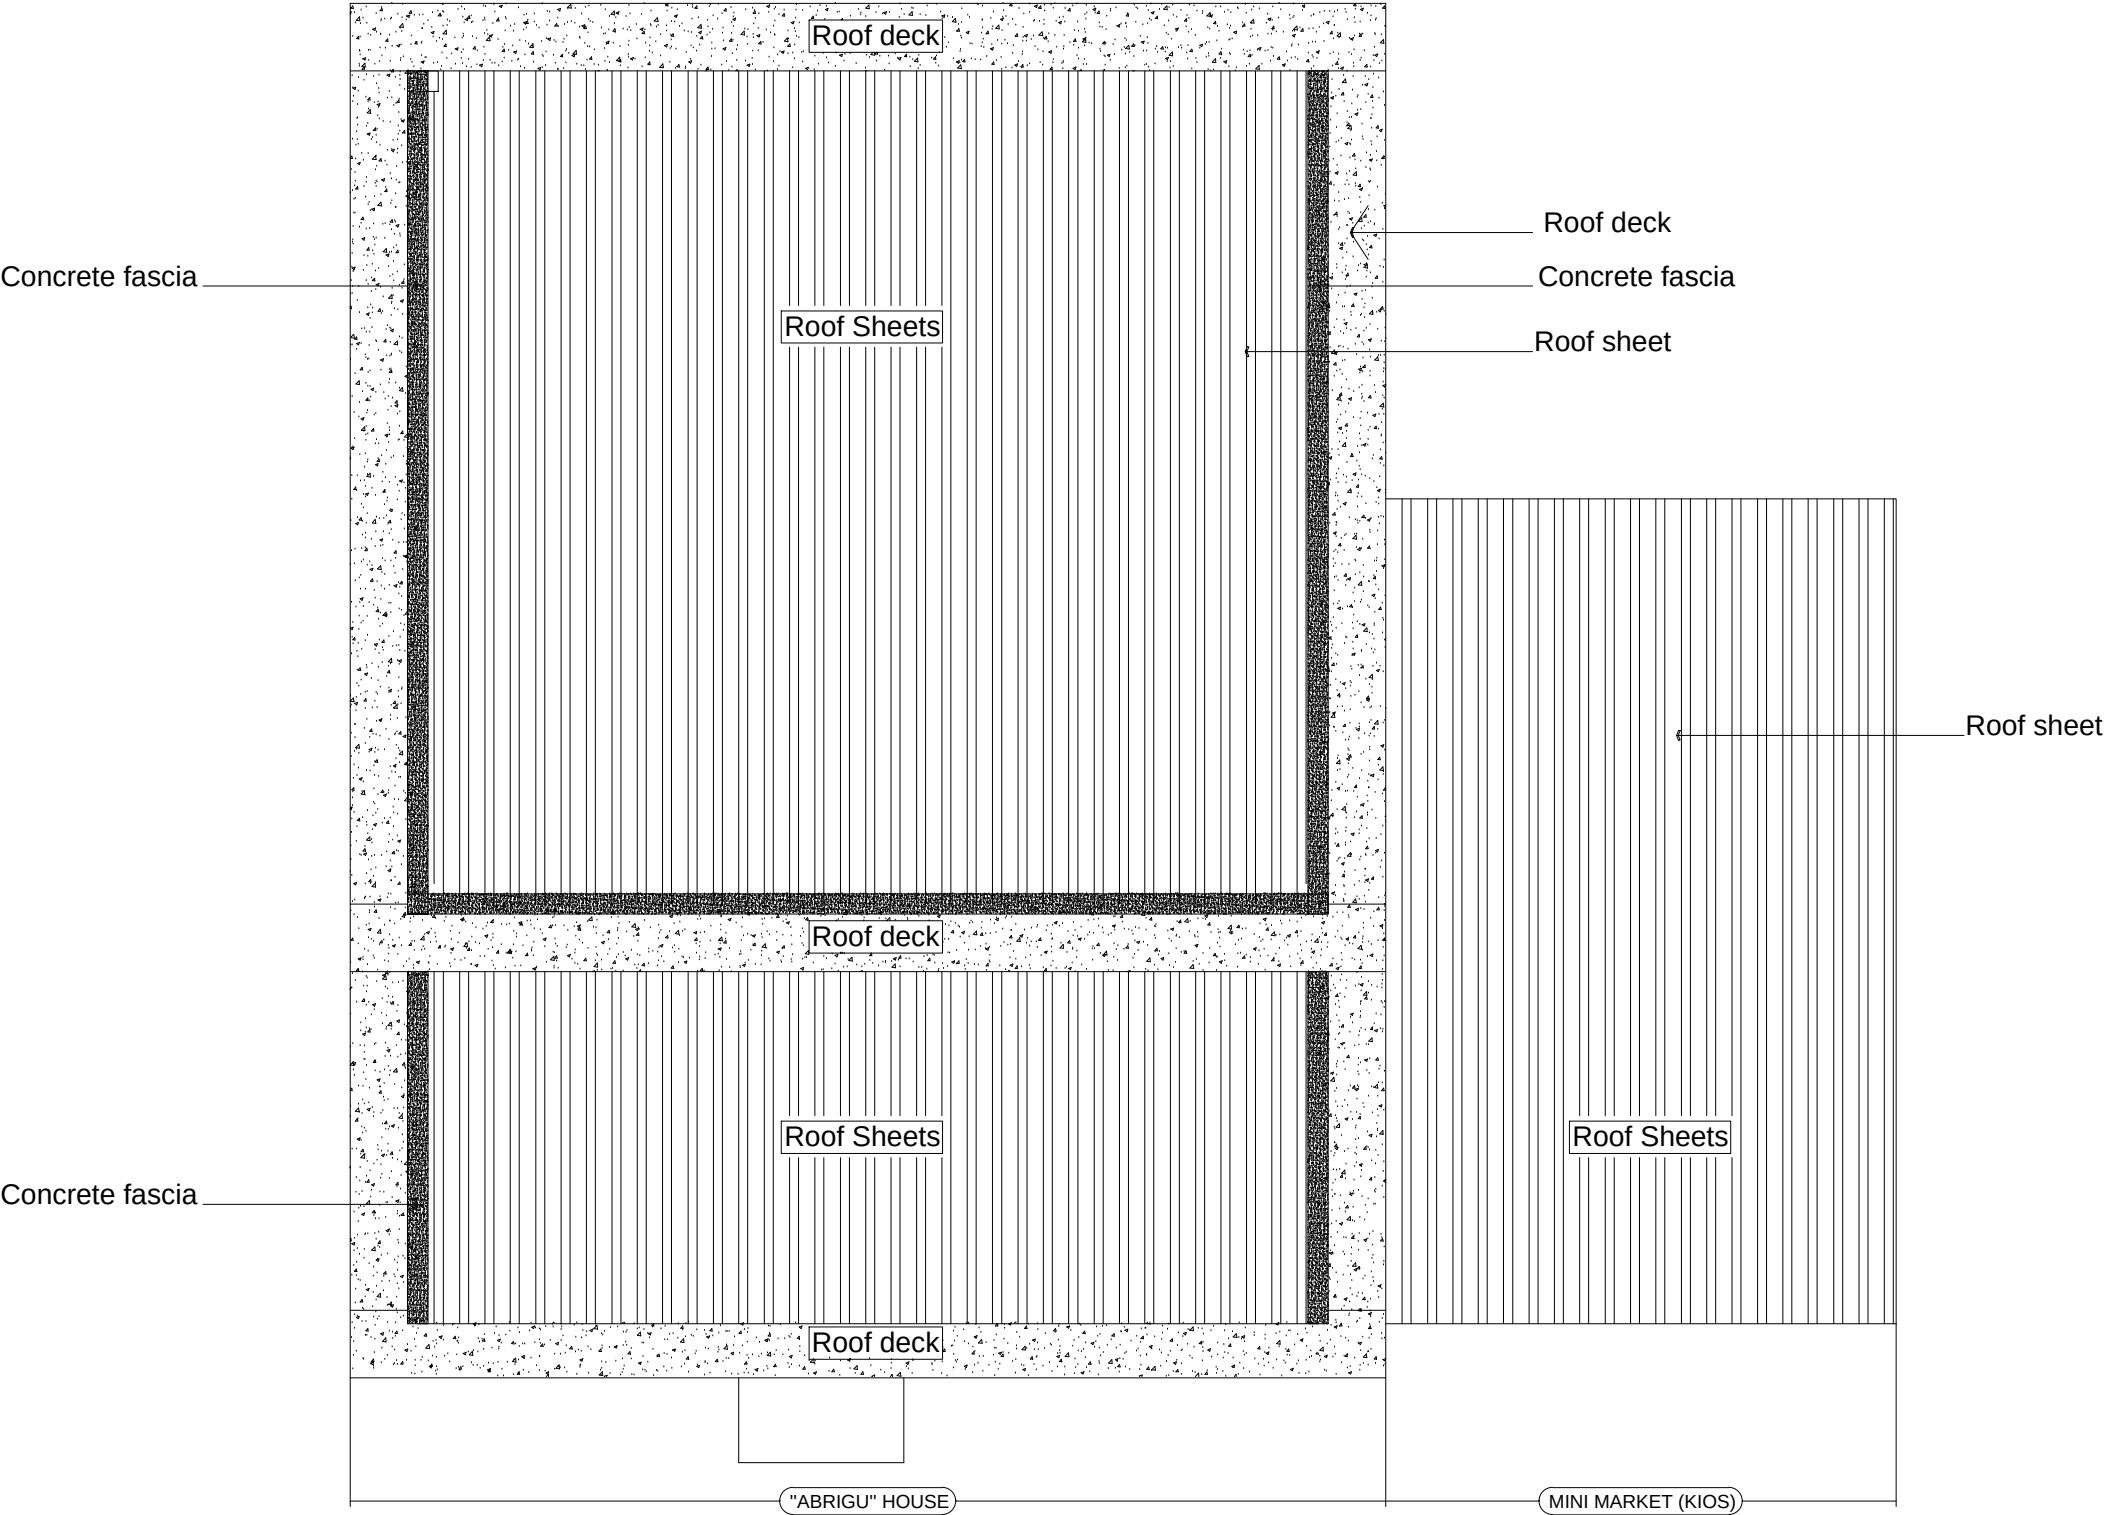

TOP ROOF

ELEVATION
1:1500

CLIENT / PROJECT OWNER  ARQUIVO & MUSEU RESISTÊNCIA TIMORENSE INSTITUTO PÚBLICO REPÚBLICA DEMOCRÁTICA DE TIMOR LESTE Avenida Cidade de Lisboa, Díli, Timor Leste Phone: +670 - 77305782	PREPARED BY  ANGEL'AQUIRA Consultant, Unipessoal Lda. Architectural & Engineering Design, Supervision and Project Management Vila Verde, Díli, Timor - Leste, Phone: +670 - 7238140 E-mail: ino_neves@yahoo.com	PROJECT TITLE REHABILITAÇÃO DE ABRIGUS DA RESISTÊNCIA ABRIGU LURBA LURBA, BOBONARO TIMOR LESTE LOCATION : BOBONARO	DRAWING TITLE ELEVATION SCALE : 1:1500	CONSULTANT DESIGN: A3R CONSULTANT		PROJECT OWNER DEMOCRATIC REPUBLIC OF TIMOR LESTE MINISTRY OF PUBLIC WORK, TRANSPORT AND COMMUNICATION GENERAL DIRECTORATE OF PUBLIC WORKS NATIONAL DIRECTORATE OF BUILDING VERIFIED BY: DATE APPROVED BY: DATE Eng. Octavio P. Marques, M.Eng. HEAD OF PROJECT DEPARTMENT Arch. Rosa Amaral Vong Directress of DNE	SHEET NO: 06 OF 44 DRAWING NO: ARCH 06 OF 44
				DRAWING BY:	APPROVED BY:		
				Arch. Aquilino F. das Neves	Eng. Jesuino J.X. Neves		
				DATE :	DATE :		

Architectural cross-section drawing of a building. The drawing shows the internal structure, including walls, floor, and roof. Key dimensions and materials are labeled:

- Concrete fascia 150mm x 150mm**
- Roof deck 80mm thickness x 500mm**
- Concrete fascia 150mm x 150mm**
- Top roof, zinalume roof sheets**
- Wooden purling $\frac{5}{7}$ cm**
- Dimensions:**
 - Overall height: 2900
 - Living room height: 2650
 - Living room width: 3000
 - Bed room width: 3000
 - Veranda width: 3000
 - Veranda depth: 400
 - Veranda floor height: 360
 - Veranda wall height: 700
 - Veranda wall thickness: 150
 - Veranda wall height from floor: 530
 - Veranda wall height from floor: 180
 - Veranda wall height from floor: 480
 - Veranda wall height from floor: 131
 - Veranda wall height from floor: 80
 - Veranda wall height from floor: 500
 - Veranda wall height from floor: 3130
 - Veranda wall height from floor: 3010
 - Veranda wall height from floor: 150
 - Veranda wall height from floor: 500
 - Veranda wall height from floor: 6205

Concrete fascia
150mm x 150mm

Roof deck 80mm
thickness x 500mm

Top roof, zincalume roof
sheets

Wooden rafter
/ trusses $6\frac{1}{2}$ cm

Didin Zincalume BMT
0.42mm(BSS Standart)

Abrigo iha rai okos

3490
3031

2737

200

500

1950

4000


2500

575


3000

SECTION B-B


CLIENT / PROJECT OWNER	PREPARED BY	PROJECT TITLE	DRAWING TITLE	CONSULTANT DESIGN: A3R CONSULTANT		PROJECT OWNER	DEMOCRATIC REPUBLIC OF TIMOR LESTE MINISTRY OF PUBLIC WORK, TRANSPORT AND COMMUNICATION GENERAL DIRECTORATE OF PUBLIC WORKS NATIONAL DIRECTORATE OF BUILDING				SHEET NO:
ARQUIVO & MUSEU RESISTÊNCIA TIMORENSE INSTITUTO PÚBLICO REPÚBLICA DEMOCRÁTICA DE TIMOR LESTE Avenida Cidade de Lisboa, Dili, Timor Leste Phone: +670 - 77305782	 ANGEL'AQUIRA Consultant, Unipessoal Lda. Architectural & Engineering Design, Supervision and Project Management Vila Verde, Dili, Timor - Leste, Phone: +670 - 7238140 E-mail: ino_neves@yahoo.com	REHABILITAÇÃO DE ABRIGUS DA RESISTÊNCIA	SECTION	DRAWING BY:	APPROVED BY:	APPROVED BY:					07 OF 44
		Arch. Aquilino F. das Neves		Eng. Jesuino J.X. Neves	Sr. Hamar Antoninho Baptista Alves Director e Presidente AMRT	Eng. Octavio P. Marques, M.Eng. HEAD OF PROJECT DEPARTMENT	Arch. Rosa Amaral Vong Directress of DNE		DRAWING NO: ARCH 07 OF 44		
		LOCATION : BOBONARO	SCALE : 1:1500	DATE :	DATE :	DATE :					

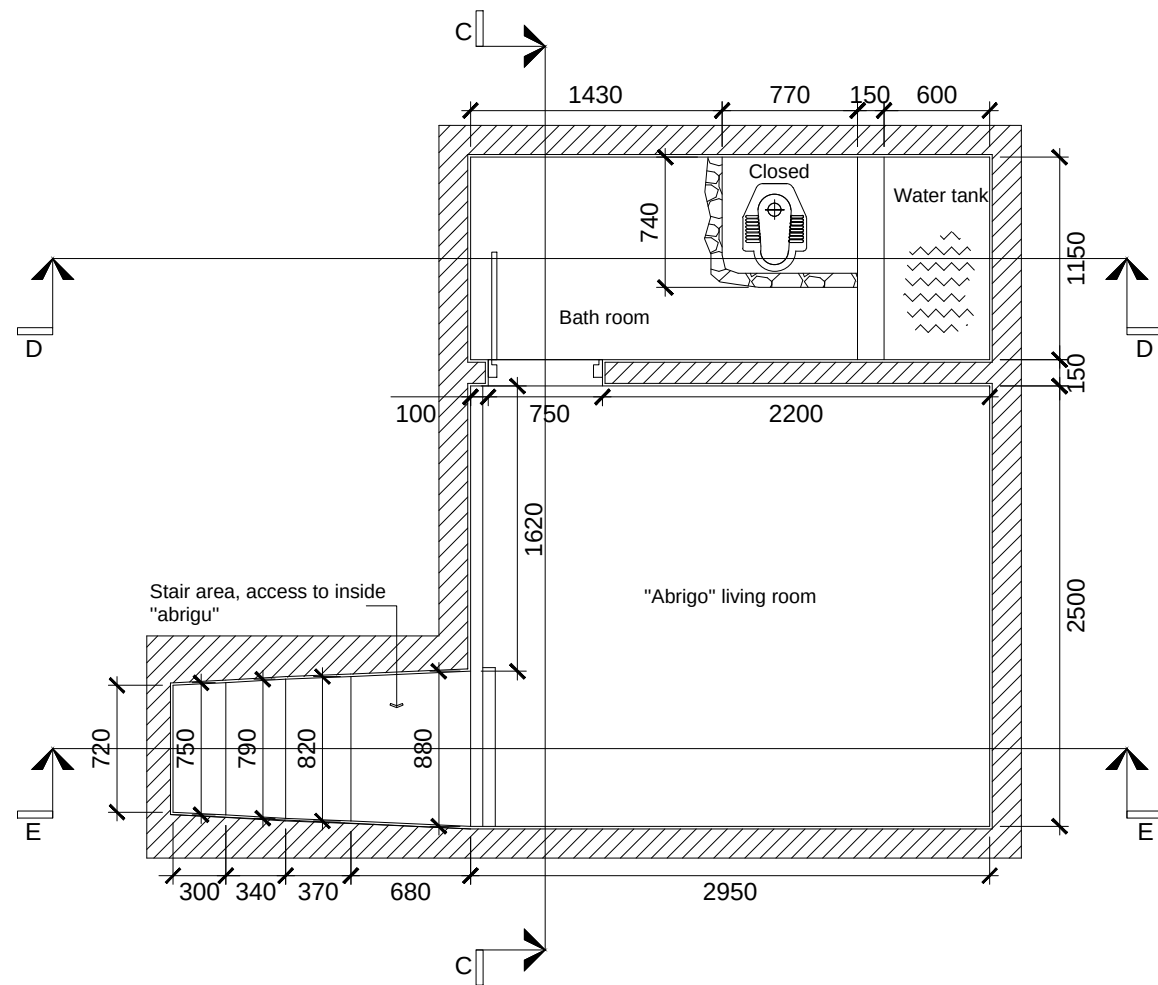

"ABRIGU" EXISTING PLAN

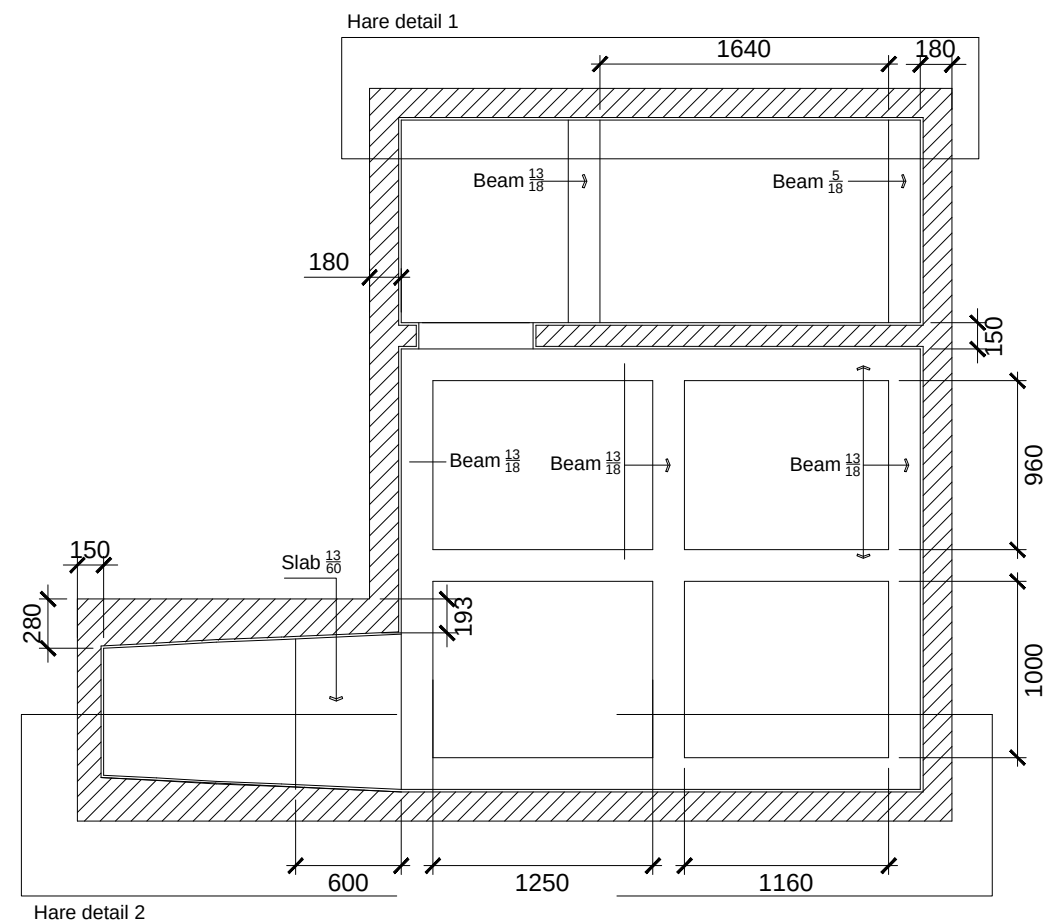


EXISTING TOP BEAM

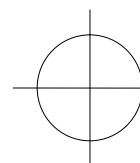


EXISTING PLAN AND BEAM
1:1000

CLIENT / PROJECT OWNER	PREPARED BY	PROJECT TITLE	DRAWING TITLE	CONSULTANT DESIGN: A3R CONSULTANT		PROJECT OWNER	DEMOCRATIC REPUBLIC OF TIMOR LESTE				SHEET NO:	
 ARQUIVO & MUSEU RESISTÊNCIA TIMORENSE INSTITUTO PÚBLICO REPÚBLICA DEMOCRÁTICA DE TIMOR LESTE Avenida Cidade de Lisboa, Dili, Timor Leste Phone: +670 - 77305782	 ANGEL'AQUIRA Consultant, Unipessoal Lda. Architectural & Engineering Design, Supervision and Project Management Vila Verde, Dili, Timor - Leste, Phone: +670 - 7238140 E-mail: ino_neves@yahoo.com	REHABILITAÇÃO DE ABRIGUS DA RESISTÊNCIA	"ABRIGU" EXISTING PLAN	DRAWING BY:	APPROVED BY:	APPROVED BY:	 DEMOCRATIC REPUBLIC OF TIMOR LESTE MINISTRY OF PUBLIC WORK, TRANSPORT AND COMMUNICATION GENERAL DIRECTORATE OF PUBLIC WORKS NATIONAL DIRECTORATE OF BUILDING				08 OF 44	
									VERIFIED BY:	DATE	APPROVED BY:	DATE
		LURBA, BOBONARO TIMOR LESTE		Arch. Aquilino F. das Neves	Eng. Jesuino J.X. Neves	Sr. Hamar Antoninho Baptista Alves Director e Presidente AMRT	Eng. Octavio P. Marques, M.Eng. HEAD OF PROJECT DEPARTMENT		Arch. Rosa Amaral Vong Directress of DNE		DRAWING NO: ARCH 08 OF 44	
		LOCATION : BOBONARO	SCALE : 1:1000	DATE :	DATE :	DATE :						

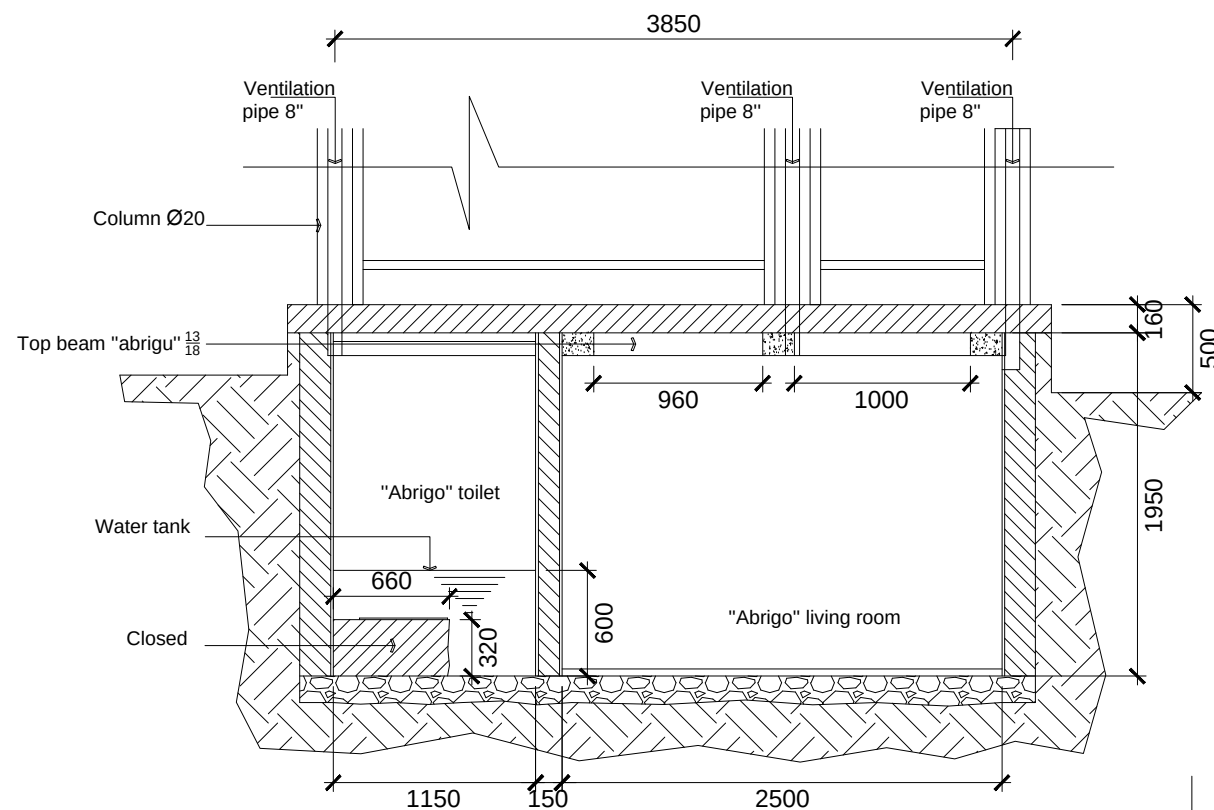


SECTION C-C

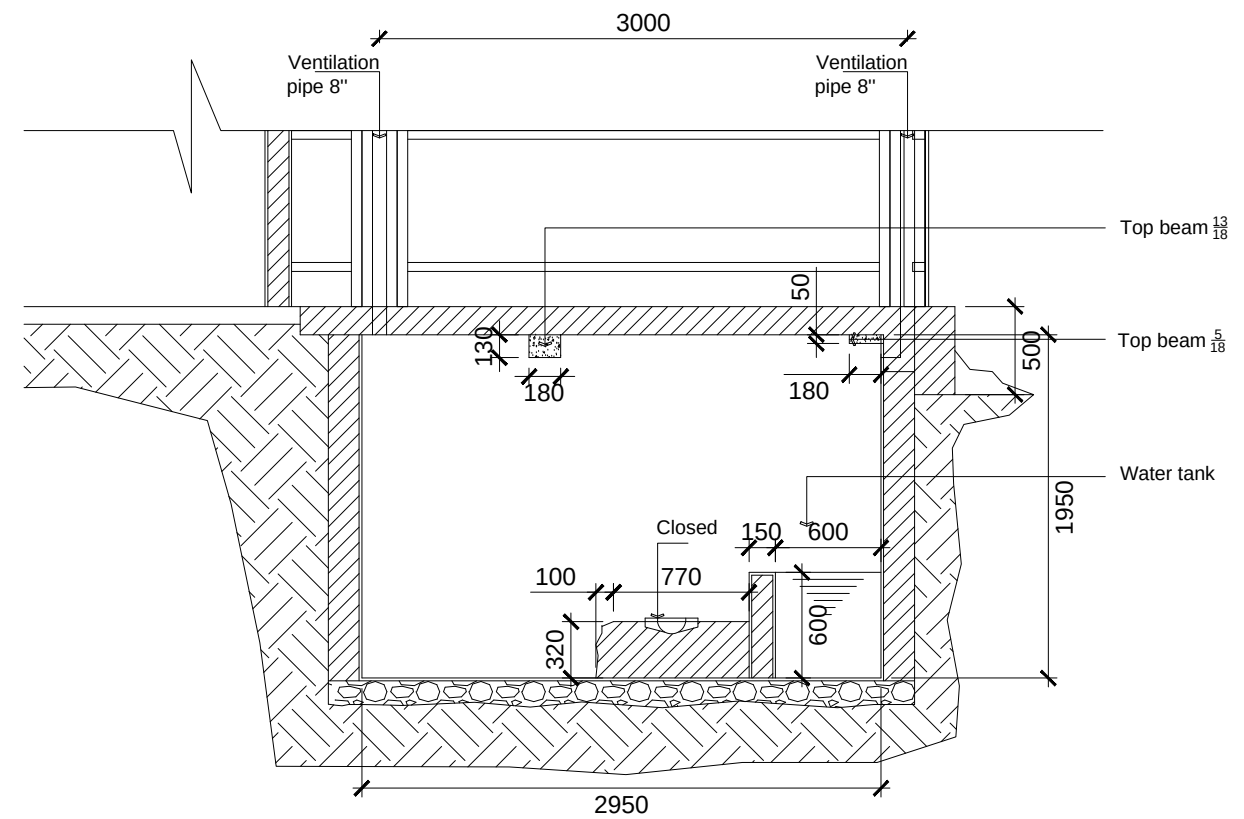


SECTION D-D

SECTION
1:1000

CLIENT / PROJECT OWNER	PREPARED BY	PROJECT TITLE	DRAWING TITLE	CONSULTANT DESIGN: A3R CONSULTANT		PROJECT OWNER	 DEMOCRATIC REPUBLIC OF TIMOR LESTE MINISTRY OF PUBLIC WORK, TRANSPORT AND COMMUNICATION GENERAL DIRECTORATE OF PUBLIC WORKS NATIONAL DIRECTORATE OF BUILDING				SHEET NO:
ARQUIVO & MUSEU RESISTÊNCIA TIMORENSE INSTITUTO PÚBLICO REPÚBLICA DEMOCRÁTICA DE TIMOR LESTE Avenida Cidade de Lisboa, Díli, Timor Leste Phone: +670 - 77305782	 ANGEL/AQUIRA Consultant, Unipessoal Lda. Architectural & Engineering Design, Supervision and Project Management Vila Verde, Díli, Timor - Leste, Phone: +670 - 7238140 E-mail: ino_neves@yahoo.com	REHABILITAÇÃO DE ABRIGOS DA RESISTÊNCIA ABRIGU LURBA LURBA, BOBONARO TIMOR LESTE LOCATION : BOBONARO	"ABRIGU" SECTION SCALE : 1:1000	DRAWING BY:	APPROVED BY:	APPROVED BY:					09 OF 44
				Arch. Aquilino F. das Neves	Eng. Jesuino J.X. Neves	Sr. Hamar Antoninho Baptista Alves Director e Presidente AMRT	VERIFIED BY:	DATE	APPROVED BY:	DATE	DRAWING NO:
				DATE :	DATE :	DATE :	Eng. Octavio P. Marques, M.Eng. HEAD OF PROJECT DEPARTMENT		Arch. Rosa Amaral Vong Directress of DNE		ARCH 09 OF 44

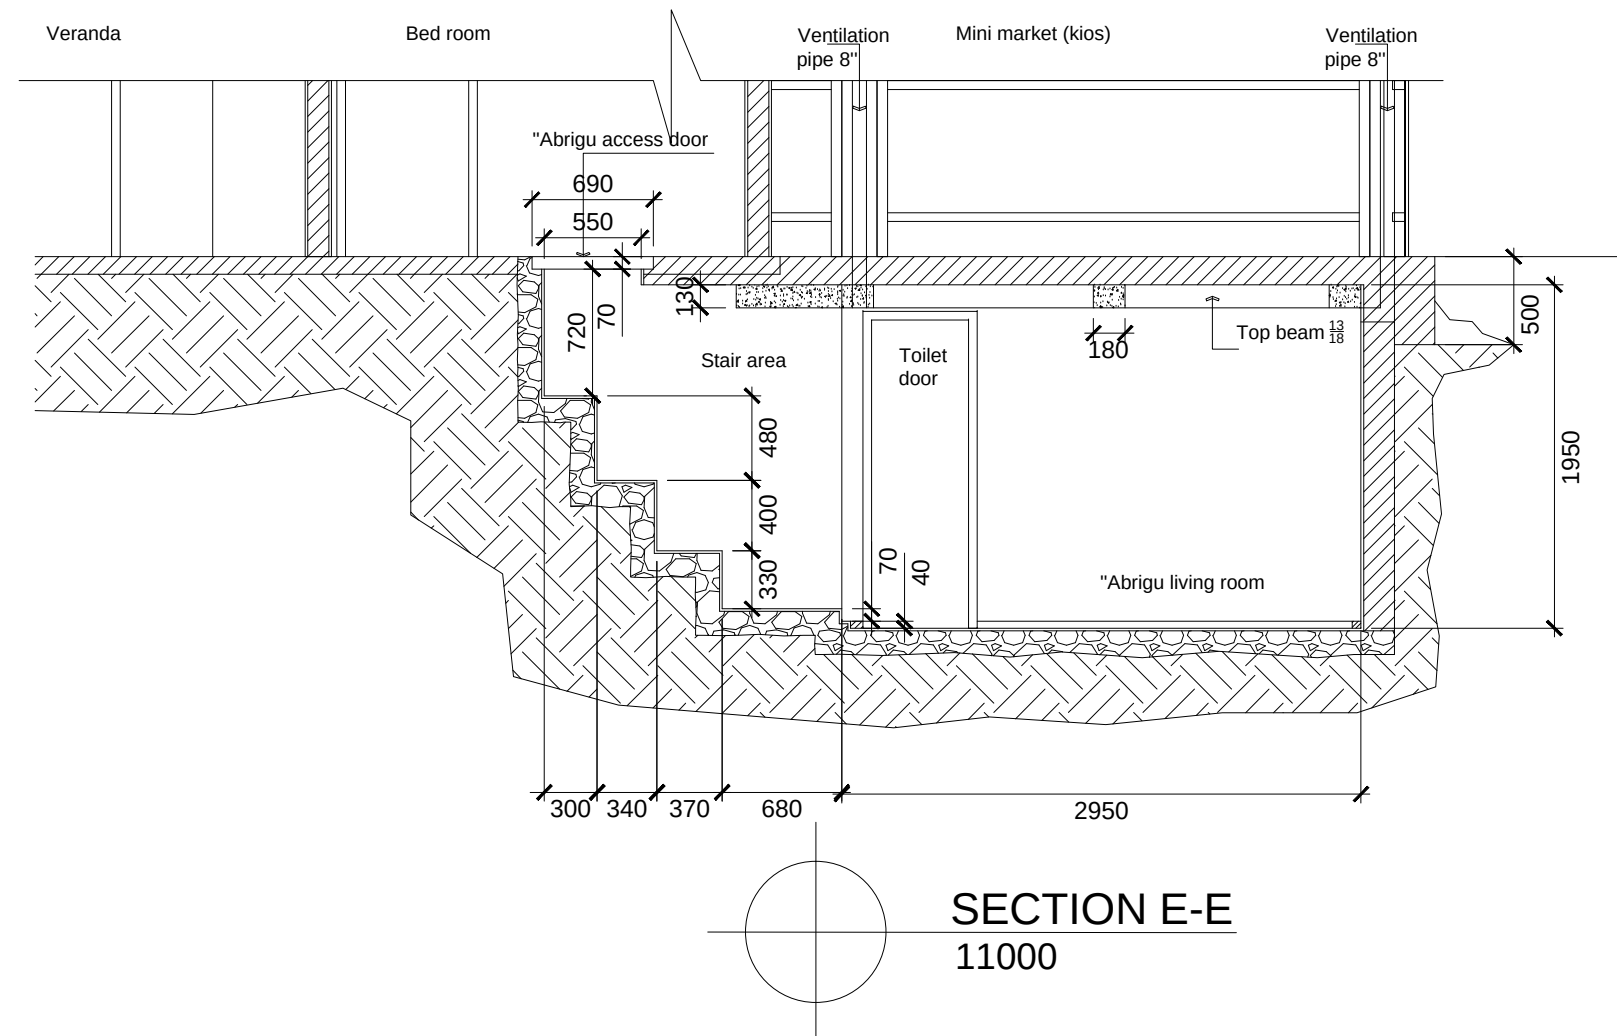

CLIENT / PROJECT OWNER		PREPARED BY	PROJECT TITLE	DRAWING TITLE	CONSULTANT DESIGN: A3R CONSULTANT		PROJECT OWNER		DEMOCRATIC REPUBLIC OF TIMOR LESTE MINISTRY OF PUBLIC WORK, TRANSPORT AND COMMUNICATION GENERAL DIRECTORATE OF PUBLIC WORKS NATIONAL DIRECTORATE OF BUILDING				SHEET NO:			
 ARQUIVO & MUSEU RESISTÊNCIA TIMORENSE INSTITUTO PÚBLICO REPÚBLICA DEMOCRÁTICA DE TIMOR LESTE Avenida Cidade de Lisboa, Dili, Timor Leste Phone: +670 - 77305782		 ANGEL'AQUIRA Consultant, Unipessoal Lda. Architectural & Engineering Design, Supervision and Project Management Vila Verde, Dili, Timor - Leste, Phone: +670 - 7238140 E-mail: ino_neves@yahoo.com	REHABILITAÇÃO DE ABRIGOS DA RESISTÊNCIA ABRIGU LURBA LURBA, BOBONARO TIMOR LESTE	"ABRIGU" SECTION	DRAWING BY:	APPROVED BY:	APPROVED BY:			VERIFIED BY:		DATE		APPROVED BY:	DATE	10 OF 44
					Arch. Aquilino F. das Neves	Eng. Jesuino J.X. Neves	Sr. Hamar Antoninho Baptista Alves Director e Presidente AMRT									
					DATE :	DATE :	DATE :									
LOCATION : BOBONARO			SCALE :	1:1000					Eng. Octavio P. Marques, M.Eng. HEAD OF PROJECT DEPARTMENT			Arch. Rosa Amaral Vong Directress of DNE			DRAWING NO: ARCH 10 OF 44	

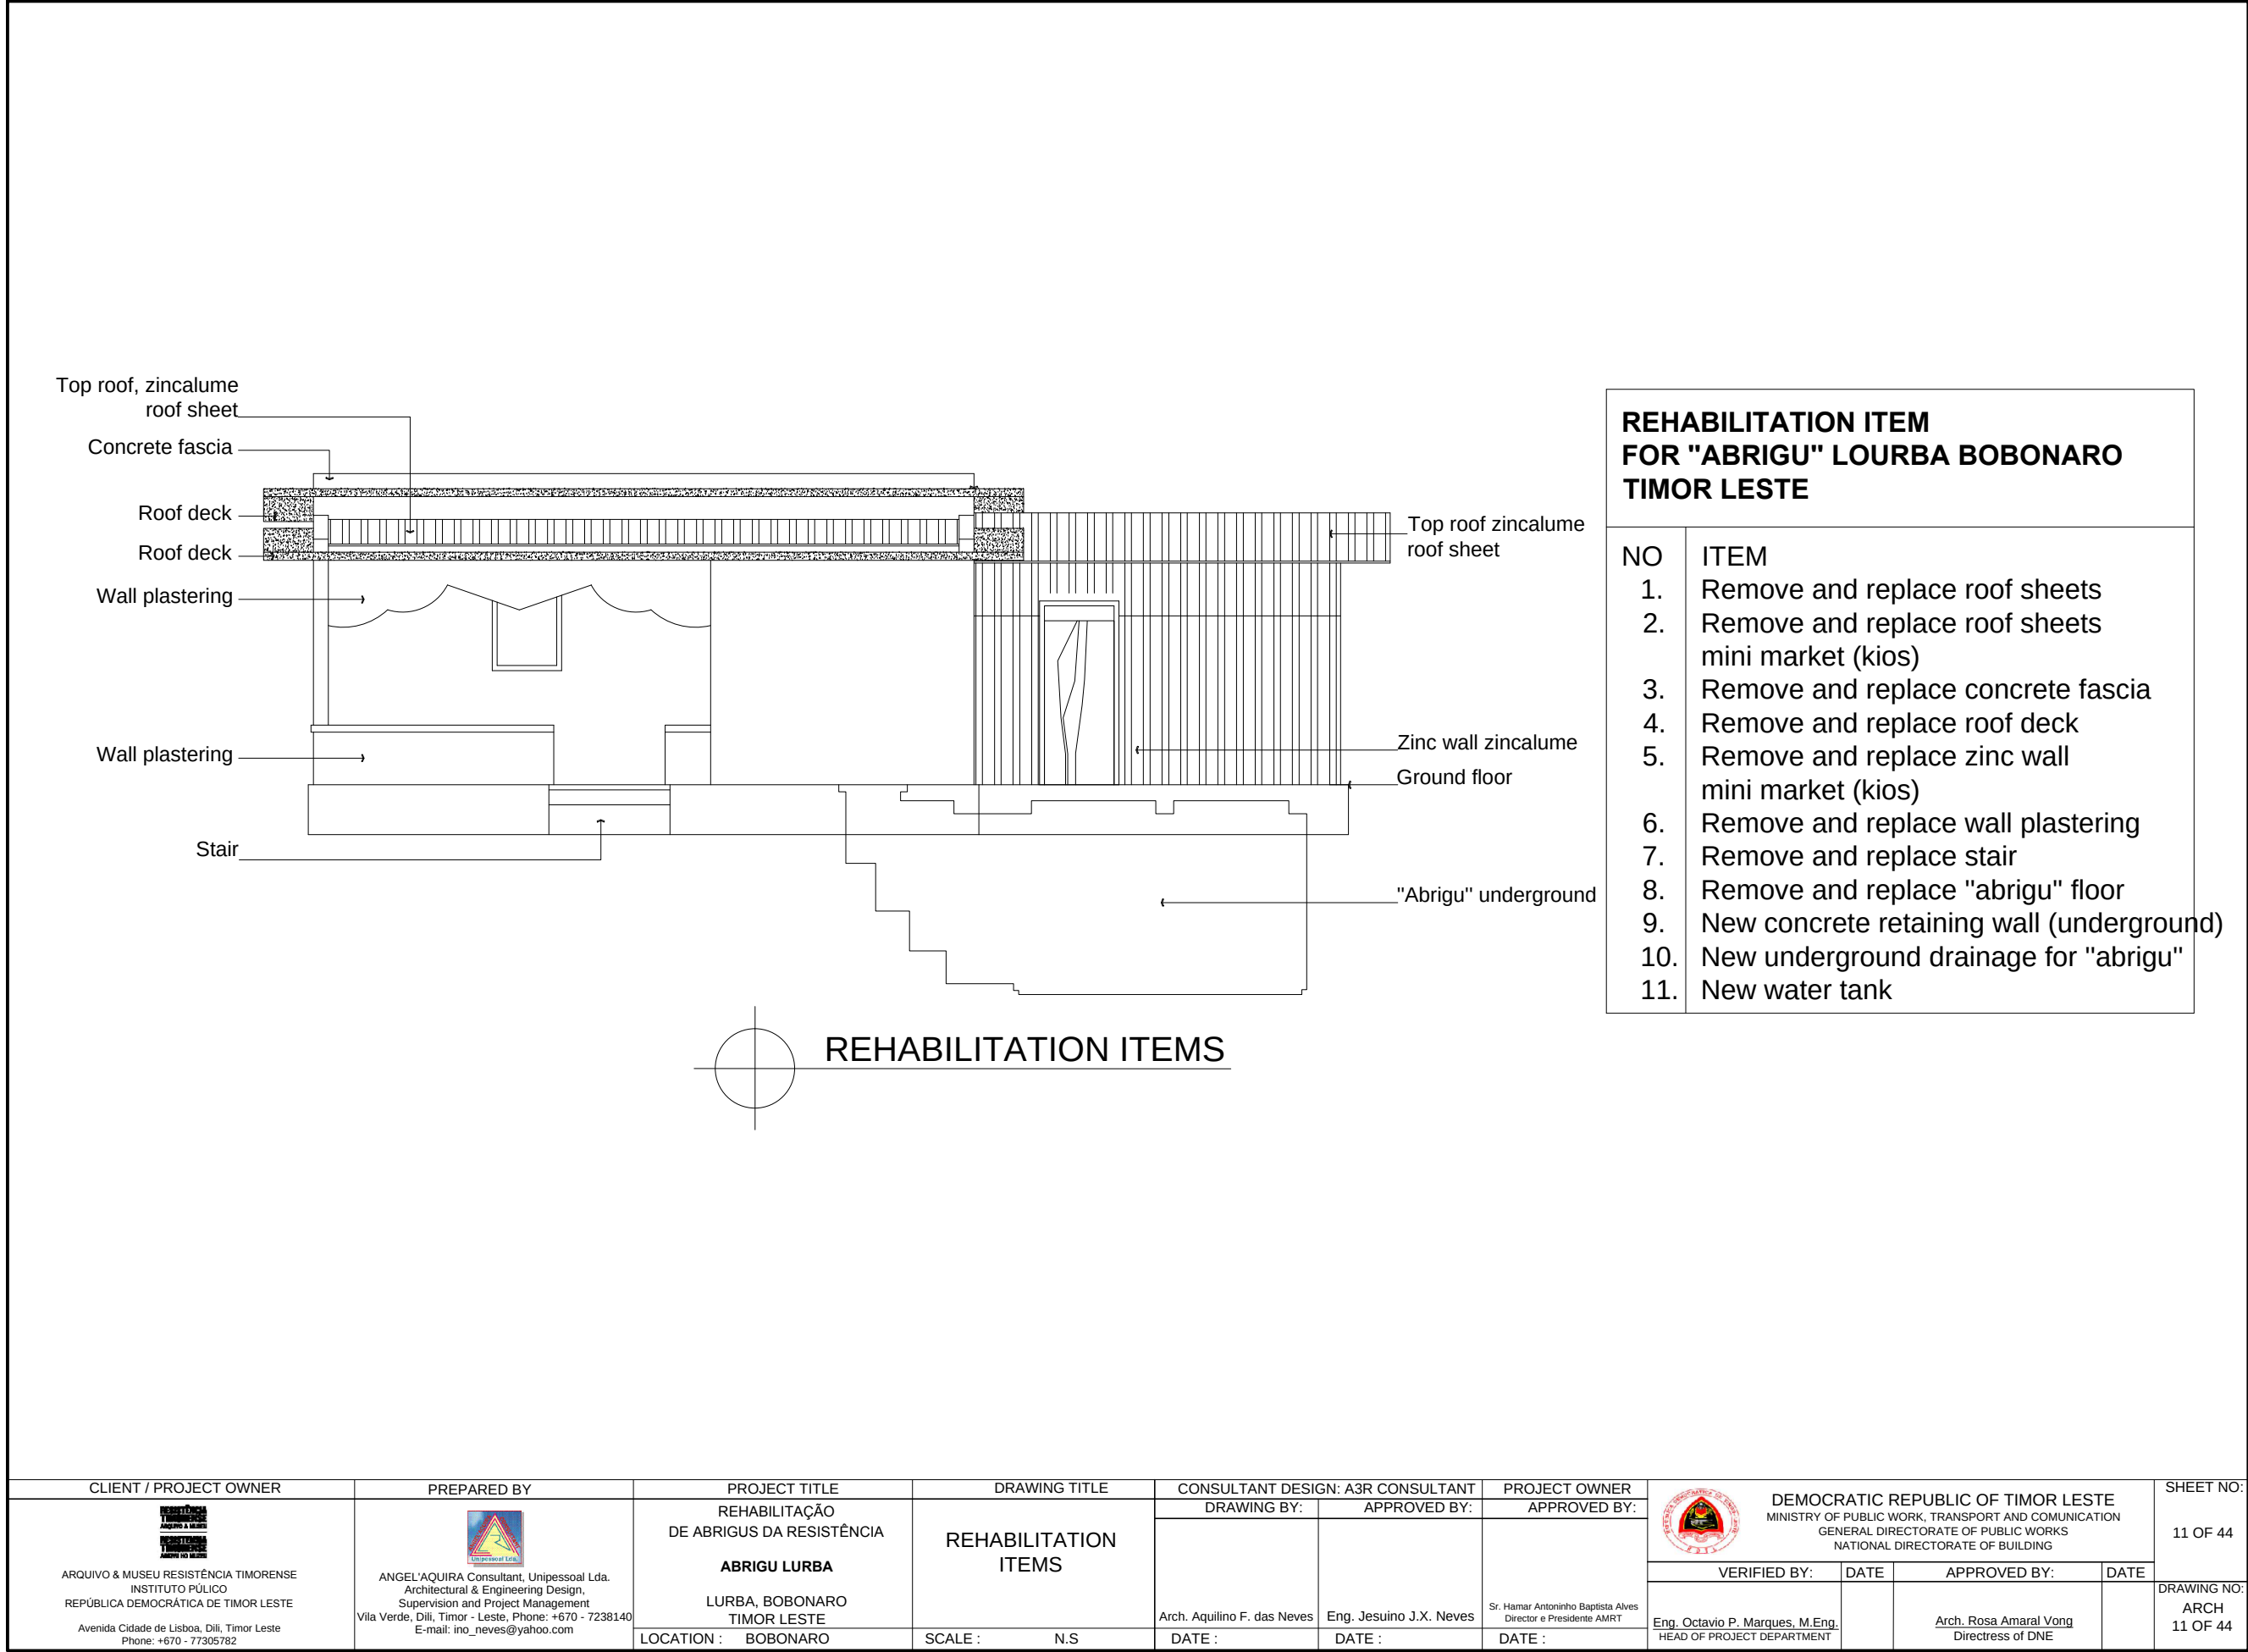



NO	ITEM
1.	Remove and replace zinc wall mini market (kios)



ZINC WALL MINI MARKET (KIOS)

CLIENT / PROJECT OWNER	PREPARED BY	PROJECT TITLE	DRAWING TITLE	CONSULTANT DESIGN: A3R CONSULTANT		PROJECT OWNER	DEMOCRATIC REPUBLIC OF TIMOR LESTE MINISTRY OF PUBLIC WORK, TRANSPORT AND COMMUNICATION GENERAL DIRECTORATE OF PUBLIC WORKS NATIONAL DIRECTORATE OF BUILDING				SHEET NO:	
 ARQUIVO & MUSEU RESISTÊNCIA TIMORENSE INSTITUTO PÚBLICO REPÚBLICA DEMOCRÁTICA DE TIMOR LESTE Avenida Cidade de Lisboa, Dili, Timor Leste Phone: +670 - 77305782	ANGEL'AQUIRA Consultant, Unipessoal Lda. Architectural & Engineering Design, Supervision and Project Management Vila Verde, Dili, Timor - Leste, Phone: +670 - 7238140 E-mail: ino_neves@yahoo.com	REHABILITAÇÃO DE ABRIGUS DA RESISTÊNCIA	ZINC WALL	DRAWING BY:	APPROVED BY:	APPROVED BY:						13 OF 44
		ABRIGU LURBA						VERIFIED BY:	DATE	APPROVED BY:	DATE	
		LURBA, BOBONARO TIMOR LESTE		Arch. Aquilino F. das Neves	Eng. Jesuino J.X. Neves	Sr. Hamar Antoninho Baptista Alves Director e Presidente AMRT						DRAWING NO: ARCH 13 OF 44
		LOCATION : BOBONARO	SCALE : 1:1500	DATE :	DATE :	DATE :	Eng. Octavio P. Marques, M.Eng. HEAD OF PROJECT DEPARTMENT			Arch. Rosa Amaral Vong Directress of DNE		

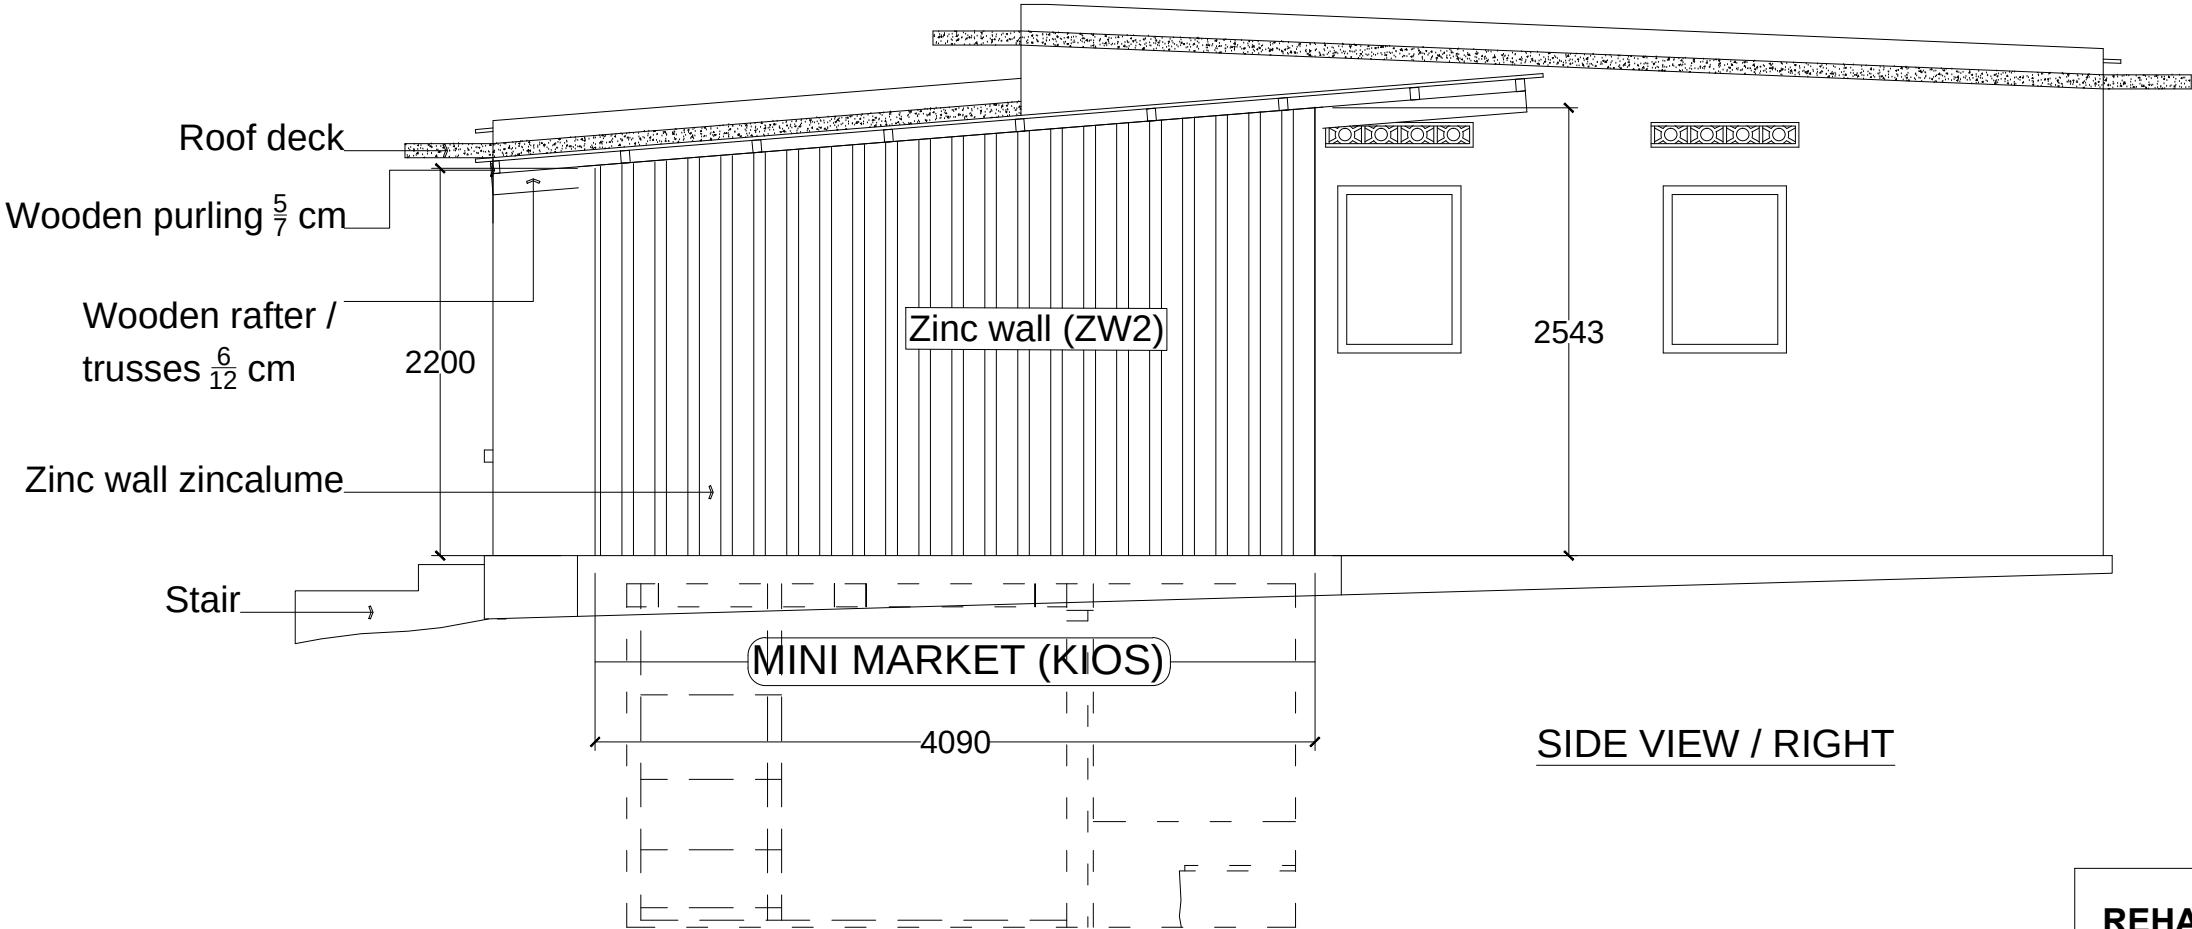

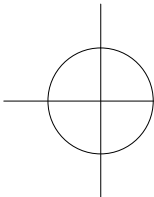
 **ZINC WALL MINI MARKET (KIOS)**
1:1000

**REHABILITATION ITEM
FOR "ABRIGU" LOURBA
BOBONARO
TIMOR LESTE**

NO ITEM

- | | |
|----|---|
| 1. | Remove and replace zinc wall mini market (kios) |
|----|---|

CLIENT / PROJECT OWNER		PREPARED BY	PROJECT TITLE	DRAWING TITLE	CONSULTANT DESIGN: A3R CONSULTANT		PROJECT OWNER	 DEMOCRATIC REPUBLIC OF TIMOR LESTE MINISTRY OF PUBLIC WORK, TRANSPORT AND COMMUNICATION GENERAL DIRECTORATE OF PUBLIC WORKS NATIONAL DIRECTORATE OF BUILDING				SHEET NO: 14 OF 44
 ARQUIVO & MUSEU RESISTÊNCIA TIMORENSE INSTITUTO PÚBLICO REPÚBLICA DEMOCRÁTICA DE TIMOR LESTE Avenida Cidade de Lisboa, Dili, Timor Leste Phone: +670 - 77305782		 ANGEL'AQUIRA Consultant, Unipessoal Lda. Architectural & Engineering Design, Supervision and Project Management Vila Verde, Dili, Timor - Leste, Phone: +670 - 7238140 E-mail: ino_neves@yahoo.com	REHABILITAÇÃO DE ABRIGUS DA RESISTÊNCIA ABRIGU LURBA LURBA, BOBONARO TIMOR LESTE	ZINC WALL	DRAWING BY: Arch. Aquilino F. das Neves	APPROVED BY: Eng. Jesuino J.X. Neves	APPROVED BY: Sr. Hamar Antoninho Baptista Alves Director e Presidente AMRT					
LOCATION : BOBONARO		SCALE : 1:1000		DATE :	DATE :	DATE :	DATE :	VERIFIED BY:	DATE	APPROVED BY:	DATE	DRAWING NO: ARCH 14 OF 44

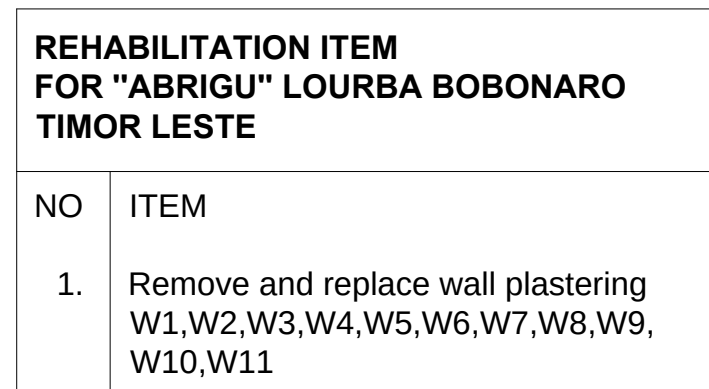


Architectural drawing showing the back view of a building. The drawing includes a wall with a window labeled 'W6' and a door. Dimensions are provided: a vertical dimension of 2650 for the wall height and a horizontal dimension of 6650 for the wall width. The drawing is labeled 'BACK VIEW' and includes a 'Ground floor' label.


BACK VIEW

1:1500

CLIENT / PROJECT OWNER		PREPARED BY	PROJECT TITLE	DRAWING TITLE		CONSULTANT DESIGN: A3R CONSULTANT		PROJECT OWNER	DEMOCRATIC REPUBLIC OF TIMOR LESTE MINISTRY OF PUBLIC WORK, TRANSPORT AND COMMUNICATION GENERAL DIRECTORATE OF PUBLIC WORKS NATIONAL DIRECTORATE OF BUILDING				SHEET NO:
 ARQUIVO & MUSEU RESISTÊNCIA TIMORENSE INSTITUTO PÚBLICO REPÚBLICA DEMOCRÁTICA DE TIMOR LESTE Avenida Cidade de Lisboa, Dili, Timor Leste Phone: +670 - 72305782		 ANGEL/AQUIRA Consultant, Unipessoal Lda. Architectural & Engineering Design, Supervision and Project Management Vila Verde, Dili, Timor - Leste. Phone: +670 - 72381140 E-mail: ino_neves@yahoo.com	REHABILITAÇÃO DE ABRIGOS DA RESISTÊNCIA	WALL PLASTERING		DRAWING BY:	APPROVED BY:	APPROVED BY:					15 OF 44
			ABRIGU LURBA										
			LURBA, BOBONARO TIMOR LESTE			Arch. Aquilino F. das Neves	Eng. Jesuino J.X. Neves	Sr. Hamar Antoninho Baptista Alves Director e Presidente AMRT	Eng. Octavio P. Marques, M.Eng. HEAD OF PROJECT DEPARTMENT		Arch. Rosa Amaral Vong Directress of DNE		DRAWING NO: ARCH 15 OF 44
			LOCATION : BOBONARO	SCALE :	1:1500	DATE :	DATE :	DATE :	DATE :	DATE :	DATE :		

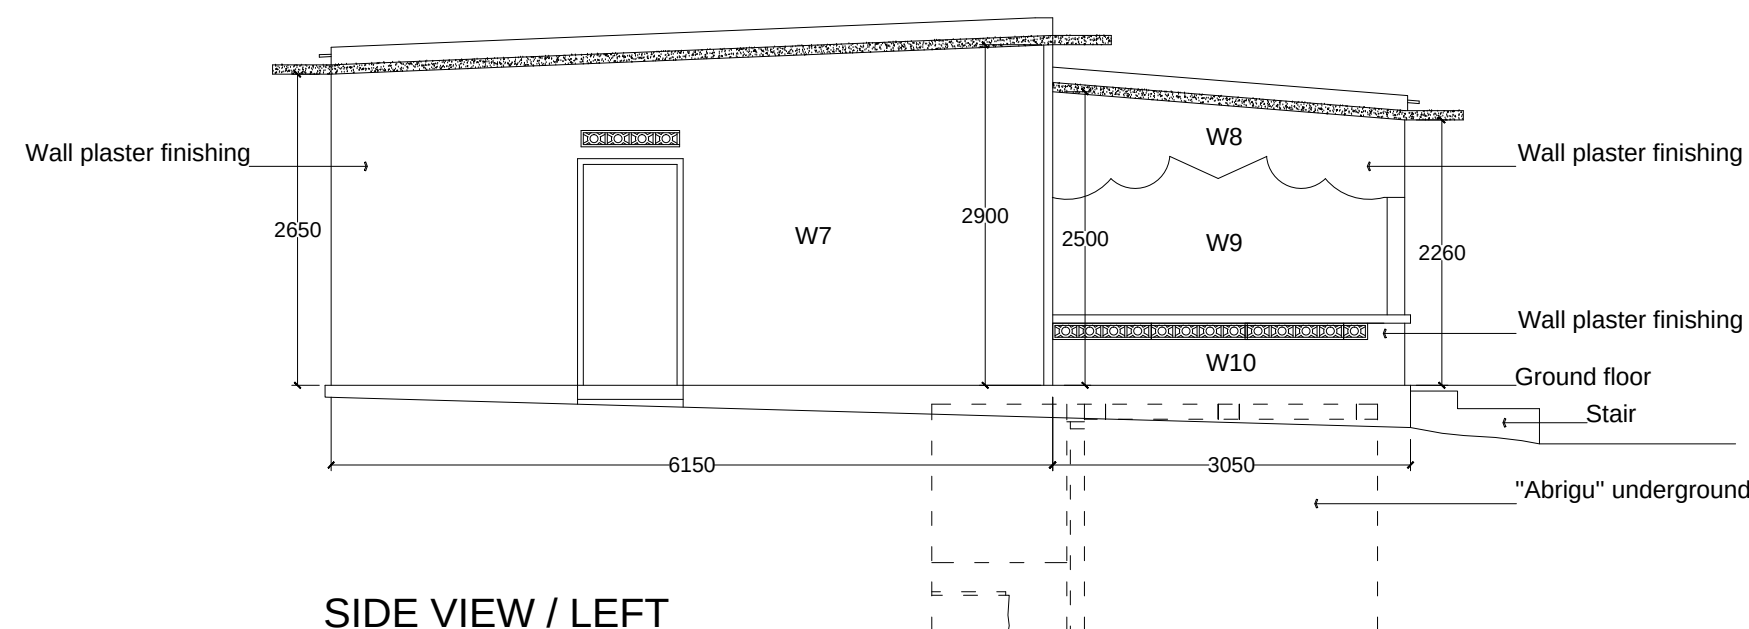

SIDE VIEW / LEFT

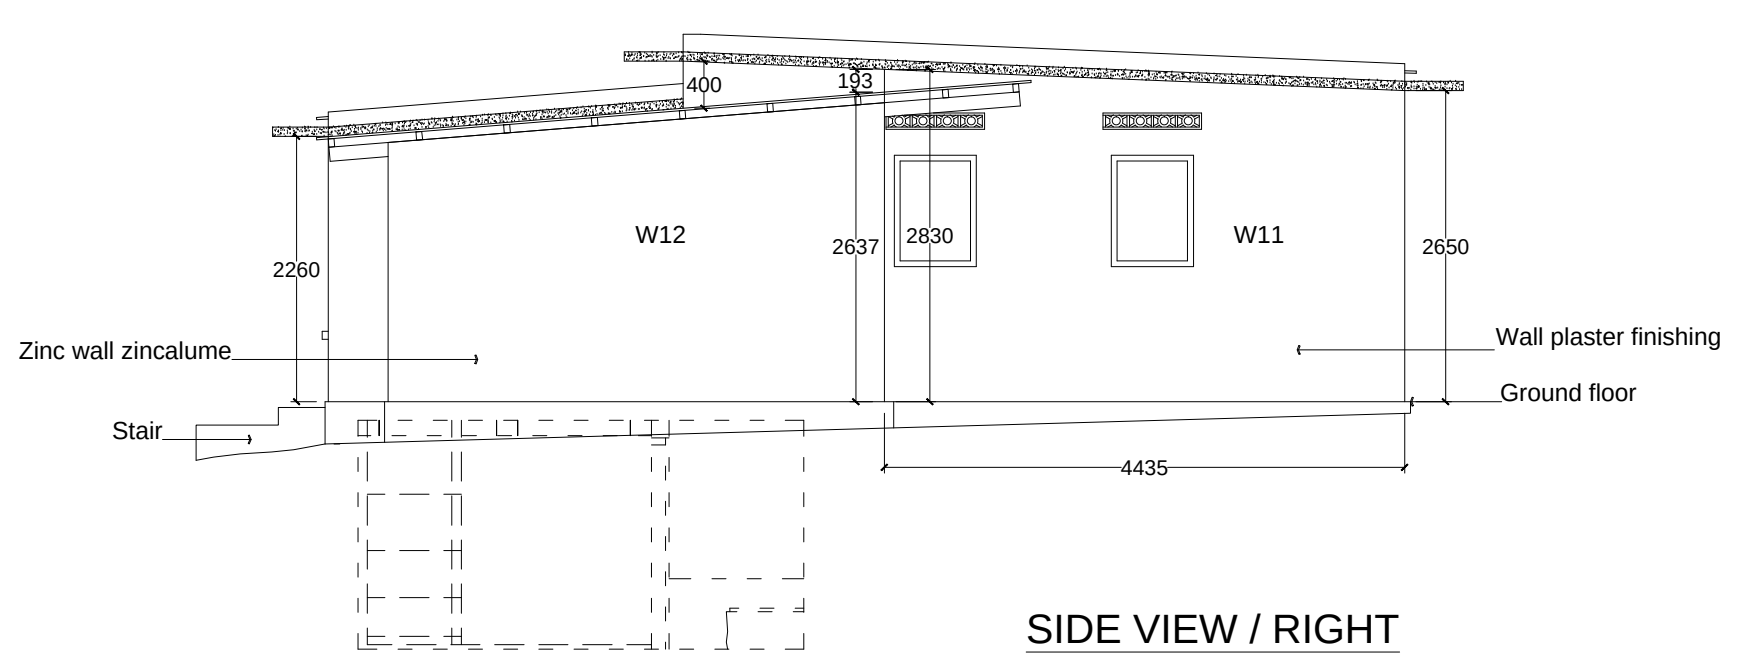

SIDE VIEW / RIGHT

WALL PLASTERING
1:1500

REHABILITATION ITEM FOR "ABRIGU" LOURBA BOBONARO TIMOR LESTE	
NO	ITEM
1.	Remove and replace wall plastering W1,W2,W3,W4,W5,W6,W7,W8,W9, W10, W11

CLIENT / PROJECT OWNER		PREPARED BY	PROJECT TITLE	DRAWING TITLE	CONSULTANT DESIGN: A3R CONSULTANT		PROJECT OWNER	DEMOCRATIC REPUBLIC OF TIMOR LESTE MINISTRY OF PUBLIC WORK, TRANSPORT AND COMMUNICATION GENERAL DIRECTORATE OF PUBLIC WORKS NATIONAL DIRECTORATE OF BUILDING				SHEET NO: 16 OF 44
ARQUIVO & MUSEU RESISTÊNCIA TIMORENSE INSTITUTO PÚBLICO REPÚBLICA DEMOCRÁTICA DE TIMOR LESTE Avenida Cidade de Lisboa, Dili, Timor Leste Phone: +670 - 77305782		ANGEL'AQUIRA Consultant, Unipessoal Lda. Architectural & Engineering Design, Supervision and Project Management Vila Verde, Dili, Timor - Leste, Phone: +670 - 7238140 E-mail: ino_neves@yahoo.com	REHABILITAÇÃO DE ABRIGUS DA RESISTÊNCIA ABRIGU LURBA LURBA, BOBONARO TIMOR LESTE	WALL PLASTERING	DRAWING BY:	APPROVED BY:	APPROVED BY:					
					Arch. Aquilino F. das Neves	Eng. Jesuino J.X. Neves	Sr. Hamar Antoninho Baptista Alves Director e Presidente AMRT	VERIFIED BY:	DATE	APPROVED BY:	DATE	
			LOCATION : BOBONARO	SCALE : 1:1500	DATE :	DATE :	DATE :	Eng. Octavio P. Marques, M.Eng. HEAD OF PROJECT DEPARTMENT		Arch. Rosa Amaral Vong Directress of DNE		DRAWING NO: ARCH 16 OF 44

Technical drawing of a building elevation showing a cross-section. The drawing includes the following dimensions and specifications:


- Overall height: 3490
- Height to the top of the wall: 3031
- Height to the top of the roof structure: 2737
- Height of the base: 360
- Horizontal dimensions (from left to right): 2500, 4000, 575, 3000
- Labels for wall sections: W14, W15
- Roof structure: Wooden rafter / trusses $\frac{6}{12}$ cm
- Roofing material: Didin Zincalume BMT 0.42mm(BSS Standard)
- Detail dimension: 200

Architectural cross-section drawing of a building structure. The drawing shows the internal layout with rooms labeled W3 and W13. Key structural elements and dimensions are indicated:


- Wooden rafter / trusses:** 6/12 cm
- Didin Zinalume BMT:** 0.42mm(BSS Standart)
- Abrigo iha rai okos:** 1950
- Dimensions:**
 - Overall height: 3490
 - Height from ground to ceiling: 3031
 - Height from ground to roof structure: 2737
 - Height from ground to floor level: 500
 - Height from floor level to roof structure: 1950
 - Overall width: 4000
 - Width of W3: 2500
 - Width of W13: 575
 - Width of the rightmost section: 3000

CLIENT / PROJECT OWNER	PREPARED BY	PROJECT TITLE	DRAWING TITLE	CONSULTANT DESIGN: A3R CONSULTANT		PROJECT OWNER	 DEMOCRATIC REPUBLIC OF TIMOR LESTE MINISTRY OF PUBLIC WORK, TRANSPORT AND COMMUNICATION GENERAL DIRECTORATE OF PUBLIC WORKS NATIONAL DIRECTORATE OF BUILDING				SHEET NO:
 ARQUIVO & MUSEU RESISTÊNCIA TIMORENSE INSTITUTO PÚBLICO REPÚBLICA DEMOCRÁTICA DE TIMOR LESTE Avenida Cidade de Lisboa, Dili, Timor Leste Phone: +670 - 77305782	 ANGEL'AQUIRA Consultant, Unipessoal Lda. Architectural & Engineering Design, Supervision and Project Management Vila Verde, Dili, Timor - Leste, Phone: +670 - 7238140 E-mail: ino_neves@yahoo.com	REHABILITAÇÃO DE ABRIGUS DA RESISTÊNCIA	WALL PLASTERING	DRAWING BY:	APPROVED BY:	APPROVED BY:					17 OF 44
				Arch. Aquilino F. das Neves	Eng. Jesuino J.X. Neves	Sr. Hamar Antoninho Baptista Alves Director e Presidente AMRT					
				DATE :	DATE :	DATE :	VERIFIED BY:DATEAPPROVED BY:DATE				
LOCATION : BOBONARO				SCALE : 1:1500			Eng. Octavio P. Marques, M.Eng. HEAD OF PROJECT DEPARTMENT	Arch. Rosa Amaral Vong Directress of DNE		DRAWING NO: ARCH 17 OF 44	

VIEW W9, W16, W17

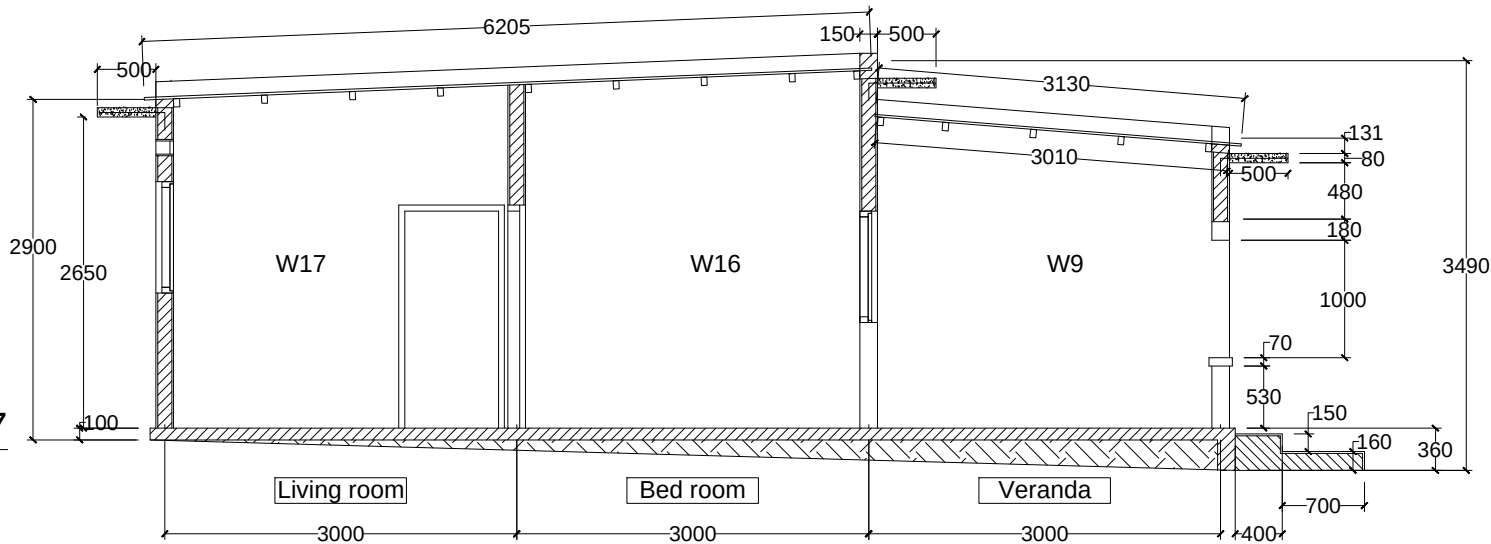


VIEW W13, W14

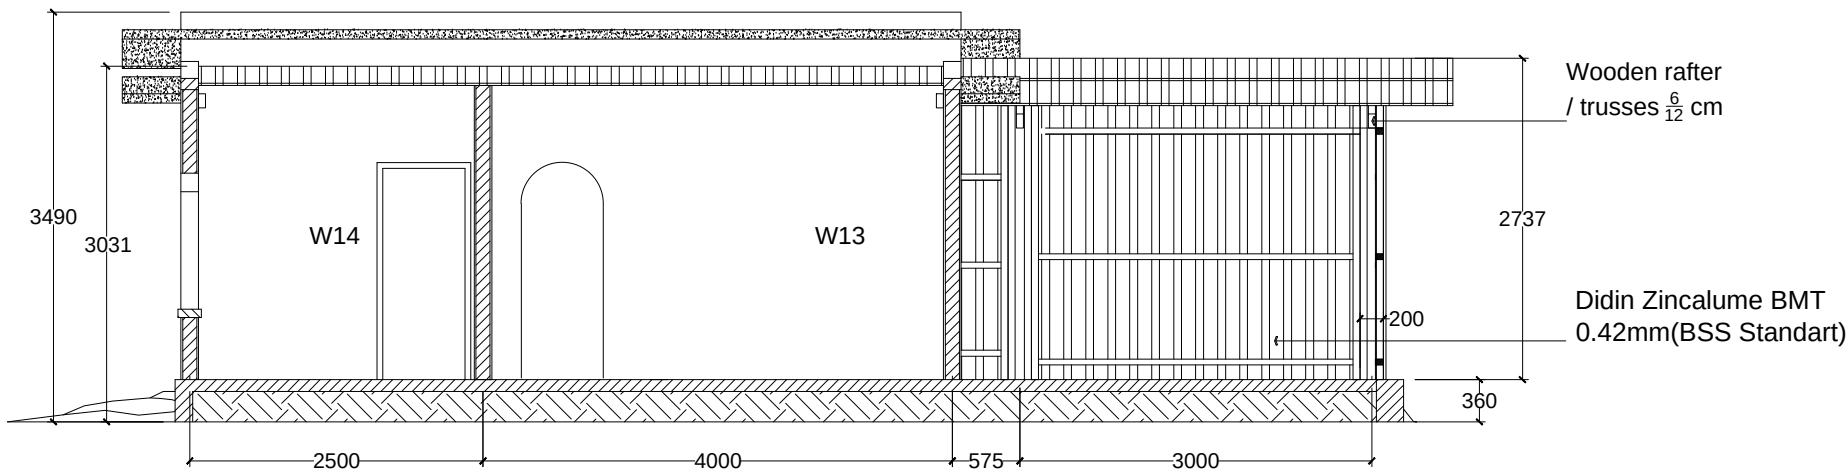


WALL PLASTERING
1:1500

CLIENT / PROJECT OWNER		PREPARED BY	PROJECT TITLE	DRAWING TITLE	CONSULTANT DESIGN: A3R CONSULTANT		PROJECT OWNER		DEMOCRATIC REPUBLIC OF TIMOR LESTE				SHEET NO:
 ARQUIVO & MUSEU RESISTÊNCIA TIMORENSE INSTITUTO PÚBLICO REPÚBLICA DEMOCRÁTICA DE TIMOR LESTE Avenida Cidade de Lisboa, Dili, Timor Leste Phone: +670 - 77305782	 ANGEL'AQUIRA Consultant, Unipessoal Lda. Architectural & Engineering Design, Supervision and Project Management Vila Verde, Dili, Timor - Leste, Phone: +670 - 7238140 E-mail: ino_neves@yahoo.com	REHABILITAÇÃO DE ABRIGOS DA RESISTÊNCIA ABRIGU LURBA LURBA, BOBONARO TIMOR LESTE LOCATION : BOBONARO	WALL PLASTERING SCALE : 1:1500	DRAWING BY:	APPROVED BY:	APPROVED BY:	 Sr. Hamar Antoninho Baptista Alves Director e Presidente AMRT DATE :	MINISTRY OF PUBLIC WORK, TRANSPORT AND COMMUNICATION GENERAL DIRECTORATE OF PUBLIC WORKS NATIONAL DIRECTORATE OF BUILDING				18 OF 44	
				Arch. Aquilino F. das Neves	Eng. Jesuino J.X. Neves	VERIFIED BY:		DATE	APPROVED BY:	DATE	DRAWING NO:		
												Eng. Octavio P. Marques, M.Eng. HEAD OF PROJECT DEPARTMENT	Arch. Rosa Amaral Vong Directress of DNE

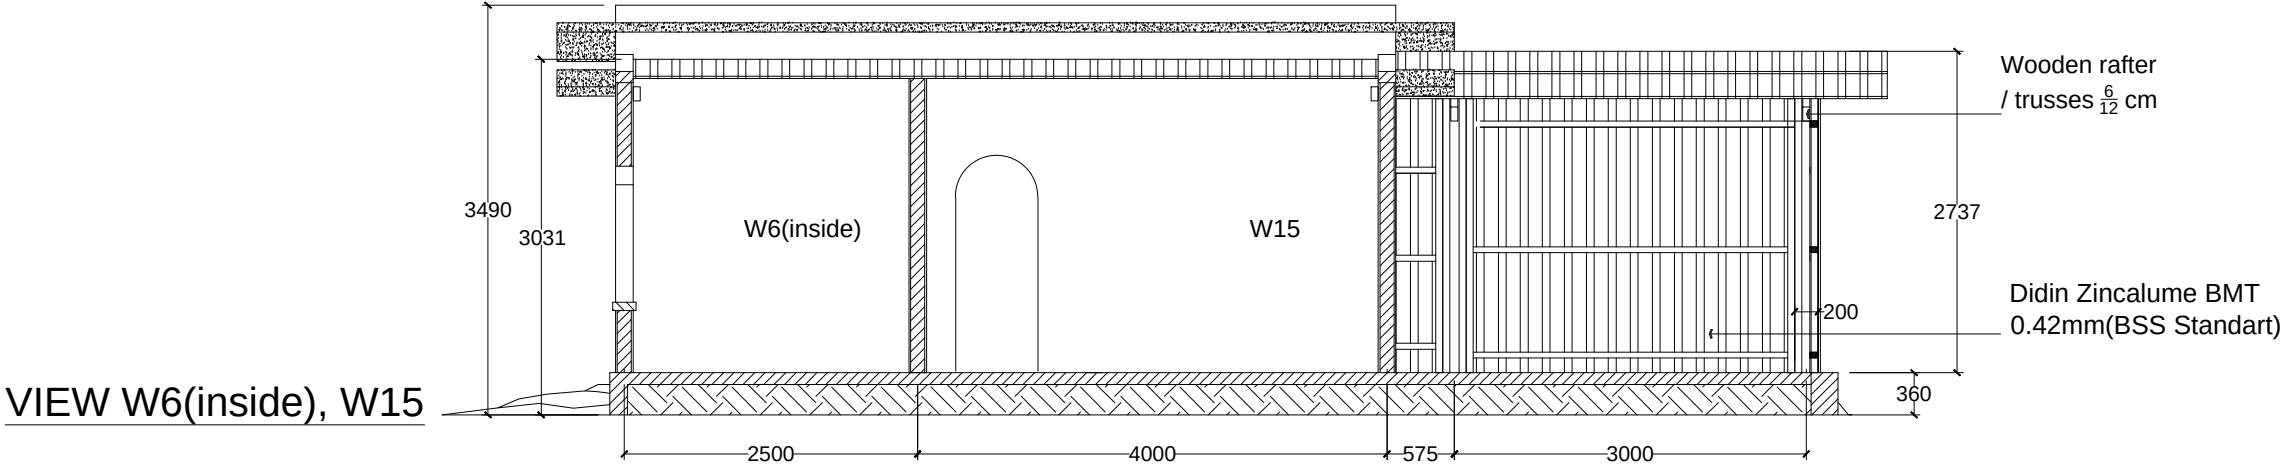


WALL PLASTERING
1:1500

CLIENT / PROJECT OWNER		PREPARED BY	PROJECT TITLE	DRAWING TITLE	CONSULTANT DESIGN: A3R CONSULTANT		PROJECT OWNER	DEMOCRATIC REPUBLIC OF TIMOR LESTE MINISTRY OF PUBLIC WORK, TRANSPORT AND COMMUNICATION GENERAL DIRECTORATE OF PUBLIC WORKS NATIONAL DIRECTORATE OF BUILDING				SHEET NO:	
 ARQUIVO & MUSEU RESISTÊNCIA TIMORENSE INSTITUTO PÚBLICO REPÚBLICA DEMOCRÁTICA DE TIMOR LESTE Avenida Cidade de Lisboa, Dili, Timor Leste Phone: +670 - 77305782		ANGEL'AQUIRA Consultant, Unipessoal Lda. Architectural & Engineering Design, Supervision and Project Management Vila Verde, Dili, Timor - Leste, Phone: +670 - 7238140 E-mail: ino_neves@yahoo.com	REHABILITAÇÃO DE ABRIGUS DA RESISTÊNCIA ABRIGU LURBA LURBA, BOBONARO TIMOR LESTE	WALL PLASTERING	DRAWING BY:	APPROVED BY:	APPROVED BY:	VERIFIED BY:		DATE	APPROVED BY:	DATE	19 OF 44
					Arch. Aquilino F. das Neves	Eng. Jesuino J.X. Neves	Sr. Hamar Antoninho Baptista Alves Director e Presidente AMRT	Eng. Octavio P. Marques, M.Eng. HEAD OF PROJECT DEPARTMENT	Arch. Rosa Amaral Vong Directress of DNE			DRAWING NO: ARCH 19 OF 44	
			LOCATION :	BOBONARO	SCALE :	1:1500	DATE :	DATE :	DATE :				

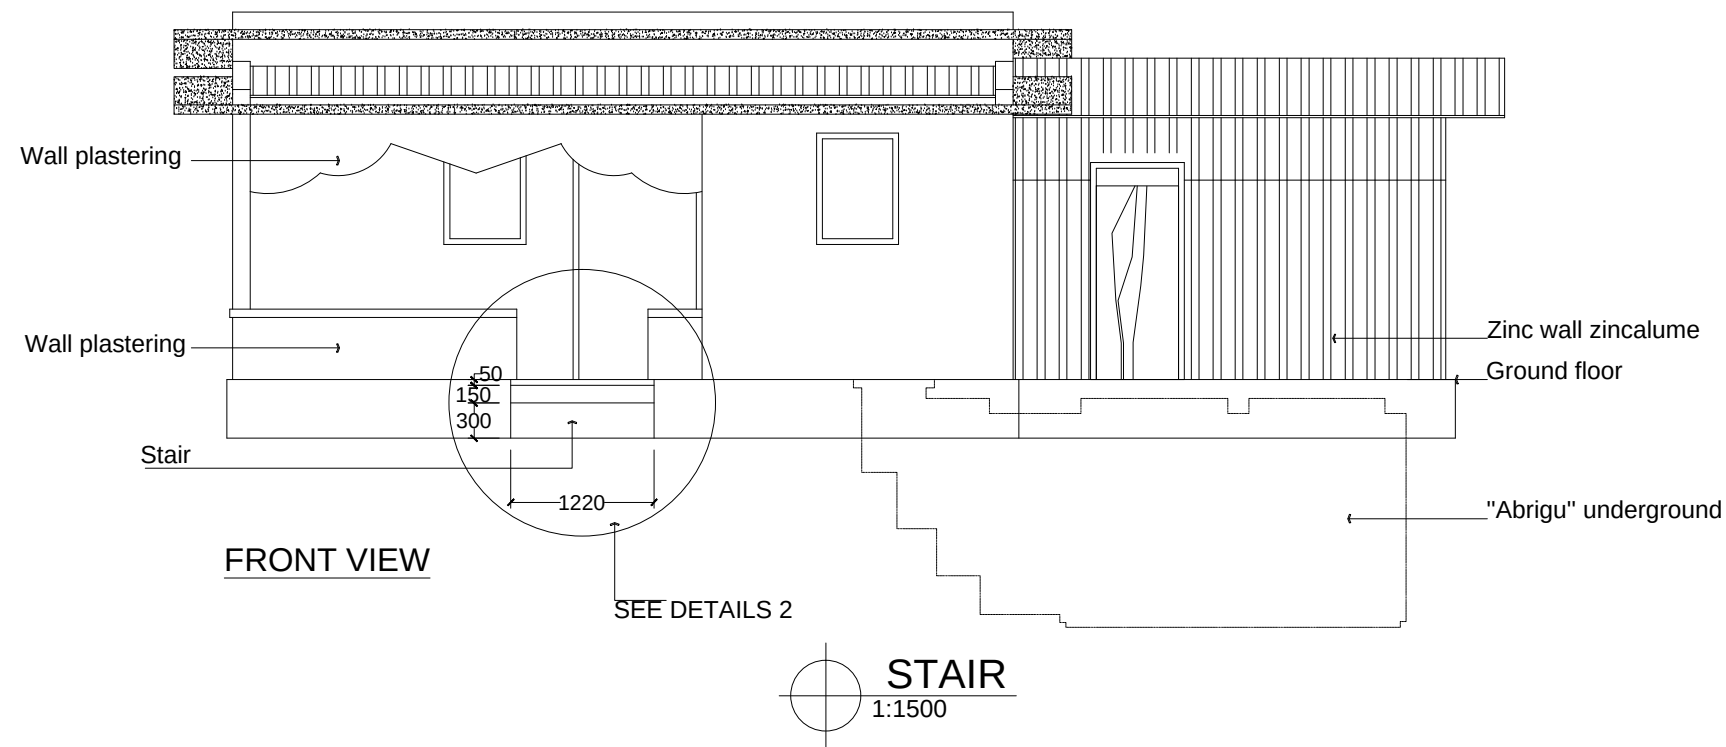



REHABILITATION ITEM FOR "ABRIGU" LOURBA BOBONARO TIMOR LESTE	
NO	ITEM
1.	Remove and replace stair

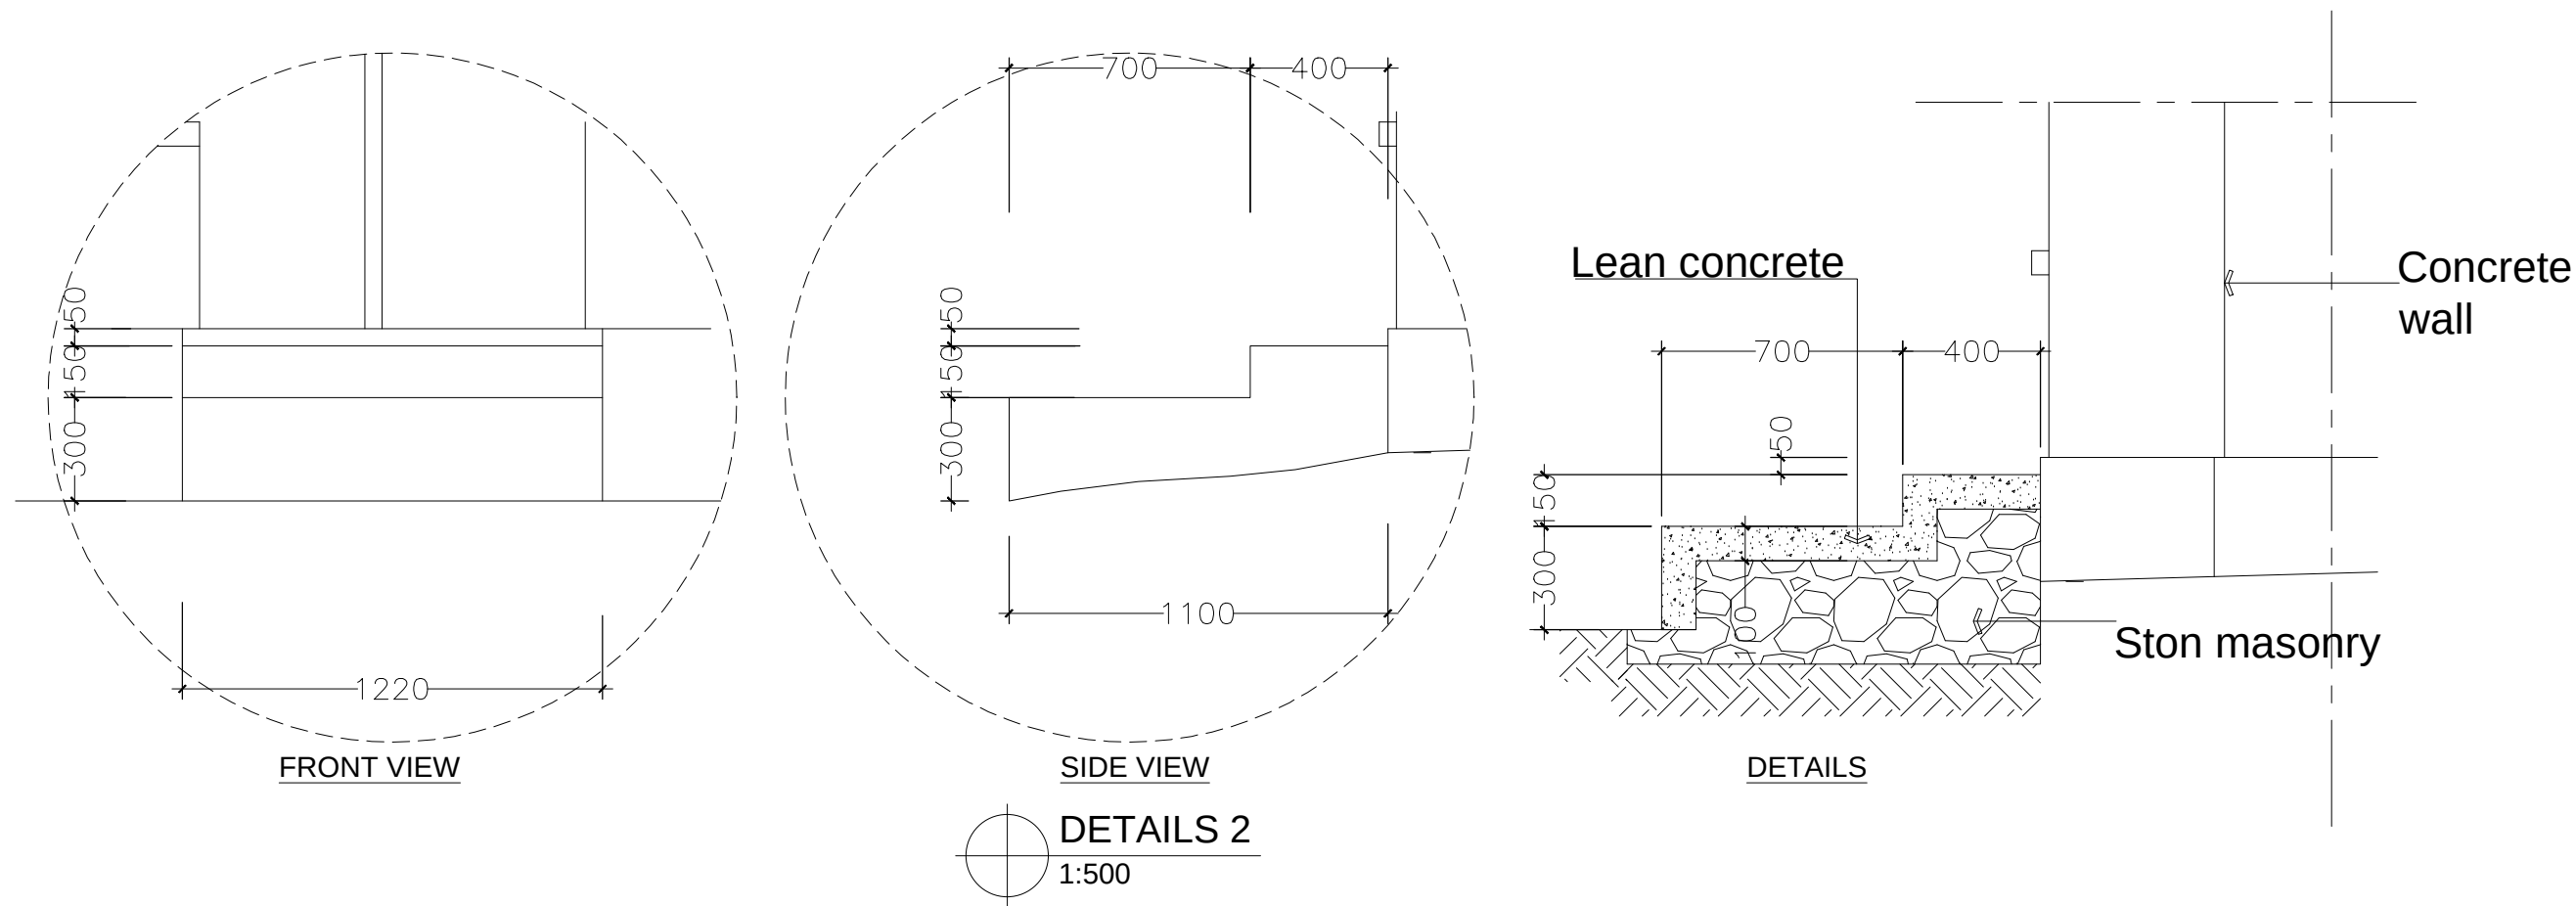


CLIENT / PROJECT OWNER	PREPARED BY	PROJECT TITLE	DRAWING TITLE	CONSULTANT DESIGN: A3R CONSULTANT		PROJECT OWNER	DEMOCRATIC REPUBLIC OF TIMOR LESTE MINISTRY OF PUBLIC WORK, TRANSPORT AND COMMUNICATION GENERAL DIRECTORATE OF PUBLIC WORKS NATIONAL DIRECTORATE OF BUILDING				SHEET NO:
ARQUIVO & MUSEU RESISTÊNCIA TIMORENSE INSTITUTO PÚBLICO REPÚBLICA DEMOCRÁTICA DE TIMOR LESTE Avenida Cidade de Lisboa, Dili, Timor Leste Phone: +670 - 77305782	ANGEL'AQUIRA Consultant, Unipessoal Lda. Architectural & Engineering Design, Supervision and Project Management Vila Verde, Dili, Timor - Leste, Phone: +670 - 7238140 E-mail: ino_neves@yahoo.com	REHABILITAÇÃO DE ABRIGUS DA RESISTÊNCIA	STAIR AND DETAILS	DRAWING BY:		APPROVED BY:					20 OF 44
		ABRIGU LURBA									
		LURBA, BOBONARO TIMOR LESTE	Arch. Aquilino F. das Neves	Eng. Jesuino J.X. Neves	Sr. Hamar Antoninho Baptista Alves Director e Presidente AMRT		Eng. Octavio P. Marques, M.Eng. HEAD OF PROJECT DEPARTMENT		Arch. Rosa Amaral Vong Directress of DNE		DRAWING NO: ARCH 20 OF 44
		LOCATION : BOBONARO	SCALE : 1:1500	DATE :	DATE :	DATE :					

REHABILITATION ITEM FOR "ABRIGU" LOURBA BOBONARO
TIMOR LESTE

NO	ITEM
1.	Remove and replace "abrigu" floor

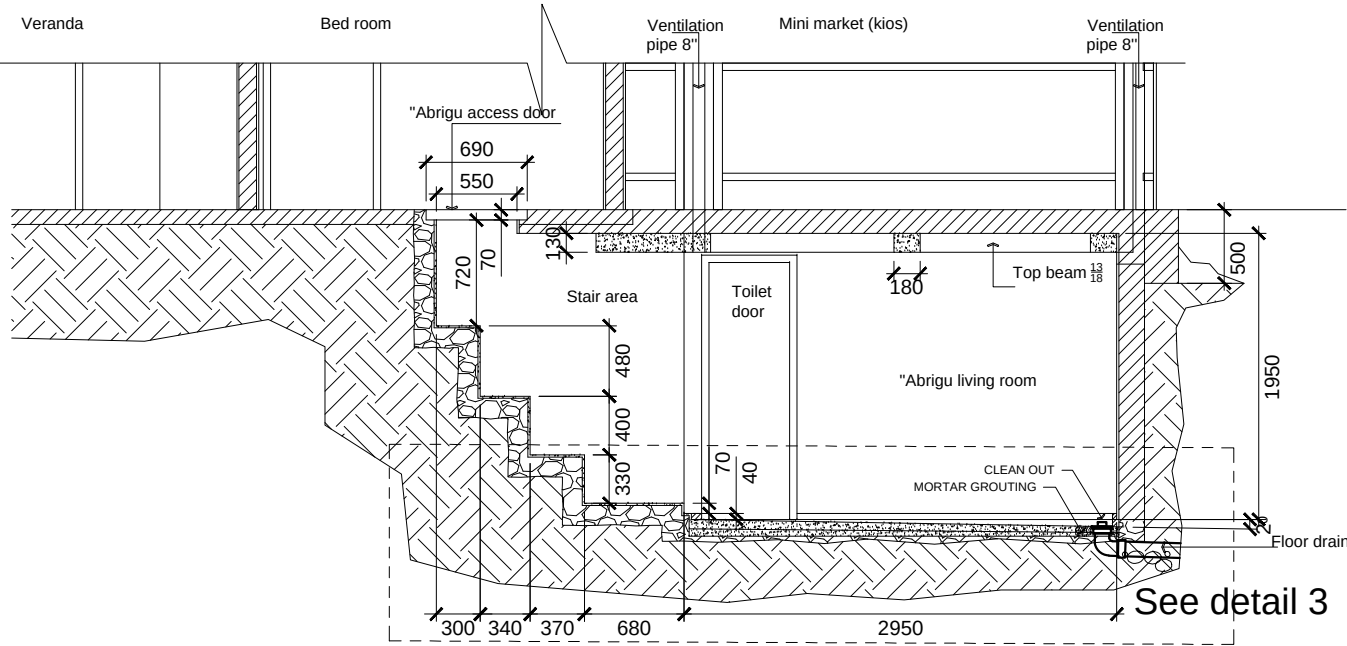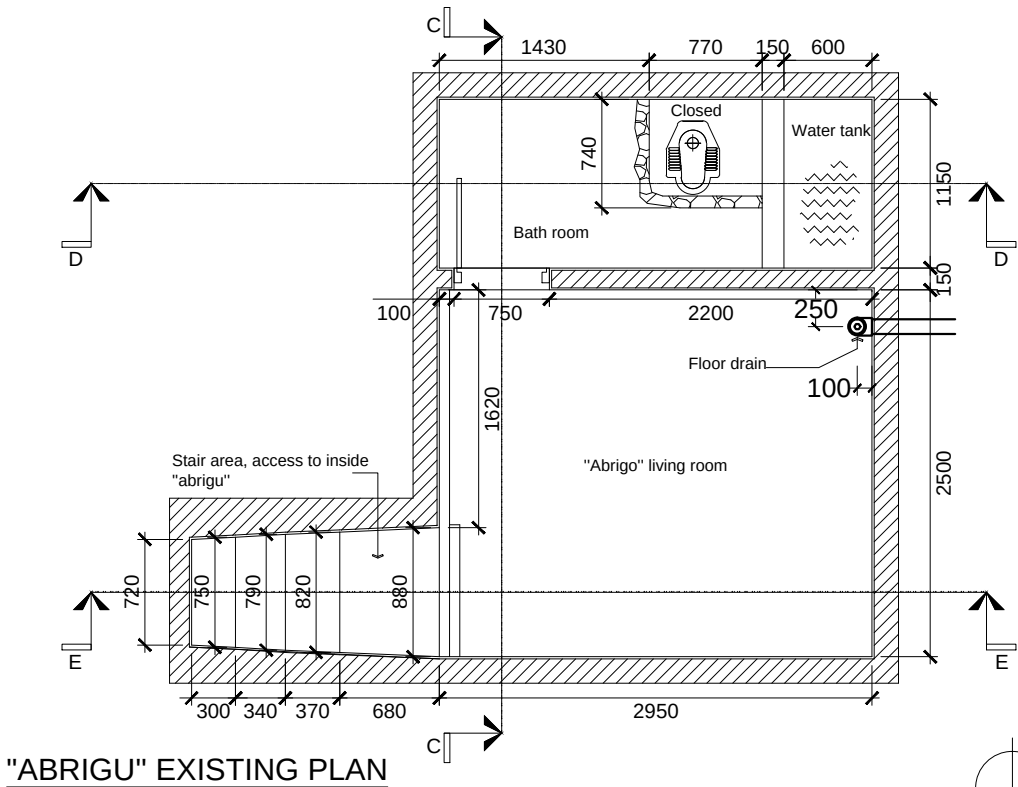


LEAN CONCRETE "ABRIGU" FLOOR
1:1000

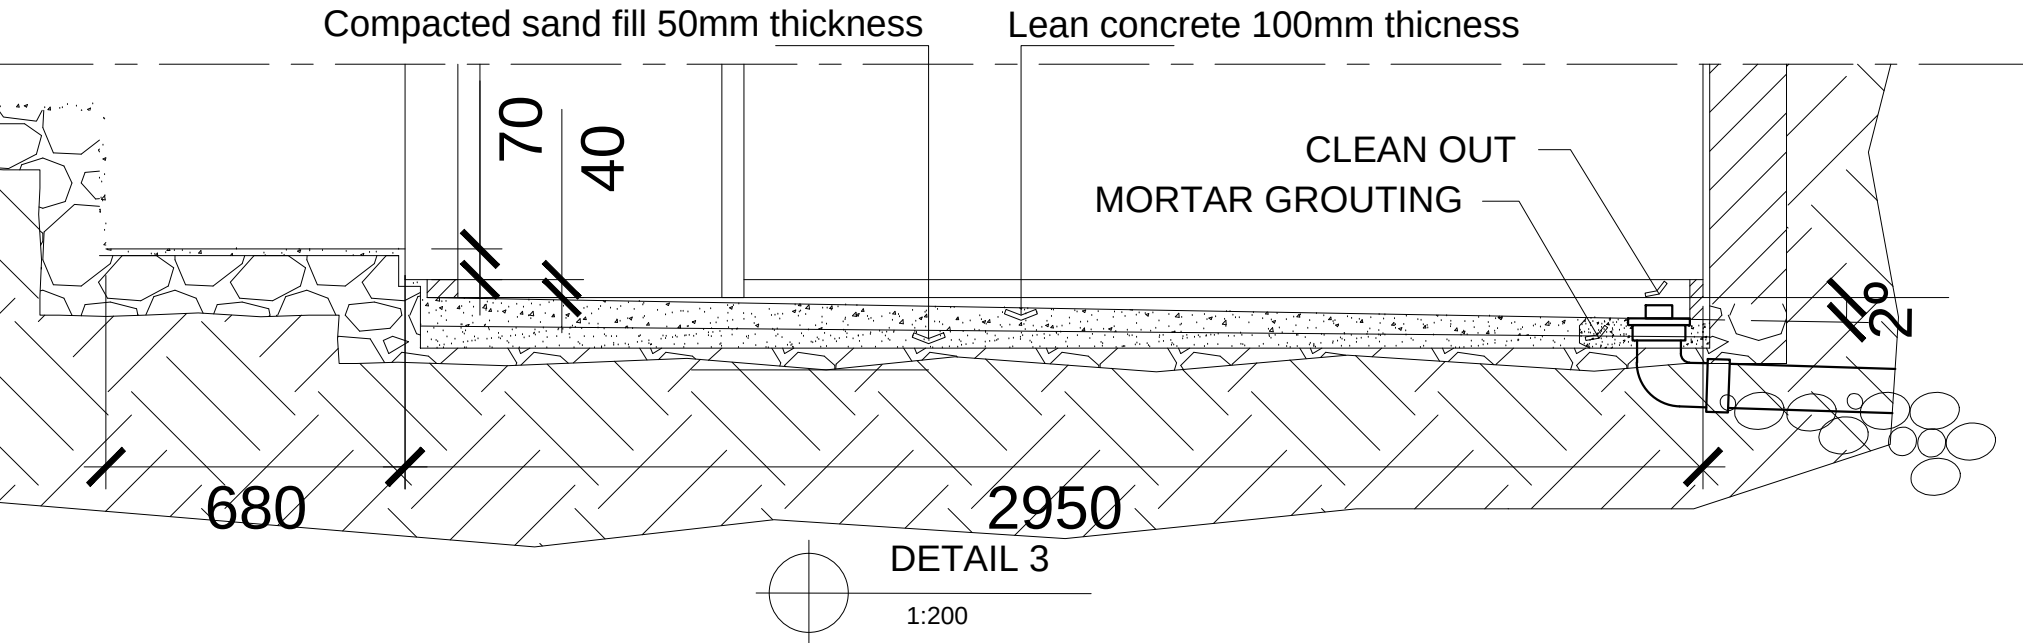


CLIENT / PROJECT OWNER  ARQUIVO & MUSEU RESISTÊNCIA TIMORENSE INSTITUTO PÚBLICO REPÚBLICA DEMOCRÁTICA DE TIMOR LESTE Avenida Cidade de Lisboa, Dili, Timor Leste Phone: +670 - 77305782	PREPARED BY  ANGEL'AQUIRA Consultant, Unipessoal Lda. Architectural & Engineering Design, Supervision and Project Management Vila Verde, Dili, Timor - Leste, Phone: +670 - 7238140 E-mail: ino_neves@yahoo.com	PROJECT TITLE REHABILITAÇÃO DE ABRIGUS DA RESISTÊNCIA ABRIGU LURBA LURBA, BOBONARO TIMOR LESTE LOCATION : BOBONARO	DRAWING TITLE LEAN CONCRETE "ABRIGU" FLOOR SCALE : 1:1000	CONSULTANT DESIGN: A3R CONSULTANT		PROJECT OWNER APPROVED BY: Sr. Hamar Antoninho Baptista Alves Director e Presidente AMRT DATE :	DEMOCRATIC REPUBLIC OF TIMOR LESTE MINISTRY OF PUBLIC WORK, TRANSPORT AND COMMUNICATION GENERAL DIRECTORATE OF PUBLIC WORKS NATIONAL DIRECTORATE OF BUILDING				SHEET NO: 21 OF 44 DRAWING NO: ARCH 21 OF 44
				DRAWING BY:	APPROVED BY:		VERIFIED BY:	DATE	APPROVED BY:	DATE	
				Arch. Aquilino F. das Neves	Eng. Jesuino J.X. Neves		Eng. Octavio P. Marques, M.Eng. HEAD OF PROJECT DEPARTMENT		Arch. Rosa Amaral Vong Directress of DNE		

REHABILITATION ITEM FOR "ABRIGU" LURBA BOBONARO
TIMOR LESTE

NO	ITEM
1.	New barrier concrete wall (underground)

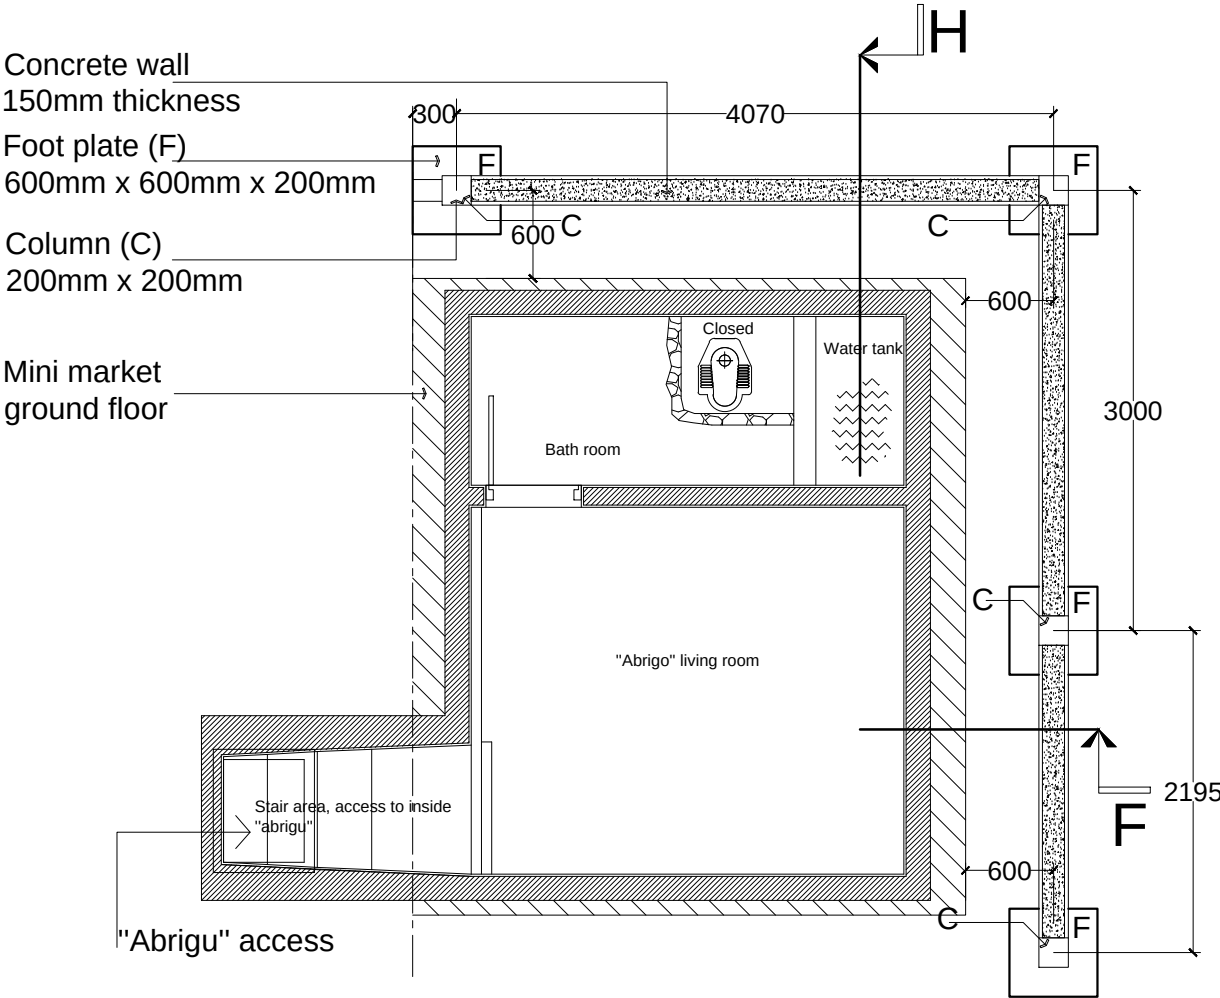


"ABRIGU" RETAINING WALL PLAN
1:1000

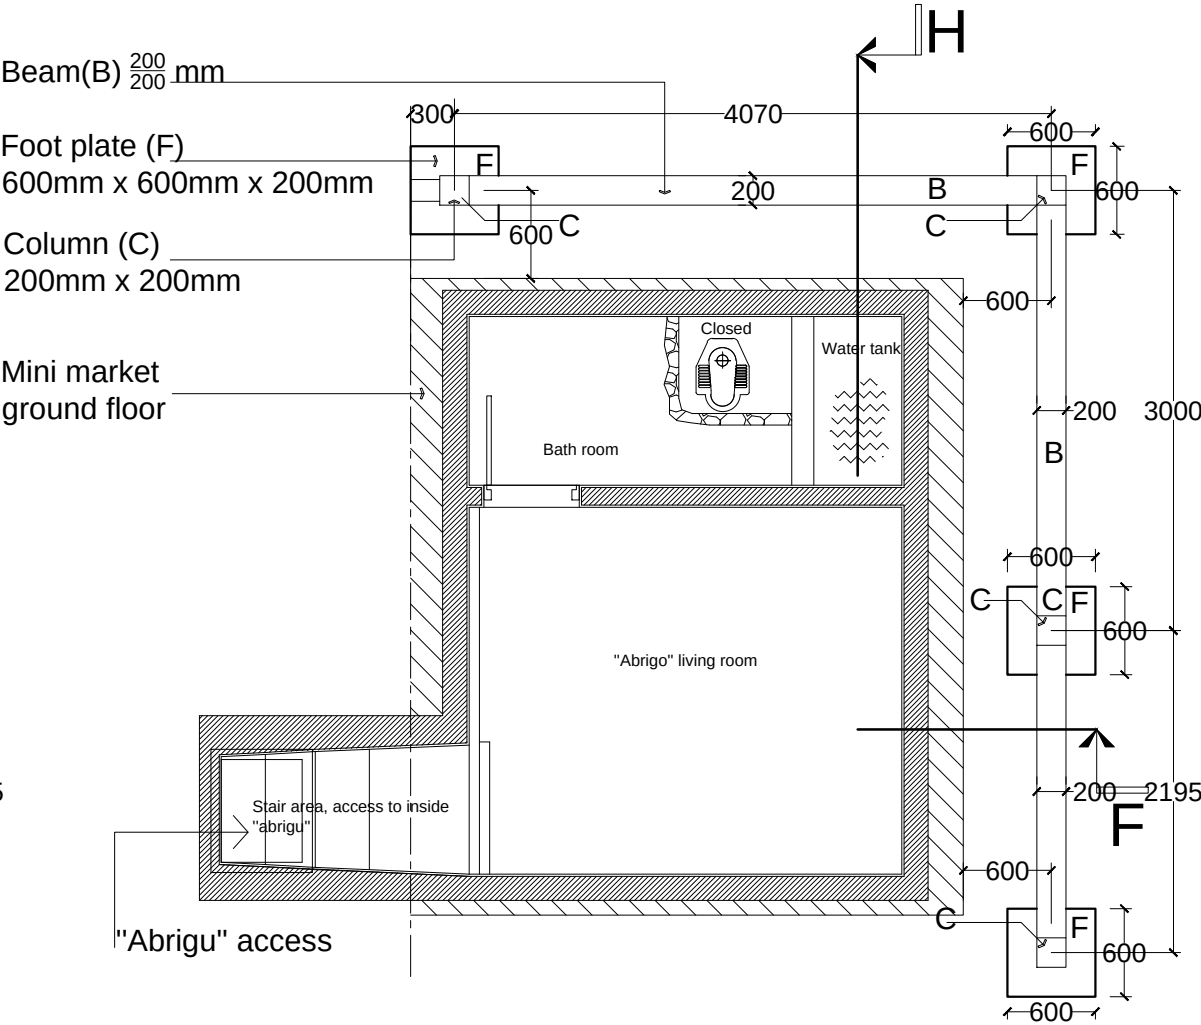

FOOT PLATE, COLUMN, BEAM PLAN
1:1000

CLIENT / PROJECT OWNER		PREPARED BY	PROJECT TITLE	DRAWING TITLE	CONSULTANT DESIGN: A3R CONSULTANT		PROJECT OWNER	DEMOCRATIC REPUBLIC OF TIMOR LESTE MINISTRY OF PUBLIC WORK, TRANSPORT AND COMMUNICATION GENERAL DIRECTORATE OF PUBLIC WORKS NATIONAL DIRECTORATE OF BUILDING	SHEET NO: 22 OF 44
 ARQUIVO & MUSEU RESISTÊNCIA TIMORENSE INSTITUTO PÚBLICO REPÚBLICA DEMOCRÁTICA DE TIMOR LESTE Avenida Cidade de Lisboa, Dili, Timor Leste Phone: +670 - 77305782		ANGEL'AQUIRA Consultant, Unipessoal Lda. Architectural & Engineering Design, Supervision and Project Management Vila Verde, Dili, Timor - Leste, Phone: +670 - 7238140 E-mail: ino_neves@yahoo.com	REHABILITAÇÃO DE ABRIGOS DA RESISTÊNCIA ABRIGU LURBA LURBA, BOBONARO TIMOR LESTE LOCATION : BOBONARO	RETAINING WALL AND STRUCTURE PLAN SCALE : 1:1000	DRAWING BY:	APPROVED BY:	APPROVED BY:		
					Arch. Aquilino F. das Neves	Eng. Jesuino J.X. Neves	Sr. Hamar Antoninho Baptista Alves Director e Presidente AMRT		
					DATE :	DATE :	DATE :	VERIFIED BY: DATE APPROVED BY: DATE	DRAWING NO: ARCH 22 OF 44
								Eng. Octavio P. Marques, M.Eng. HEAD OF PROJECT DEPARTMENT	Arch. Rosa Amaral Vong Directress of DNE

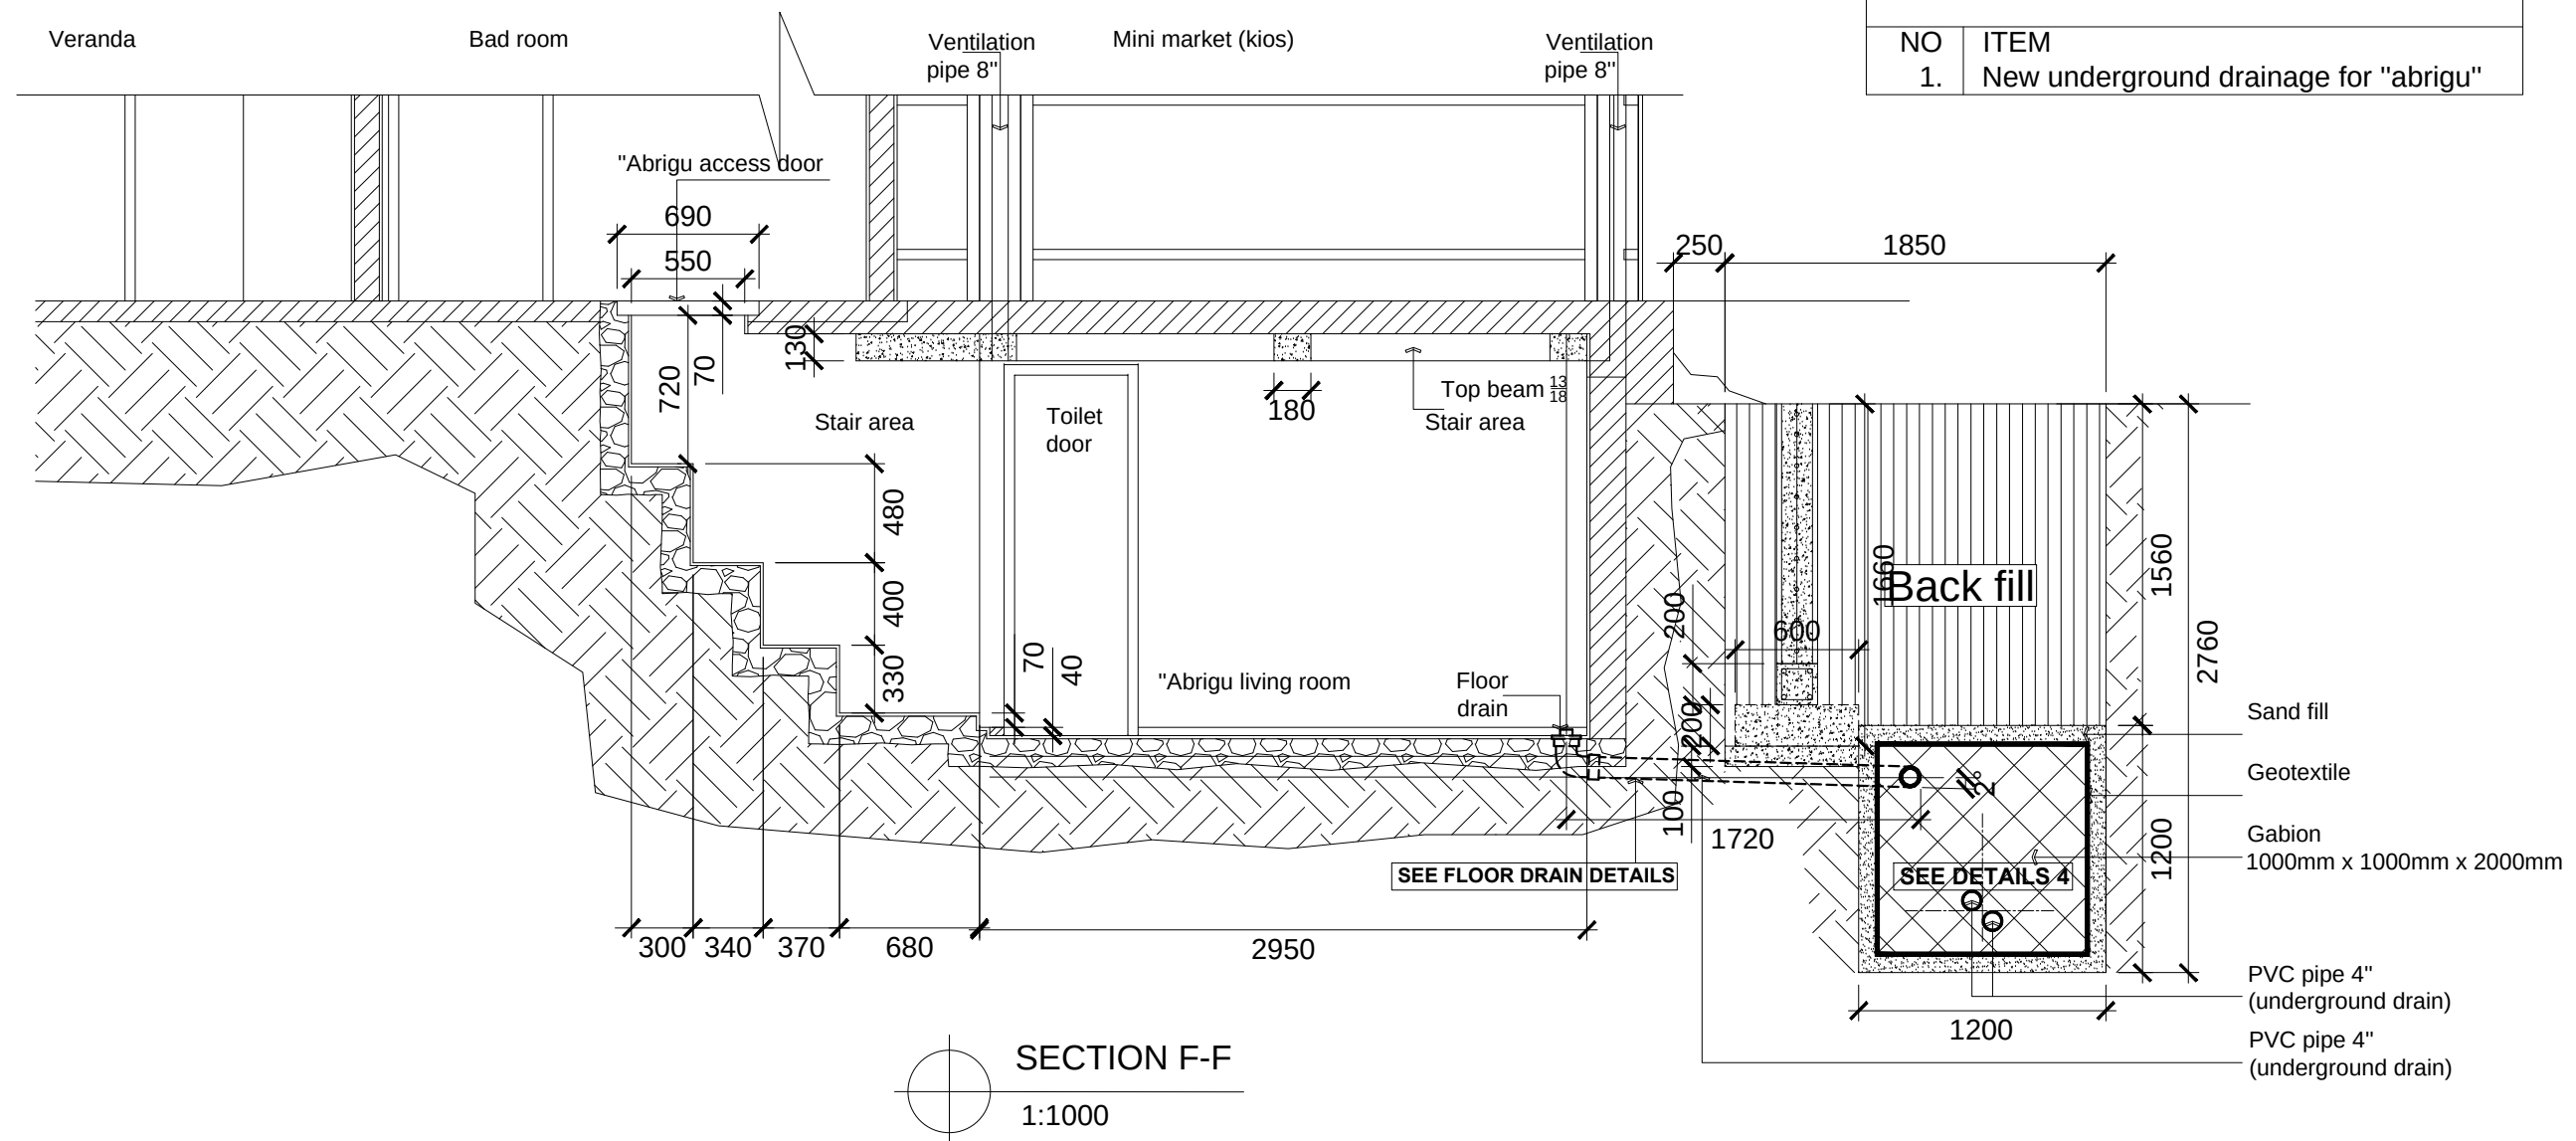


REHABILITATION ITEM FOR "ABRIGU" LOURBA BOBONARO TIMOR LESTE	
NO	ITEM
1.	New underground drainage for "abrigu"

CLIENT / PROJECT OWNER		PREPARED BY	PROJECT TITLE	DRAWING TITLE	CONSULTANT DESIGN: A3R CONSULTANT		PROJECT OWNER	DEMOCRATIC REPUBLIC OF TIMOR LESTE				SHEET NO:
ARQUIVO & MUSEU RESISTÊNCIA TIMORENSE INSTITUTO PÚBLICO REPÚBLICA DEMOCRÁTICA DE TIMOR LESTE Avenida Cidade de Lisboa, Dili, Timor Leste Phone: +670 - 77305782		 ANGEL'AQUIRA Consultant, Unipessoal Lda. Architectural & Engineering Design, Supervision and Project Management Vila Verde, Dili, Timor - Leste, Phone: +670 - 7238140 E-mail: ino_neves@yahoo.com	REHABILITAÇÃO DE ABRIGUS DA RESISTÊNCIA ABRIGU LURBA LURBA, BOBONARO TIMOR LESTE LOCATION : BOBONARO	DRAINAGE SECTION SCALE : 1:1000	DRAWING BY:	APPROVED BY:	APPROVED BY:	 MINISTRY OF PUBLIC WORK, TRANSPORT AND COMMUNICATION GENERAL DIRECTORATE OF PUBLIC WORKS NATIONAL DIRECTORATE OF BUILDING				24 OF 44
					Arch. Aquilino F. das Neves	Eng. Jesuino J.X. Neves	Sr. Hamar Antoninho Baptista Alves Director e Presidente AMRT					
					DATE :	DATE :	DATE :	VERIFIED BY:	DATE	APPROVED BY:	DATE	DRAWING NO:
								Eng. Octavio P. Marques, M.Eng. HEAD OF PROJECT DEPARTMENT		Arch. Rosa Amaral Vong Directress of DNE		ARCH 24 OF 44

REHABILITATION ITEM FOR
"ABRIGU" LOURBA BOBONARO
TIMOR LESTE


NO	ITEM
1.	New underground drainage for "abrigu"

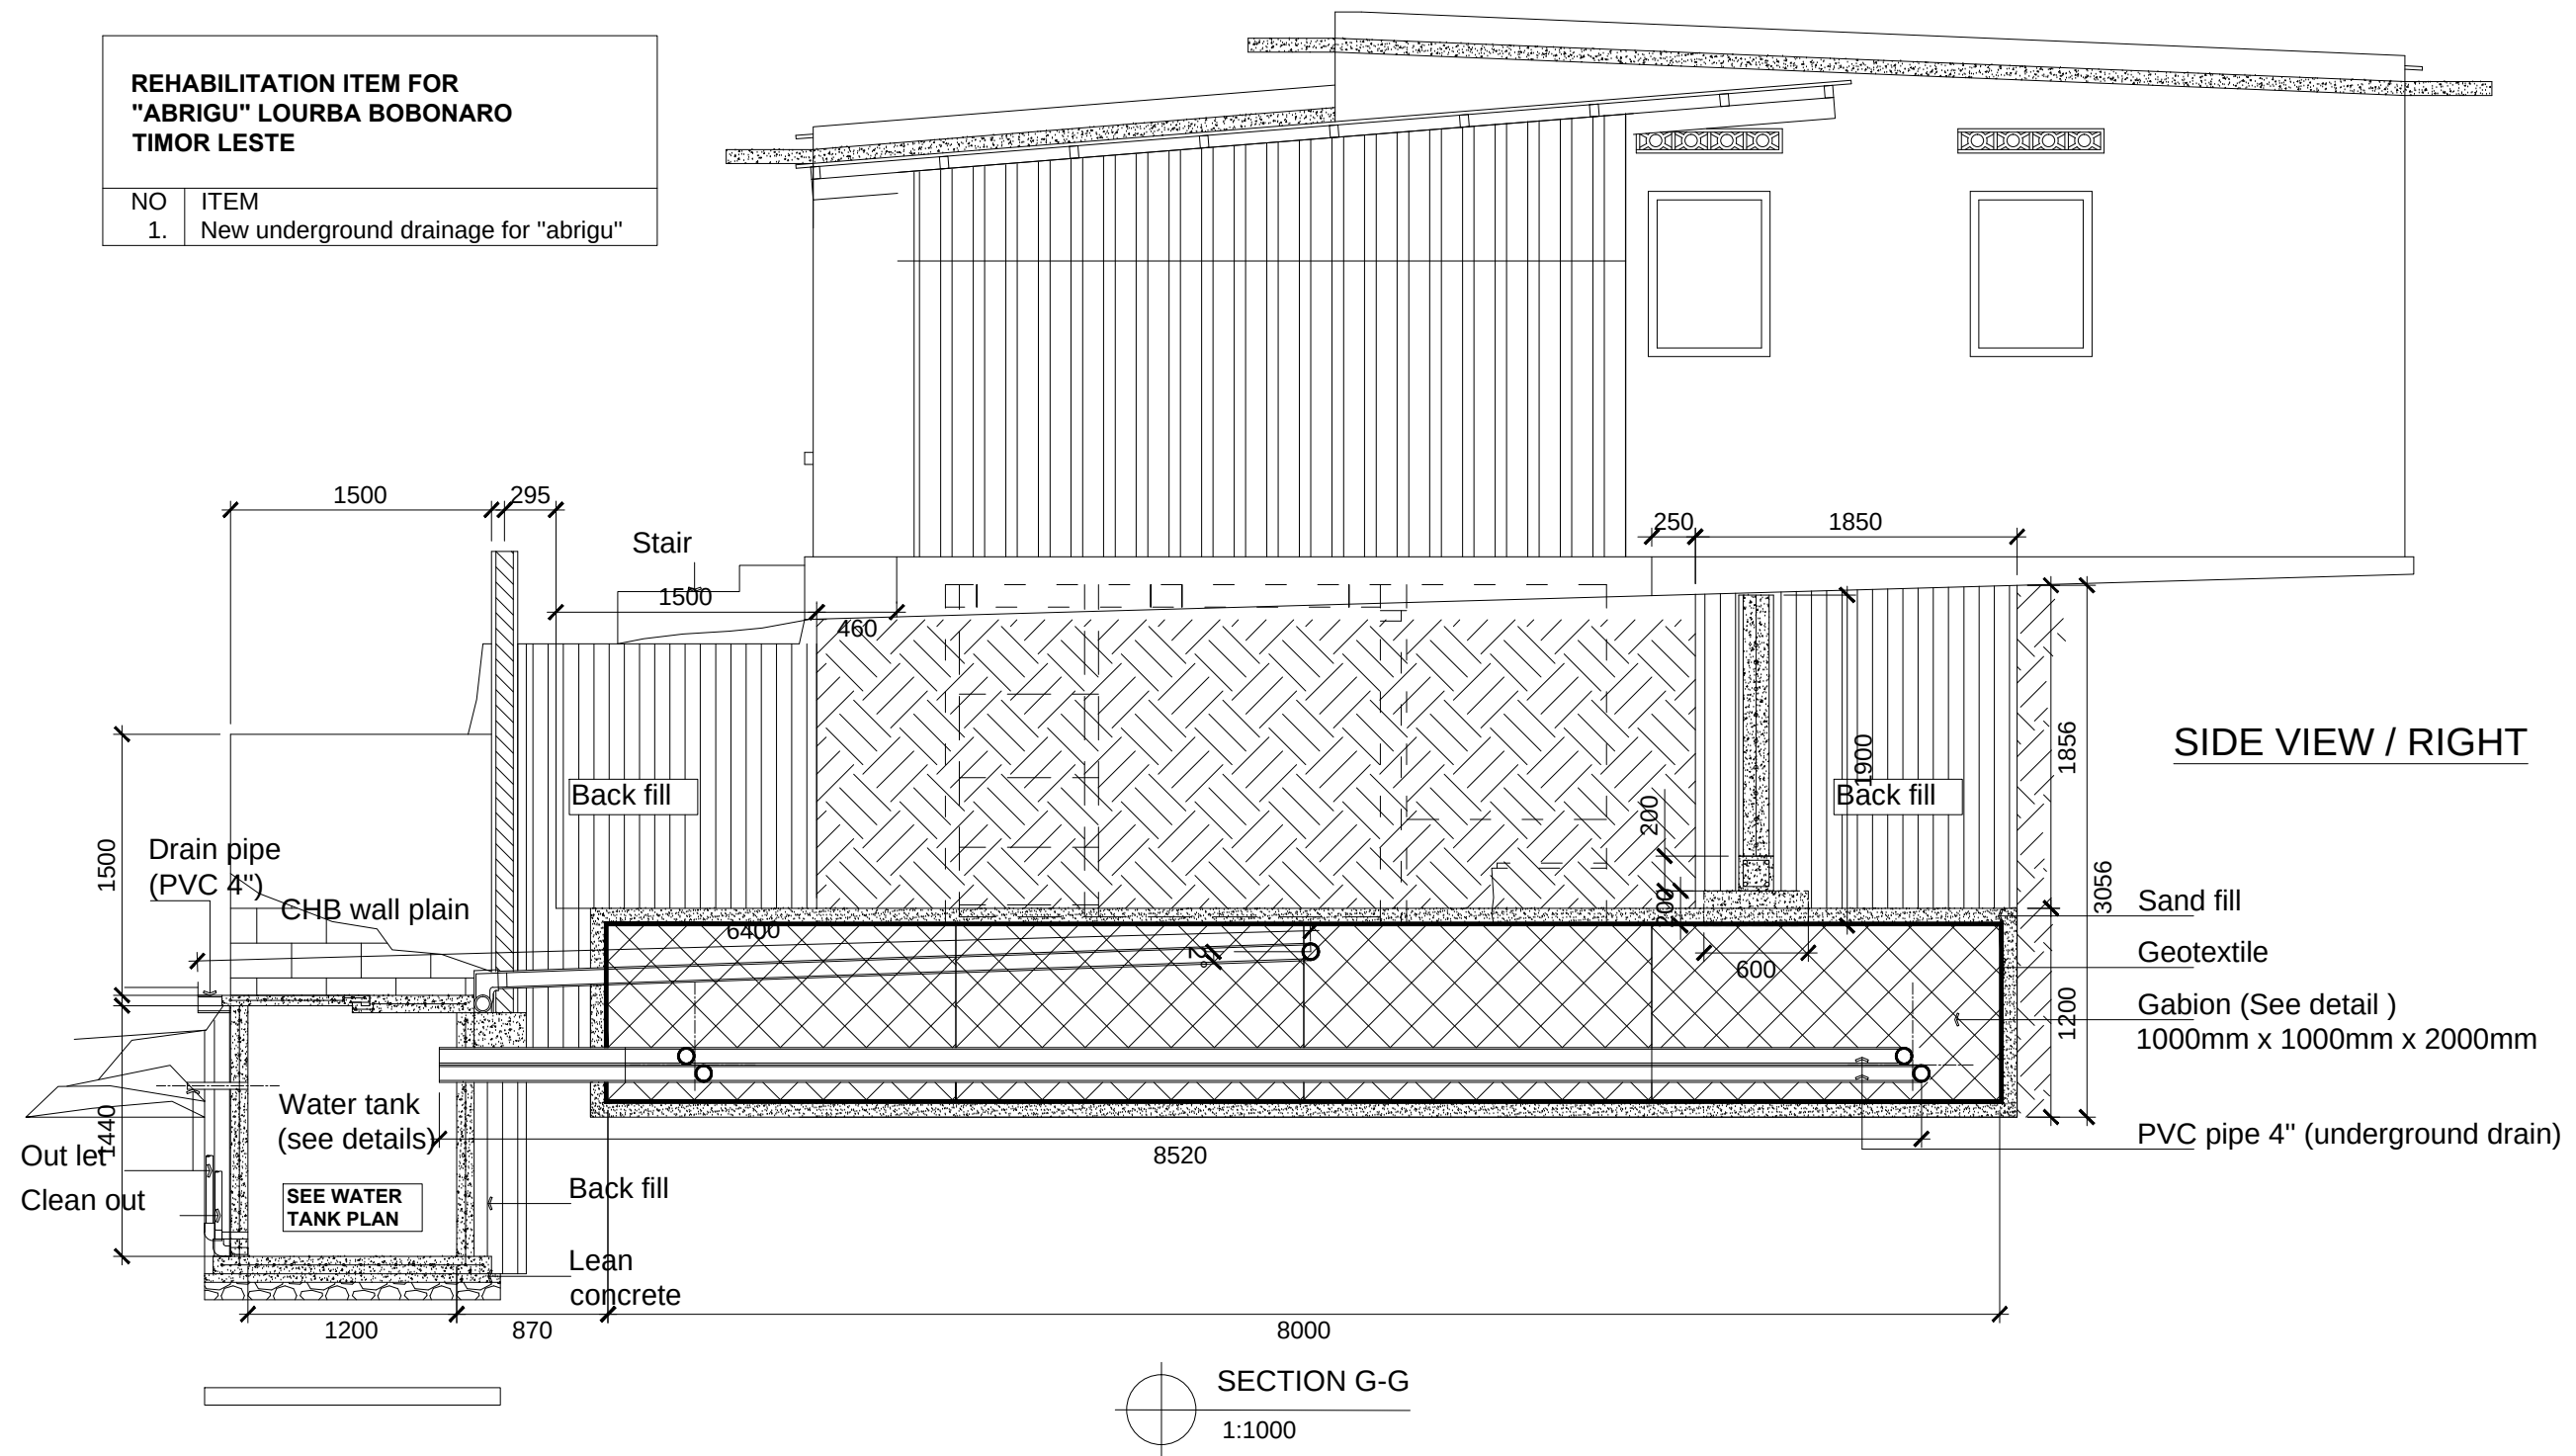



CLIENT / PROJECT OWNER		PREPARED BY	PROJECT TITLE	DRAWING TITLE	CONSULTANT DESIGN: A3R CONSULTANT		PROJECT OWNER	DEMOCRATIC REPUBLIC OF TIMOR LESTE				SHEET NO:
 ARQUIVO & MUSEU RESISTÊNCIA TIMORENSE INSTITUTO PÚBLICO REPÚBLICA DEMOCRÁTICA DE TIMOR LESTE Avenida Cidade de Lisboa, Dili, Timor Leste Phone: +670 - 77305782		 ANGEL/AQUIRA Consultant, Unipessoal Lda. Architectural & Engineering Design, Supervision and Project Management Vila Verde, Dili, Timor - Leste, Phone: +670 - 7238140 E-mail: ino_neves@yahoo.com	REHABILITAÇÃO DE ABRIGUS DA RESISTÊNCIA ABRIGU LURBA LURBA, BOBONARO TIMOR LESTE LOCATION : BOBONARO	DRAINAGE SECTION SCALE : 1:1000	DRAWING BY:	APPROVED BY:	APPROVED BY:	 MINISTRY OF PUBLIC WORK, TRANSPORT AND COMMUNICATION GENERAL DIRECTORATE OF PUBLIC WORKS NATIONAL DIRECTORATE OF BUILDING				25 OF 44
					Arch. Aquilino F. das Neves	Eng. Jesuino J.X. Neves	Sr. Hamar Antoninho Baptista Alves Director e Presidente AMRT					
					DATE :	DATE :	DATE :	VERIFIED BY:	DATE	APPROVED BY:	DATE	DRAWING NO:
								Eng. Octavio P. Marques, M.Eng. HEAD OF PROJECT DEPARTMENT		Arch. Rosa Amaral Vong Directress of DNE		ARCH 25 OF 44

REHABILITATION ITEM FOR
"ABRIGU" LOURBA BOBONARO
TIMOR LESTE


NO	ITEM
1.	New underground drainage for "abrigu"

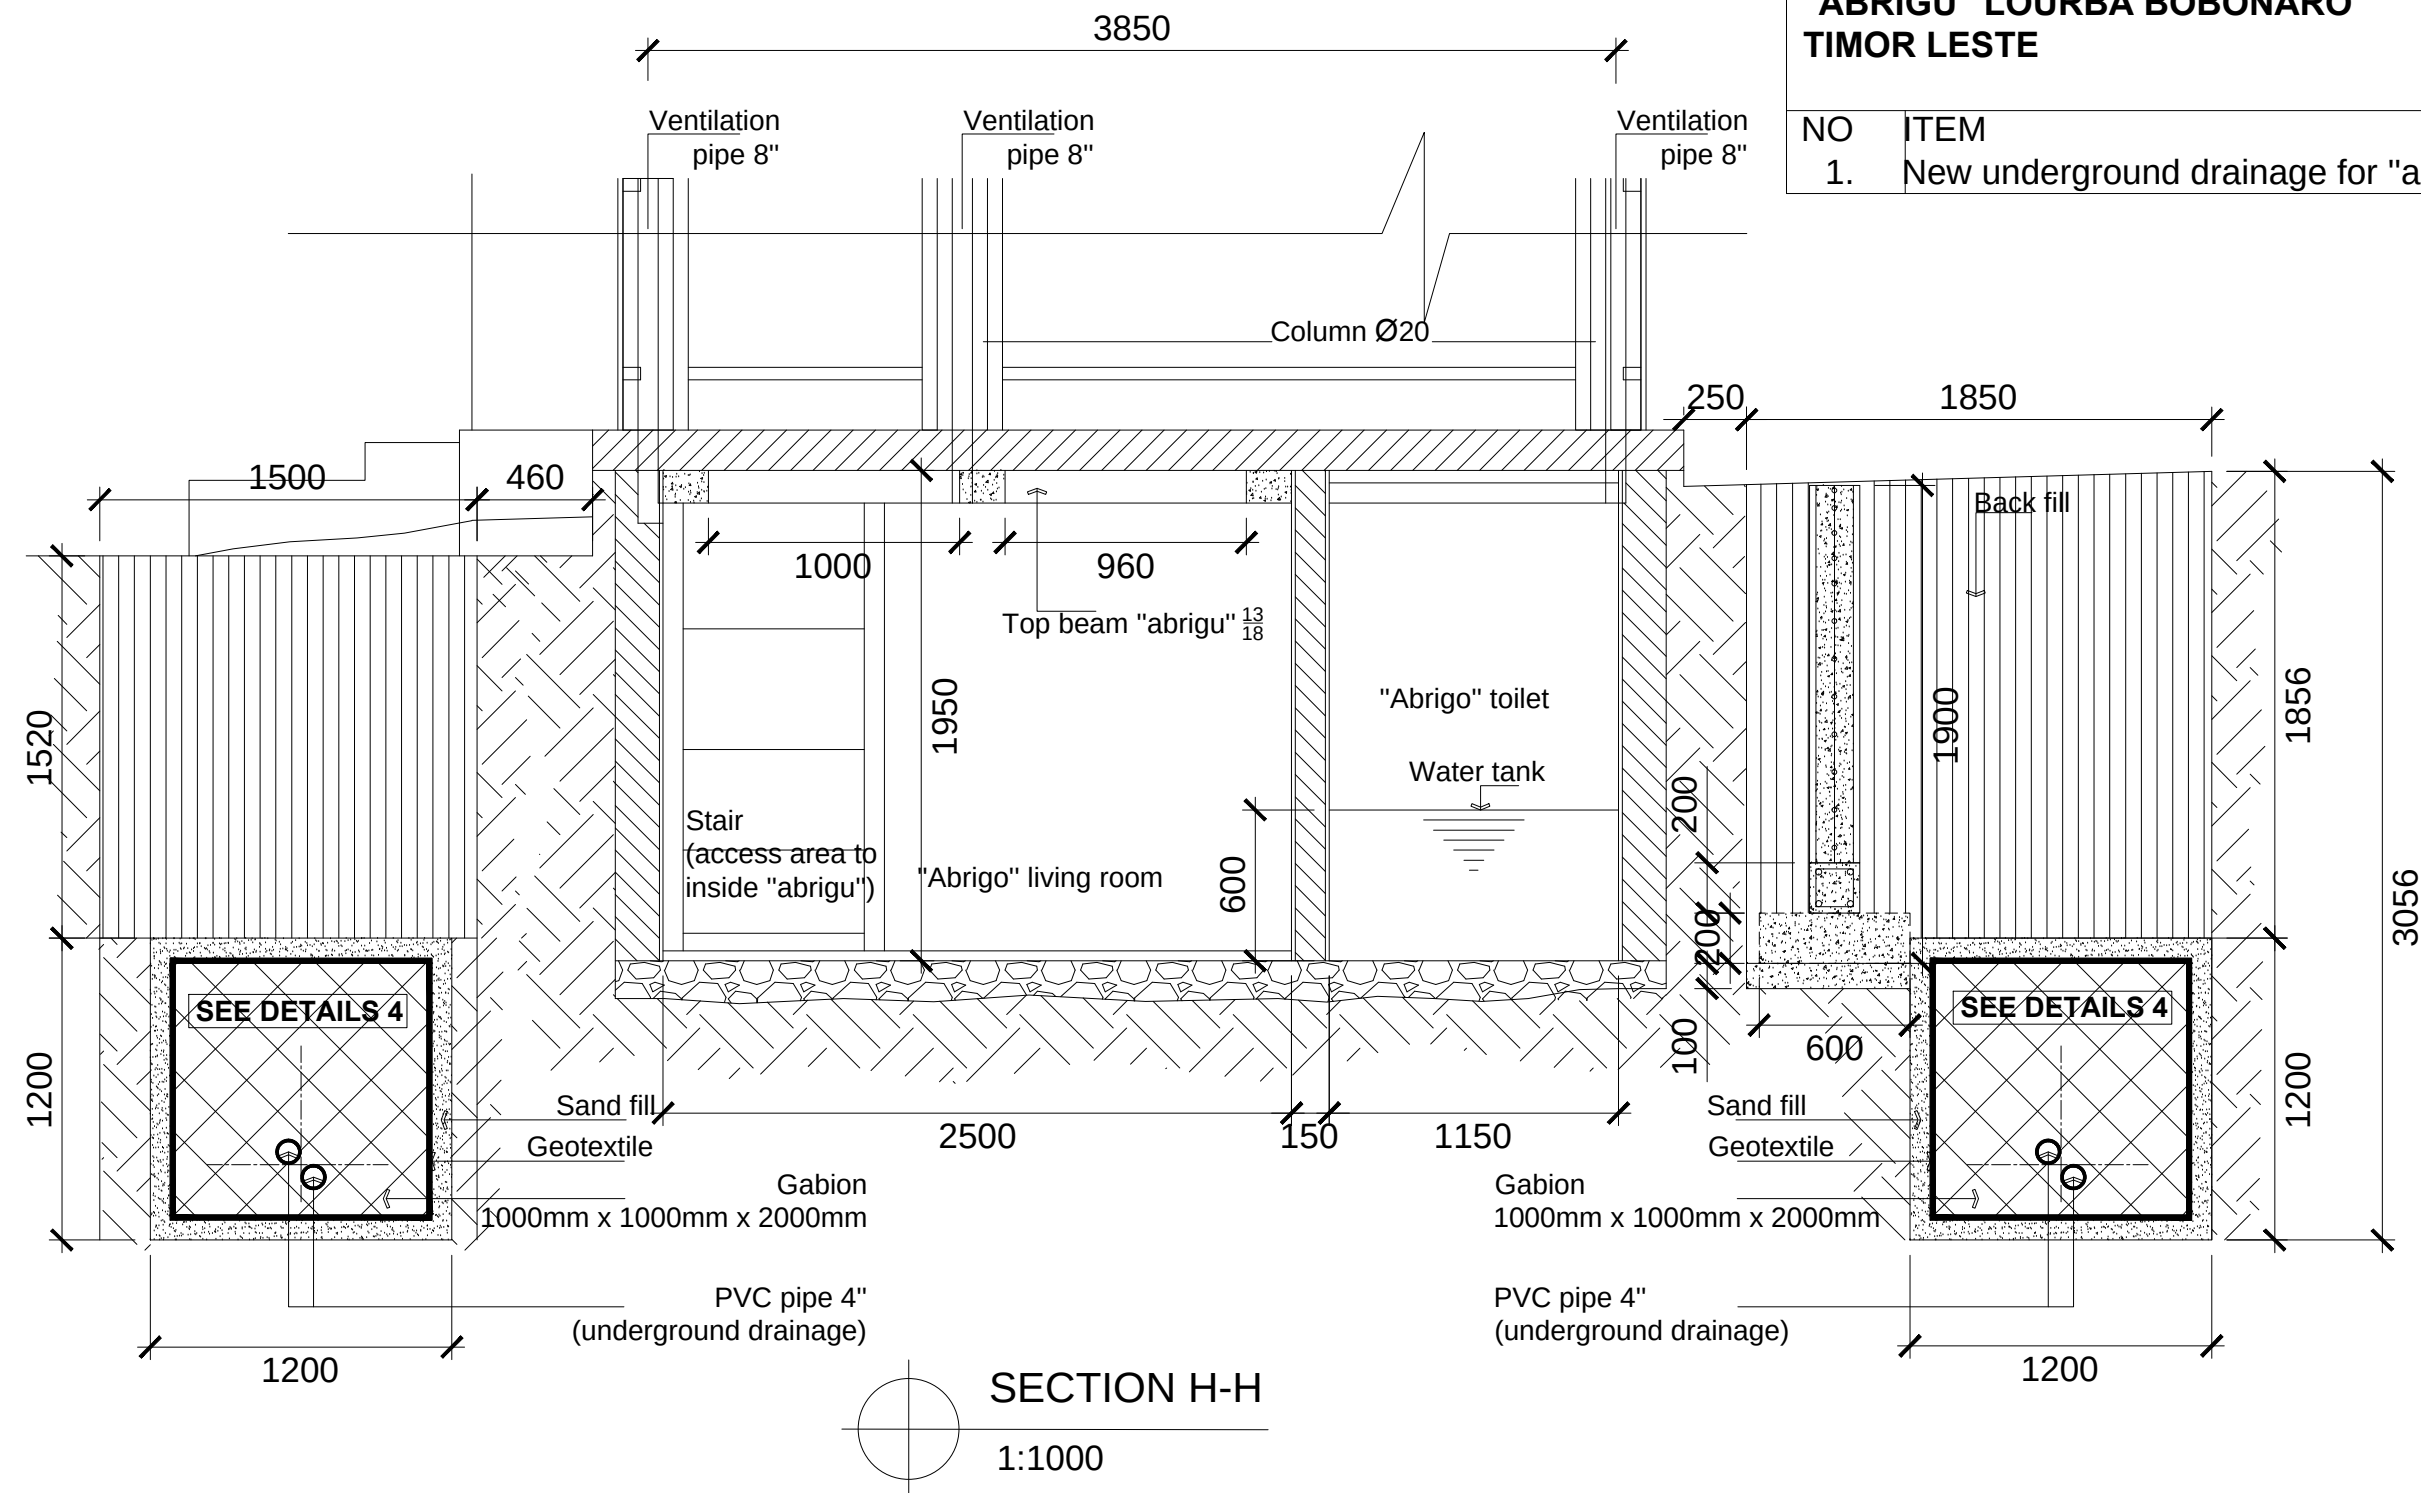


CLIENT / PROJECT OWNER	PREPARED BY	PROJECT TITLE	DRAWING TITLE	CONSULTANT DESIGN: A3R CONSULTANT		PROJECT OWNER	DEMOCRATIC REPUBLIC OF TIMOR LESTE MINISTRY OF PUBLIC WORK, TRANSPORT AND COMMUNICATION GENERAL DIRECTORATE OF PUBLIC WORKS NATIONAL DIRECTORATE OF BUILDING				SHEET NO:
ARQUIVO & MUSEU RESISTÊNCIA TIMORENSE INSTITUTO PÚBLICO REPÚBLICA DEMOCRÁTICA DE TIMOR LESTE Avenida Cidade de Lisboa, Dili, Timor Leste Phone: +670 - 77305782	ANGEL'AQUIRA Consultant, Unipessoal Lda. Architectural & Engineering Design, Supervision and Project Management Vila Verde, Dili, Timor - Leste, Phone: +670 - 7238140 E-mail: ino_neves@yahoo.com	REHABILITAÇÃO DE ABRIGUS DA RESISTÊNCIA	DRAINAGE SECTION	DRAWING BY:	APPROVED BY:	APPROVED BY:					26 OF 44
		ABRIGU LURBA									
		LURBA, BOBONARO TIMOR LESTE	Arch. Aquilino F. das Neves	Eng. Jesuino J.X. Neves	Sr. Hamar Antoninho Baptista Alves Director e Presidente AMRT	Eng. Octavio P. Marques, M.Eng. HEAD OF PROJECT DEPARTMENT		Arch. Rosa Amaral Vong Directress of DNE		DRAWING NO: ARCH	
		LOCATION : BOBONARO	SCALE : 1:1000	DATE :	DATE :	DATE :					26 OF 44

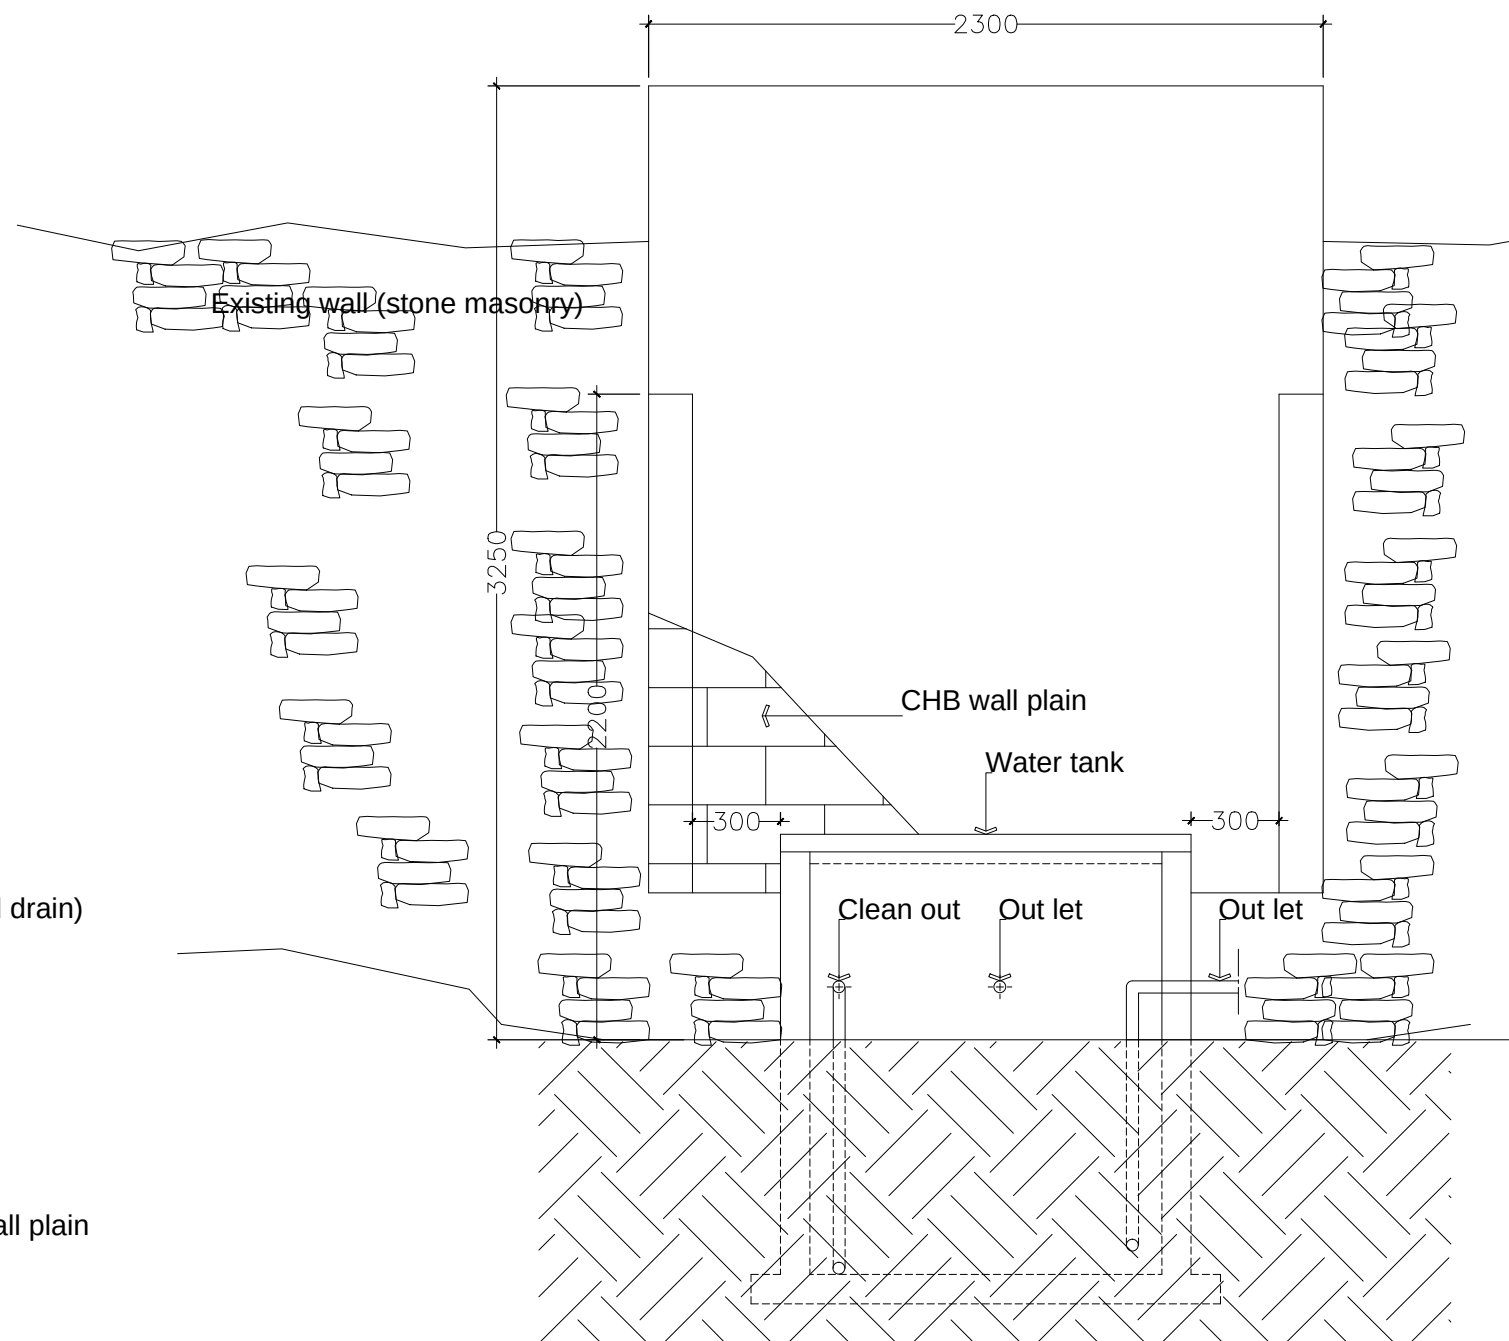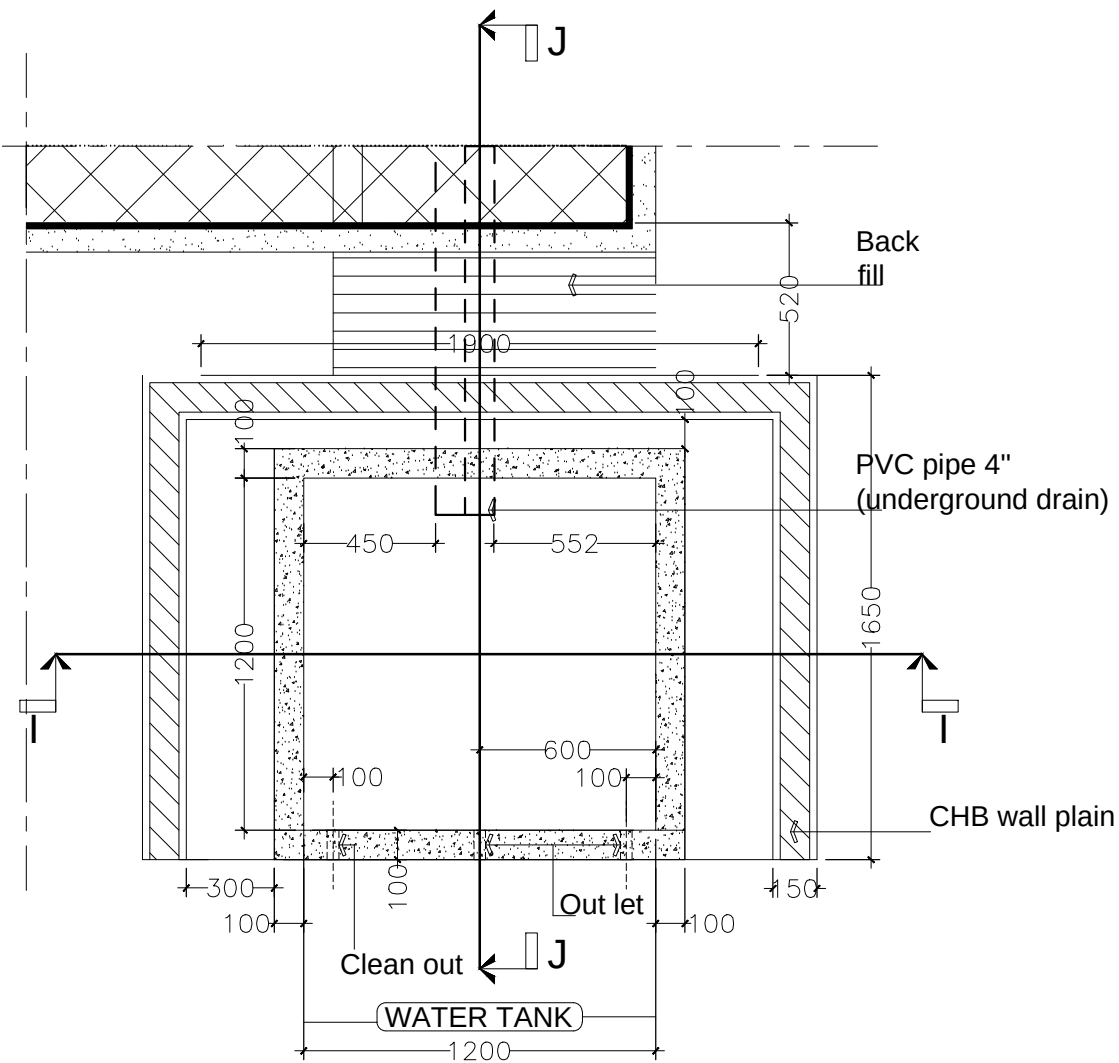




CLIENT / PROJECT OWNER	PREPARED BY	PROJECT TITLE	DRAWING TITLE	CONSULTANT DESIGN: A3R CONSULTANT		PROJECT OWNER	DEMOCRATIC REPUBLIC OF TIMOR LESTE MINISTRY OF PUBLIC WORK, TRANSPORT AND COMMUNICATION GENERAL DIRECTORATE OF PUBLIC WORKS NATIONAL DIRECTORATE OF BUILDING				SHEET NO:
				DRAWING BY:	APPROVED BY:						
 ARQUIVO & MUSEU RESISTÊNCIA TIMORENSE INSTITUTO PÚBLICO REPÚBLICA DEMOCRÁTICA DE TIMOR LESTE Avenida Cidade de Lisboa, Dili, Timor Leste Phone: +670 - 77305782	 ANGEL'AQUIRA Consultant, Unipessoal Lda. Architectural & Engineering Design, Supervision and Project Management Vila Verde, Dili, Timor - Leste, Phone: +670 - 7238140 E-mail: ino_neves@yahoo.com	REHABILITAÇÃO DE ABRIGOS DA RESISTÊNCIA ABRIGU LURBA LURBA, BOBONARO TIMOR LESTE LOCATION : BOBONARO	WATER TANK PLAN SCALE : 1:500	Arch. Aquilino F. das Neves	Eng. Jesuino J.X. Neves	Sr. Hamar Antoninho Baptista Alves Director e Presidente AMRT					27 OF 44 DRAWING NO: ARCH 27 OF 44
				DATE :	DATE :		VERIFIED BY:	DATE	APPROVED BY:	DATE	
							Eng. Octavio P. Marques, M.Eng. HEAD OF PROJECT DEPARTMENT		Arch. Rosa Amaral Vong Directress of DNE		

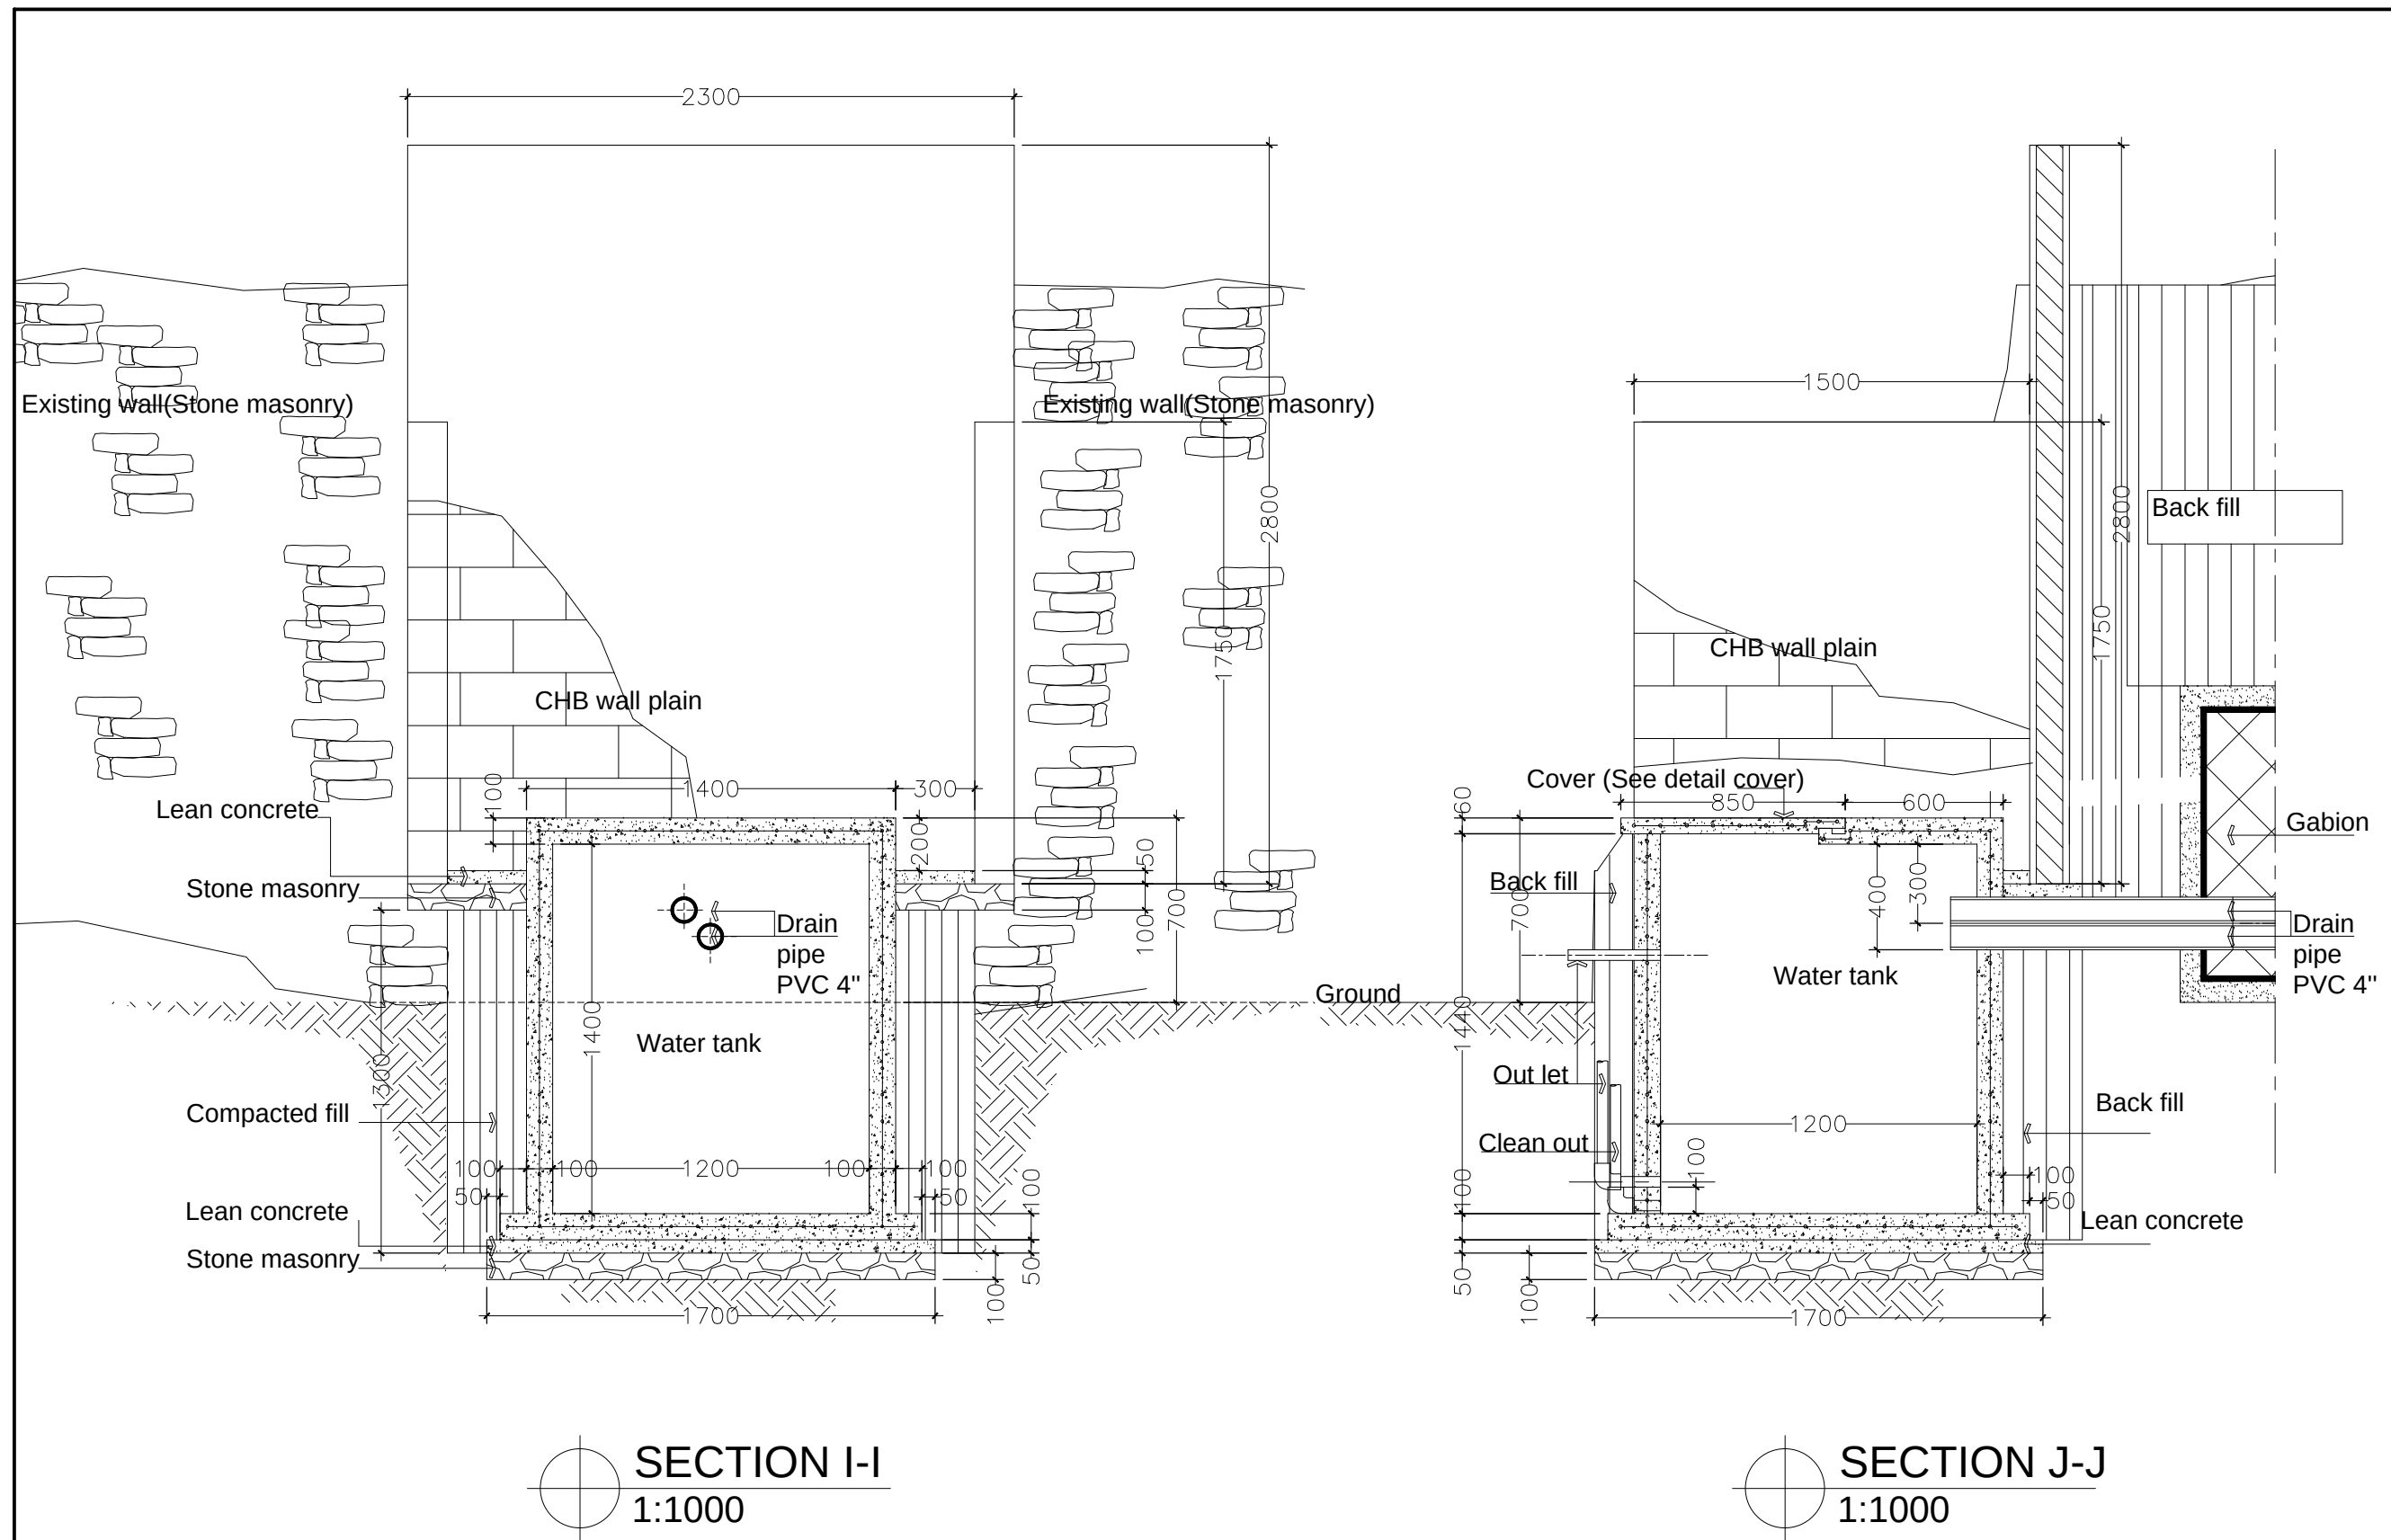

CLIENT / PROJECT OWNER	PREPARED BY	PROJECT TITLE	DRAWING TITLE	CONSULTANT DESIGN: A3R CONSULTANT		PROJECT OWNER	DEMOCRATIC REPUBLIC OF TIMOR LESTE MINISTRY OF PUBLIC WORK, TRANSPORT AND COMMUNICATION GENERAL DIRECTORATE OF PUBLIC WORKS NATIONAL DIRECTORATE OF BUILDING				SHEET NO:
		REHABILITAÇÃO DE ABRIGOS DA RESISTÊNCIA	WATER TANK SECTION	DRAWING BY:	APPROVED BY:	APPROVED BY:					28 OF 44
ARQUIVO & MUSEU RESISTÊNCIA TIMORENSE INSTITUTO PÚBLICO REPÚBLICA DEMOCRÁTICA DE TIMOR LESTE Avenida Cidade de Lisboa, Díli, Timor Leste Phone: +670 - 77305782	ANGEL'AQUIRA Consultant, Unipessoal Lda. Architectural & Engineering Design, Supervision and Project Management Vila Verde, Díli, Timor - Leste, Phone: +670 - 7238140 E-mail: ino_neves@yahoo.com	ABRIGU LURBA LURBA, BOBONARO TIMOR LESTE		Arch. Aquilino F. das Neves	Eng. Jesuino J.X. Neves	Sr. Hamar Antoninho Baptista Alves Director e Presidente AMRT	VERIFIED BY:	DATE	APPROVED BY:	DATE	DRAWING NO:
		LOCATION : BOBONARO	SCALE : 1:500	DATE :	DATE :	DATE :	Eng. Octavio P. Marques, M.Eng. HEAD OF PROJECT DEPARTMENT		Arch. Rosa Amaral Vong Directress of DNE		ARCH 28 OF 44

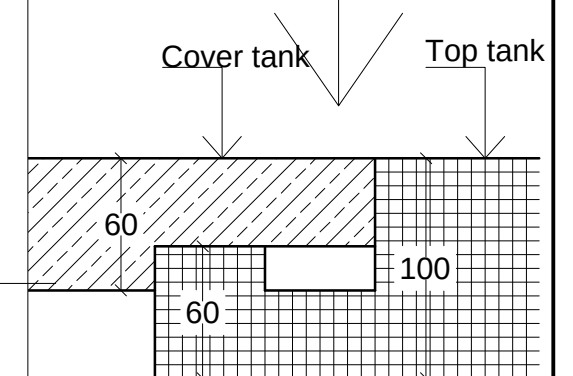


Cover tank

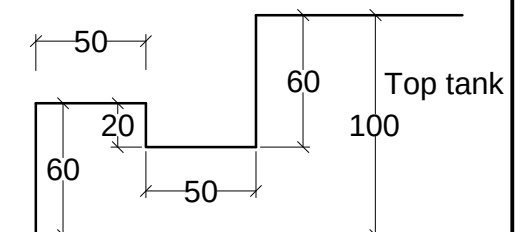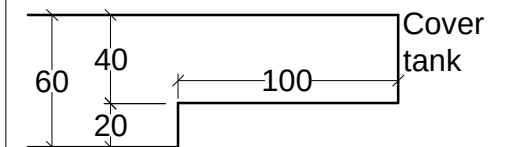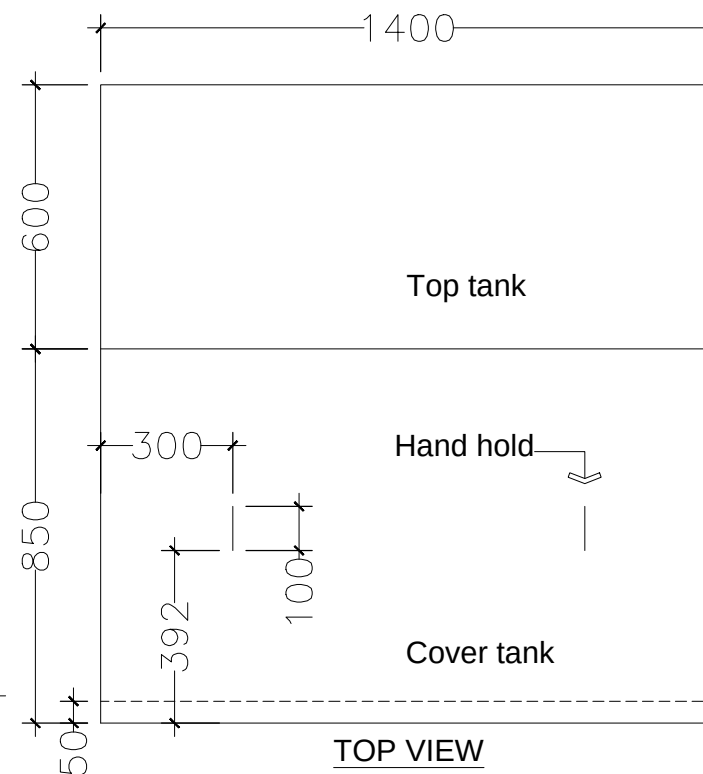


DETAIL
1:50


WATER TANK COVER DETAILS

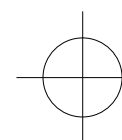ARCH
29 OF 44

Arch. Rosa Amaral Vong
Directress of DNE

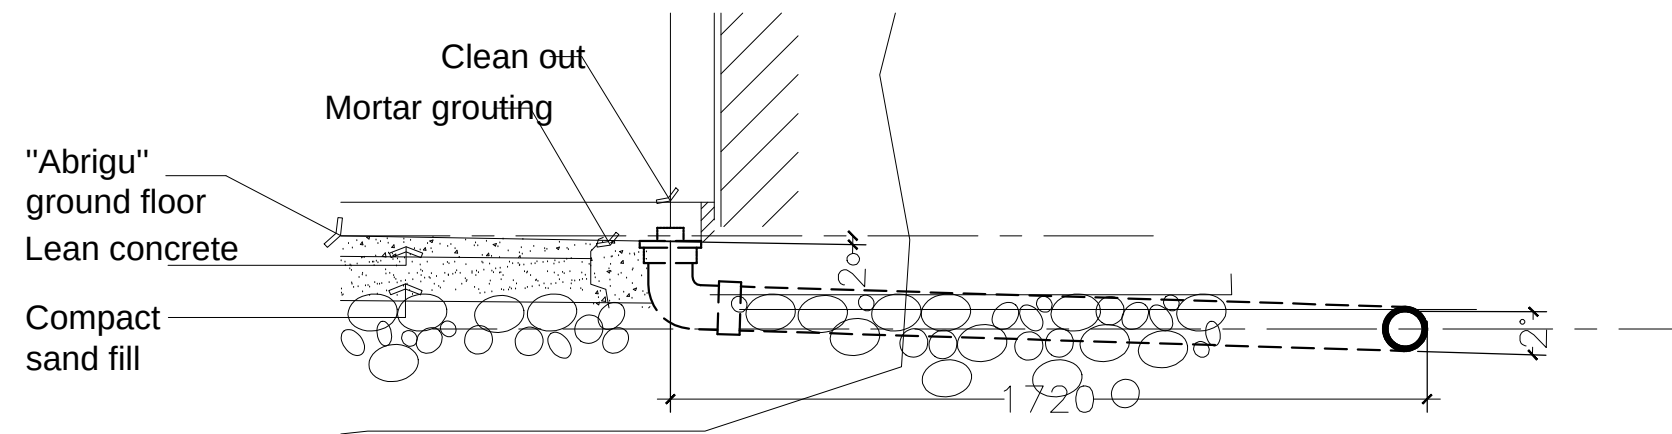


"ABRIGU" FLOOR DRAIN DETAILS

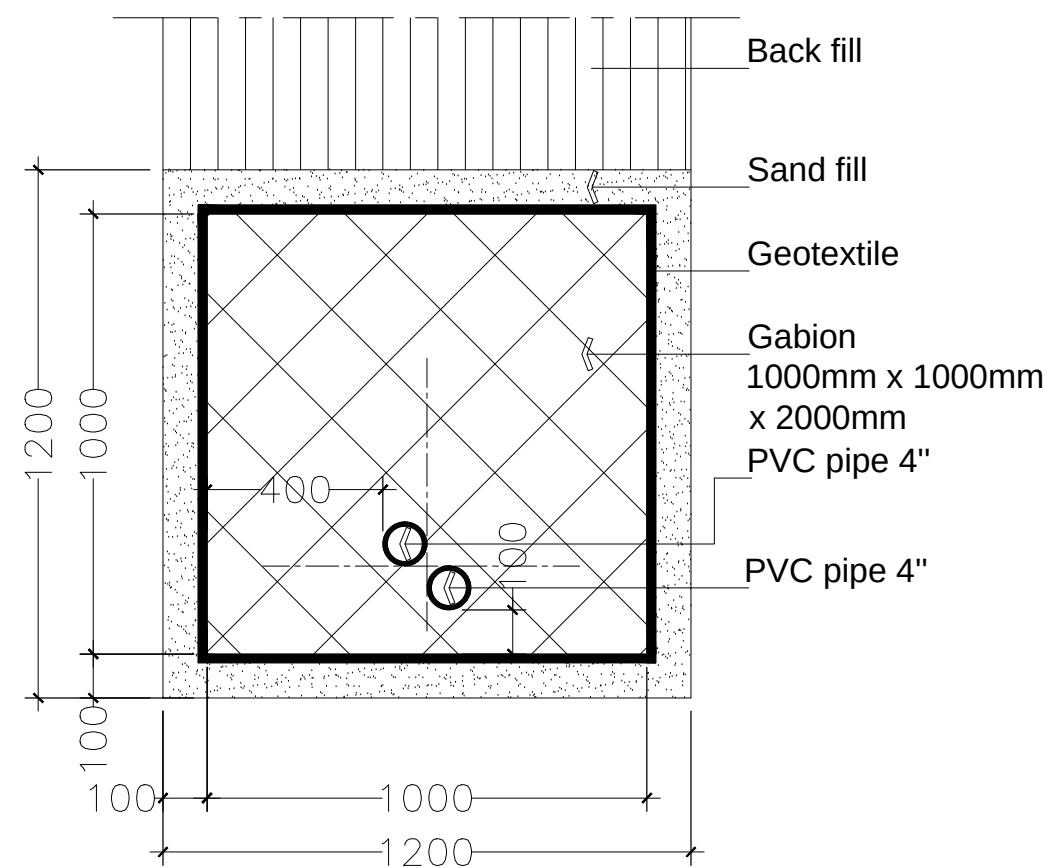


GABION INSTALLATION AND DETAILS (DETAIL 4)




CLIENT / PROJECT OWNER	PREPARED BY	PROJECT TITLE	DRAWING TITLE	CONSULTANT DESIGN: A3R CONSULTANT		PROJECT OWNER	 DEMOCRATIC REPUBLIC OF TIMOR LESTE MINISTRY OF PUBLIC WORK, TRANSPORT AND COMMUNICATION GENERAL DIRECTORATE OF PUBLIC WORKS NATIONAL DIRECTORATE OF BUILDING				SHEET NO:
 ARQUIVO & MUSEU RESISTÊNCIA TIMORENSE INSTITUTO PÚBLICO REPÚBLICA DEMOCRÁTICA DE TIMOR LESTE Avenida Cidade de Lisboa, Díli, Timor Leste Phone: +670 - 77305782	ANGEL'AQUIRA Consultant, Unipessoal Lda. Architectural & Engineering Design, Supervision and Project Management Vila Verde, Díli, Timor - Leste, Phone: +670 - 7238140 E-mail: ino_neves@yahoo.com	REHABILITAÇÃO DE ABRIGOS DA RESISTÊNCIA ABRIGU LURBA LURBA, BOBONARO TIMOR LESTE	DRAINAGE DETAILS	DRAWING BY:	APPROVED BY:	APPROVED BY:					30 OF 44
				Arch. Aquilino F. das Neves	Eng. Jesuino J.X. Neves	Sr. Hamar Antoninho Baptista Alves Director e Presidente AMRT	VERIFIED BY:	DATE	APPROVED BY:	DATE	DRAWING NO:
LOCATION : BOBONARO				DATE :	DATE :	DATE :	Eng. Octavio P. Marques, M.Eng. HEAD OF PROJECT DEPARTMENT		Arch. Rosa Amaral Vong Directress of DNE		ARCH 30 OF 44

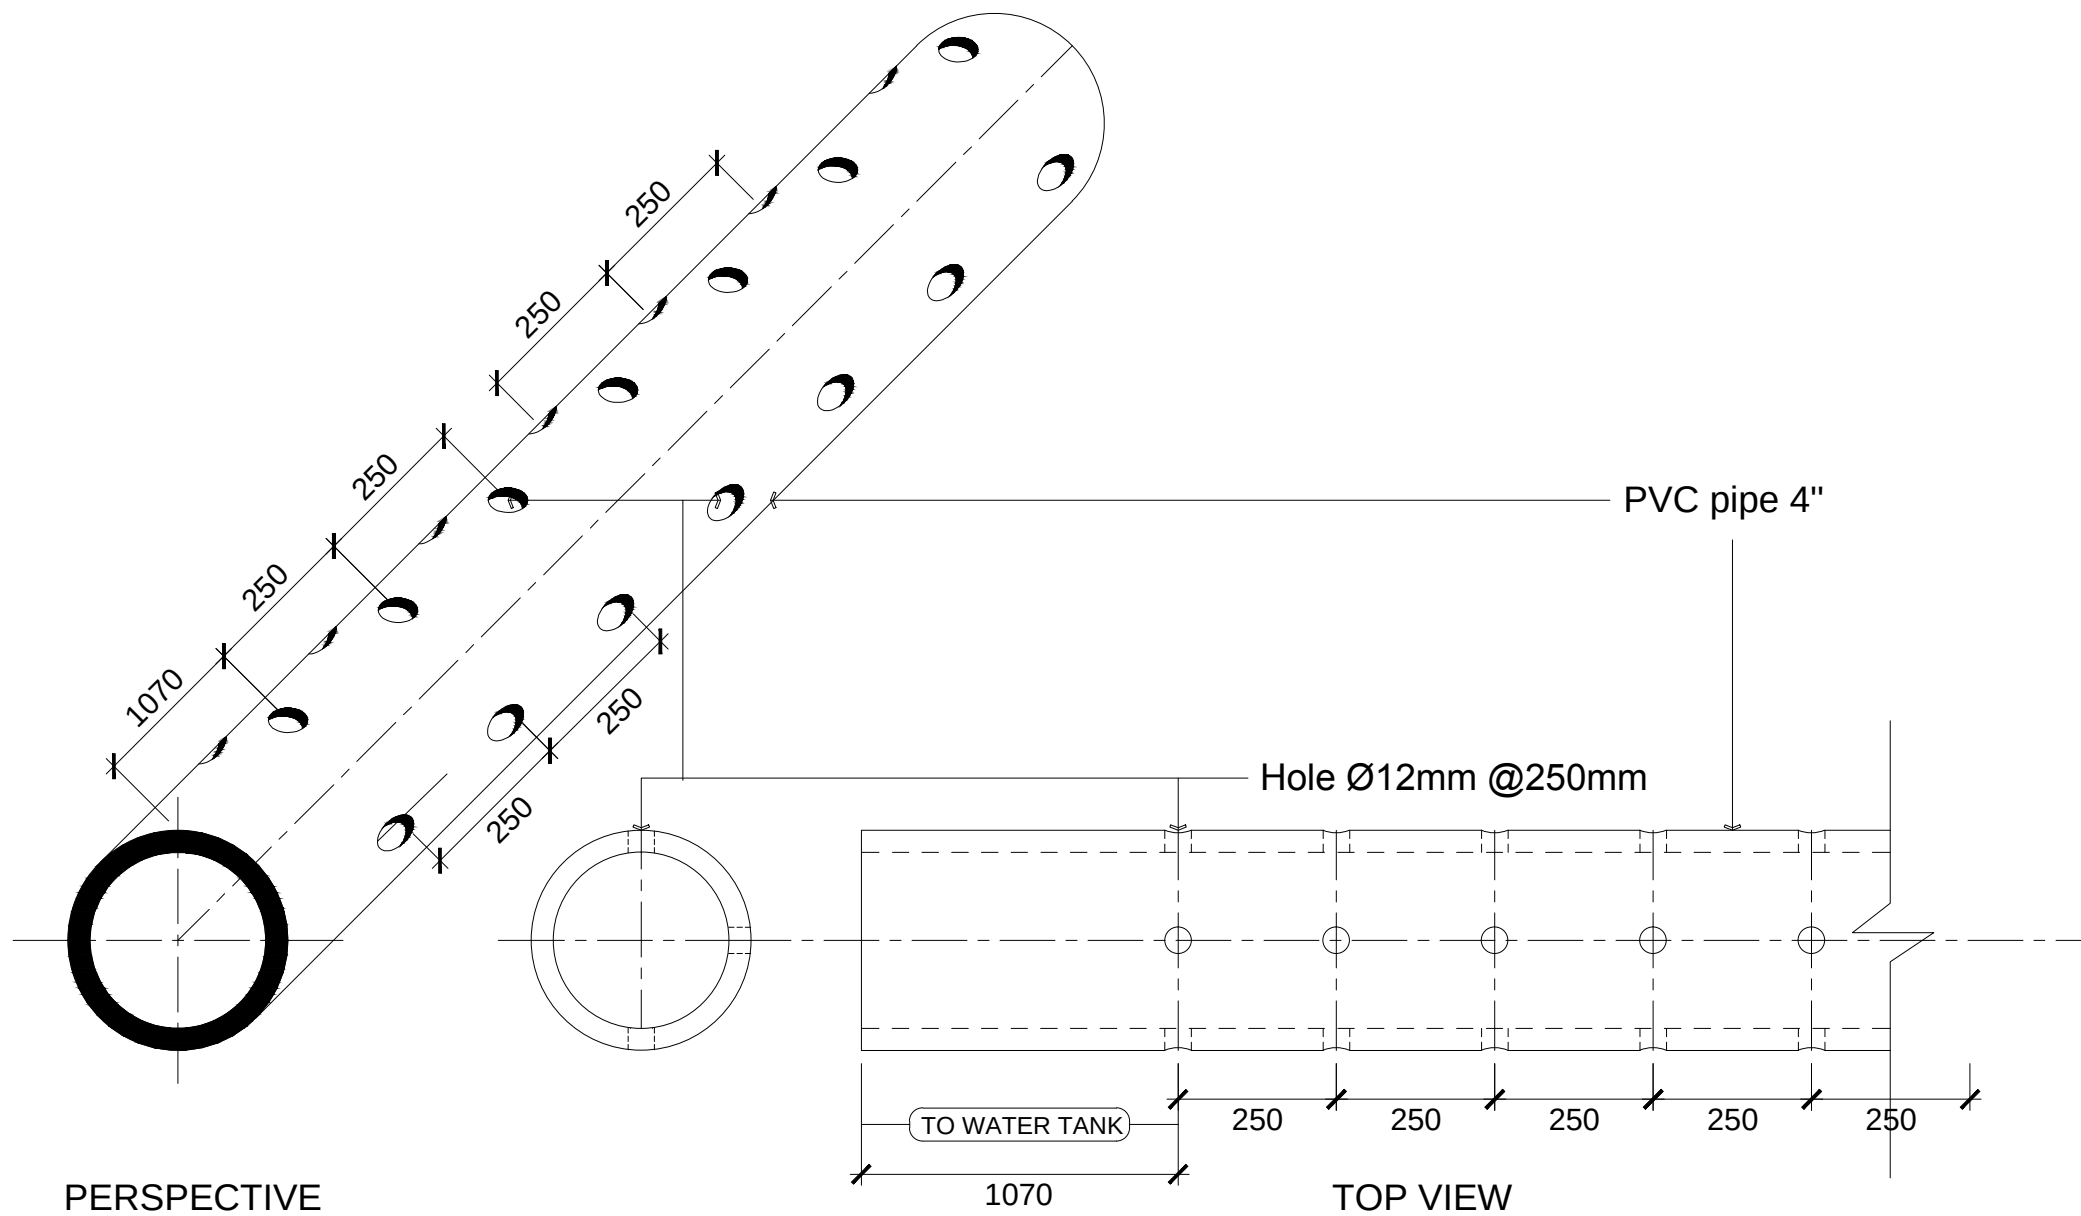

 

DRAINAGE PIPE DETAILS
 1:500

CLIENT / PROJECT OWNER		PREPARED BY	PROJECT TITLE	DRAWING TITLE	CONSULTANT DESIGN: A3R CONSULTANT		PROJECT OWNER		DEMOCRATIC REPUBLIC OF TIMOR LESTE				SHEET NO:
 ARQUIVO & MUSEU RESISTÊNCIA TIMORENSE INSTITUTO PÚBLICO REPÚBLICA DEMOCRÁTICA DE TIMOR LESTE Avenida Cidade de Lisboa, Díli, Timor Leste Phone: +670 - 77305782		 ANGEL'AQUIRA Consultant, Unipessoal Lda. Architectural & Engineering Design, Supervision and Project Management Vila Verde, Díli, Timor - Leste, Phone: +670 - 7238140 E-mail: ino_neves@yahoo.com	REHABILITAÇÃO DE ABRIGOS DA RESISTÊNCIA	DRAINAGE PIPE DETAILS	DRAWING BY:		APPROVED BY:		 MINISTRY OF PUBLIC WORK, TRANSPORT AND COMMUNICATION GENERAL DIRECTORATE OF PUBLIC WORKS NATIONAL DIRECTORATE OF BUILDING		31 OF 44		
							LOCATION :		SCALE :	DATE :	DATE :	DATE :	VERIFIED BY:
		BOBONARO		1:500	Arch. Aquilino F. das Neves	Eng. Jesuino J.X. Neves	Sr. Hamar Antoninho Baptista Alves Director e Presidente AMRT	Eng. Octavio P. Marques, M.Eng. HEAD OF PROJECT DEPARTMENT		Arch. Rosa Amaral Vong Directress of DNE		ARCH 31 OF 44	

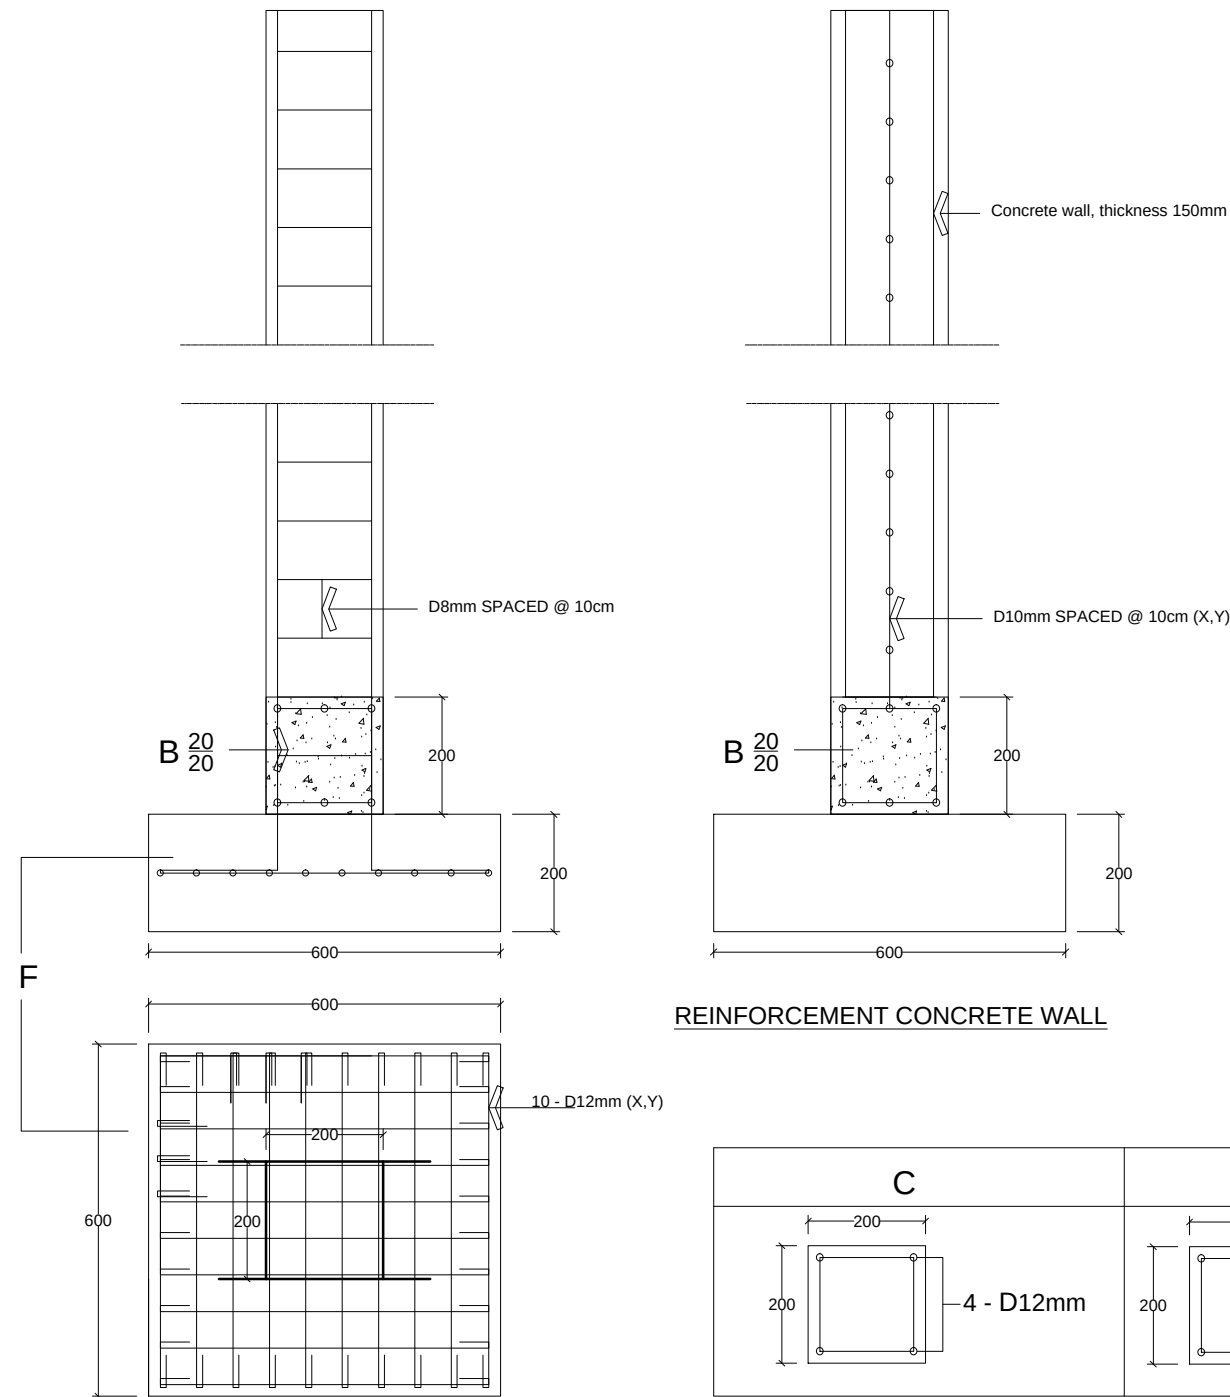

REINFORCEMENT CONCRETE WALL

 FOOT PLATE & COLUMN



REINFORCEMENT DETAILS

1:300

CLIENT / PROJECT OWNER		PREPARED BY	PROJECT TITLE	DRAWING TITLE	CONSULTANT DESIGN: A3R CONSULTANT		PROJECT OWNER		DEMOCRATIC REPUBLIC OF TIMOR LESTE MINISTRY OF PUBLIC WORK, TRANSPORT AND COMMUNICATION GENERAL DIRECTORATE OF PUBLIC WORKS NATIONAL DIRECTORATE OF BUILDING				SHEET NO:
 ARQUIVO & MUSEU RESISTÊNCIA TIMORENSE INSTITUTO PÚBLICO REPÚBLICA DEMOCRÁTICA DE TIMOR LESTE Avenida Cidade de Lisboa, Díli, Timor Leste Phone: +670 - 77305782		 ANGEL'AQUIRA Consultant, Unipessoal Lda. Architectural & Engineering Design, Supervision and Project Management Vila Verde, Díli, Timor - Leste, Phone: +670 - 7238140 E-mail: ino_neves@yahoo.com	REHABILITAÇÃO DE ABRIGUS DA RESISTÊNCIA ABRIGU LURBA LURBA, BOBONARO TIMOR LESTE	REINFORCEMENT DETAILS							32 OF 44		
									VERIFIED BY:		DATE	APPROVED BY:	DATE
					Arch. Aquilino F. das Neves		Eng. Jesuino J.X. Neves		Sr. Hamar Antoninho Baptista Alves Director e Presidente AMRT		Eng. Octavio P. Marques, M.Eng. HEAD OF PROJECT DEPARTMENT		Arch. Rosa Amaral Yong Directress of DNE
			LOCATION : BOBONARO	SCALE : 1:300	DATE :		DATE :		DATE :				DRAWING NO: ARCH 32 OF 44