



CLIENT / PROJECT OWNER		PREPARED BY	PROJECT TITLE	DRAWING TITLE	CONSULTANT DESIGN: A3R CONSULTANT		PROJECT OWNER	DEMOCRATIC REPUBLIC OF TIMOR LESTE MINISTRY OF PUBLIC WORK, TRANSPORT AND COMMUNICATION GENERAL DIRECTORATE OF PUBLIC WORKS NATIONAL DIRECTORATE OF BUILDING				SHEET NO:
 ARQUIVO & MUSEU RESISTÊNCIA TIMORENSE INSTITUTO PÚBLICO REPÚBLICA DEMOCRÁTICA DE TIMOR LESTE Avenida Cidade de Lisboa, Dili, Timor Leste Phone: +670 - 77305782		 ANGEL'AQUIRA Consultancy, Unipessoal Lda. Architectural & Engineering Design, Supervision and Project Management Vila Verde, Dili, Timor - Leste, Phone: +670 - 7238140 E-mail: ino_neves@yahoo.com	REHABILITAÇÃO DE ABRIGOS DA RESISTÊNCIA ABRIGU FATU META FATU META, DILI TIMOR LESTE	LOCATION MAP	DRAWING BY:	APPROVED BY:	APPROVED BY:					
LOCATION :		DILI	SCALE :	N. S	DATE :	DATE :	DATE :	VERIFIED BY:	DATE	APPROVED BY:	DATE	DRAWING NO:
					Arch. Aquilino F. das Neves	Eng. Jesuino J.X. Neves	Sr. Hamar Antoninho Baptista Alves Director e Presidente AMRT	Eng. Octavio P. Marques, M.Eng. HEAD OF PROJECT DEPARTMENT		Arch. Rosa Amaral Vong Directress of DNE		

TABLE OF CONTENTS

I. "ABRIGU" HOUSE AND "ABRIGU"

A 01. EXISTING SITUATION

A 02. EXISTING SITE PLAN

A 03. EXISTING PLAN

A 04. REHABILITATION PLAN

A 05. ELEVATION

A 06. SECTION

A 07. SECTION

A 08. SECTION

A 09. "ABRIGU" EXISTING PLAN

A 10. "ABRIGU" SECTION

A 11. "ABRIGU" SECTION

A 12. "ABRIGU" SECTION

A 13. "ABRIGU" SECTION

A 14. "ABRIGU" SECTION

A 15. REHABILITATION ITEMS

A 16. REMOVE AND REPLACE ROOF SHEETS

A 17. REMOVE ANG REPLACE CEILING

A 18. REMOVE AND REPLACE EXISTING WINDOW AND DOOR

A 19. REMOVE AND REPLACE WALL (WL)

A 20. REMOVE AND REPLACE GROUND FLOOR

A 21. FLOOR PLAN

A 22. REMOVE AND REPLACE BEAM

A 23. "ABRIGU" REINFORCEMENT PLAN

A 24. "ABRIGU" REINFORCEMENT LAY OUT

 
A 25. "ABRIGU" REINFORCEMENT LAY OUT


A 26. "ABRIGU" REINFORCEMENT LAY OUT

A 27. "ABRIGU" TOP DACK LAY OUT

A 28. REMOVE AND REPLACE ELECTRICAL INSTALATION


A 29. REINFORCEMENT DETAILS


CLIENT / PROJECT OWNER	PREPARED BY	PROJECT TITLE	DRAWING TITLE	CONSULTANT DESIGN: A3R CONSULTANT		PROJECT OWNER		 DEMOCRATIC REPUBLIC OF TIMOR LESTE MINISTRY OF PUBLIC WORK, TRANSPORT AND COMMUNICATION GENERAL DIRECTORATE OF PUBLIC WORKS NATIONAL DIRECTORATE OF BUILDING	SHEET NO:
 ARQUIVO & MUSEU RESISTÊNCIA TIMORENSE INSTITUTO PÚBLICO REPÚBLICA DEMOCRÁTICA DE TIMOR LESTE Avenida Cidade de Lisboa, Dili, Timor Leste Phone: +670 - 77305782	 ANGEL'AQUIRA Consultant, Unipessoal Lda. Architectural & Engineering Design, Supervision and Project Management Vila Verde, Dili, Timor - Leste, Phone: +670 - 7238140 E-mail: ino_neves@yahoo.com	REHABILITAÇÃO DE ABRIGUS DA RESISTÊNCIA	TABLE OF CONTENT	DRAWING BY:	APPROVED BY:	APPROVED BY:	00 OF 29		
		FATU META, DILI TIMOR LESTE		Arch. Aquilino F. das Neves	Eng. Jesuino J.X. Neves	Sr. Hamar Antoninho Baptista Alves Director e Presidente AMRT	DRAWING NO:		
		LOCATION : DILI	SCALE : N. S	DATE :	DATE :	DATE :	Eng. Octavio P. Marques, M.Eng. HEAD OF PROJECT DEPARTMENT	Arch. Rosa Amaral Vong Directress of DNE	ARCH 00 OF 29

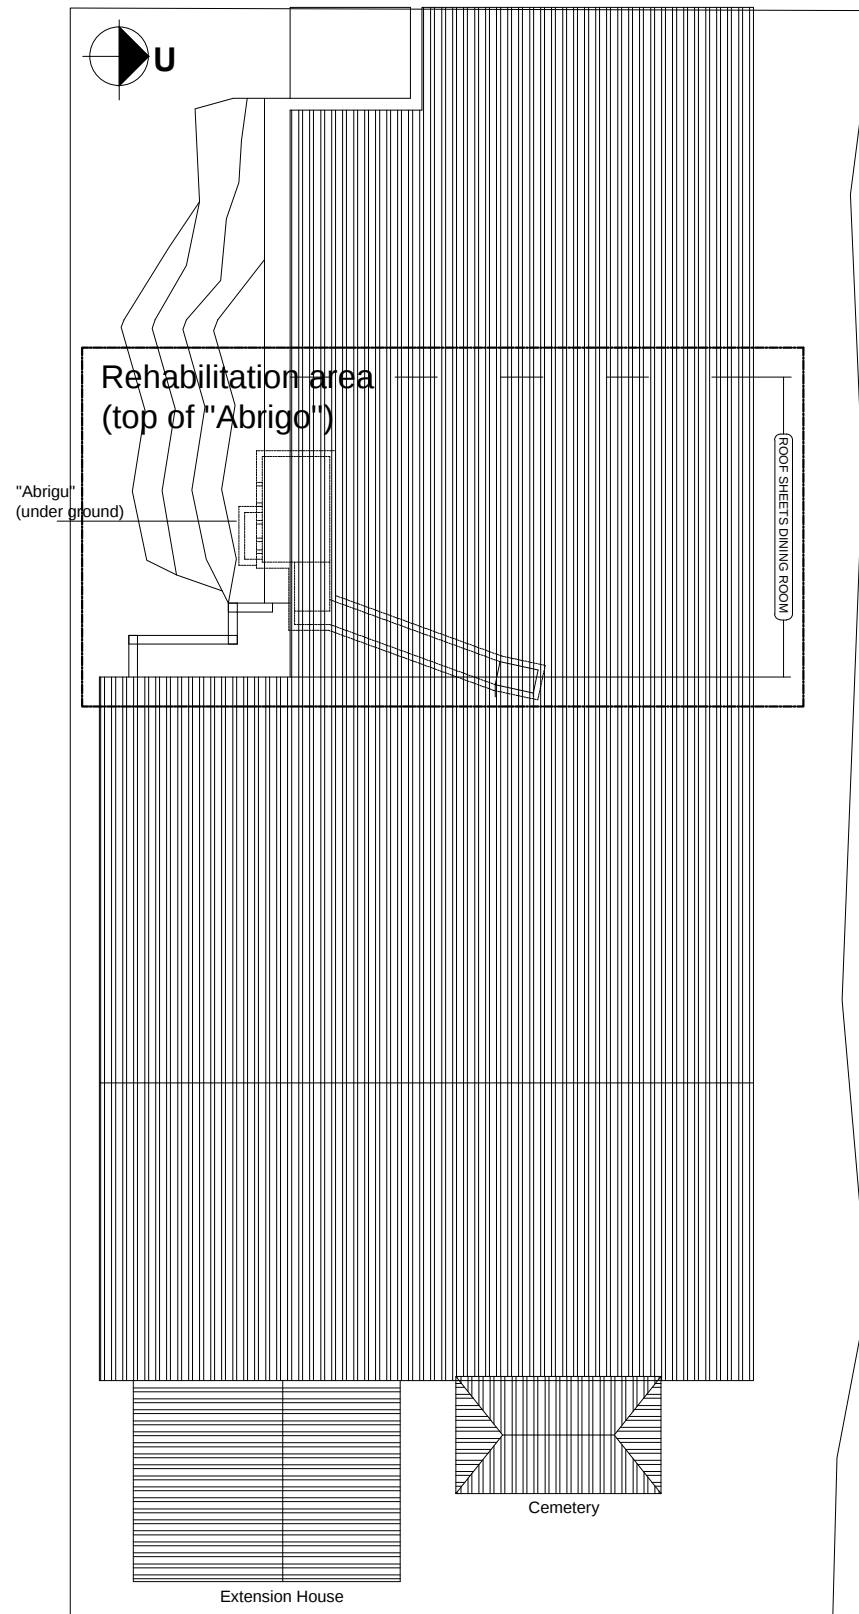


EXISTING SITUATION
1:3000


CLIENT / PROJECT OWNER	PREPARED BY	PROJECT TITLE	DRAWING TITLE	CONSULTANT DESIGN: A3R CONSULTANT		PROJECT OWNER		DEMOCRATIC REPUBLIC OF TIMOR LESTE MINISTRY OF PUBLIC WORK, TRANSPORT AND COMMUNICATION GENERAL DIRECTORATE OF PUBLIC WORKS NATIONAL DIRECTORATE OF BUILDING				SHEET NO:
 ARQUIVO & MUSEU RESISTÊNCIA TIMORENSE INSTITUTO PÚBLICO REPÚBLICA DEMOCRÁTICA DE TIMOR LESTE Avenida Cidade de Lisboa, Dili, Timor Leste Phone: +670 - 77305782	 ANGEL'AQUIRA Consultant, Unipessoal Lda. Architectural & Engineering Design, Supervision and Project Management Vila Verde, Dili, Timor - Leste, Phone: +670 - 7238140 E-mail: ino_neves@yahoo.com	REHABILITAÇÃO DE ABRIGUS DA RESISTÊNCIA	EXISTING SITUATION	DRAWING BY:		APPROVED BY:		APPROVED BY:		01 OF 29		
		FATU META, DILI TIMOR LESTE		Arch. Aquilino F. das Neves	Eng. Jesuino J.X. Neves	Sr. Hamar Antoninho Baptista Alves Director e Presidente AMRT				DRAWING NO: ARCH 01 OF 29		
		LOCATION : DILI	SCALE : 1:3000	DATE :	DATE :	DATE :	Eng. Octavio P. Marques, M.Eng. HEAD OF PROJECT DEPARTMENT	Arch. Rosa Amaral Vong Directress of DNE				

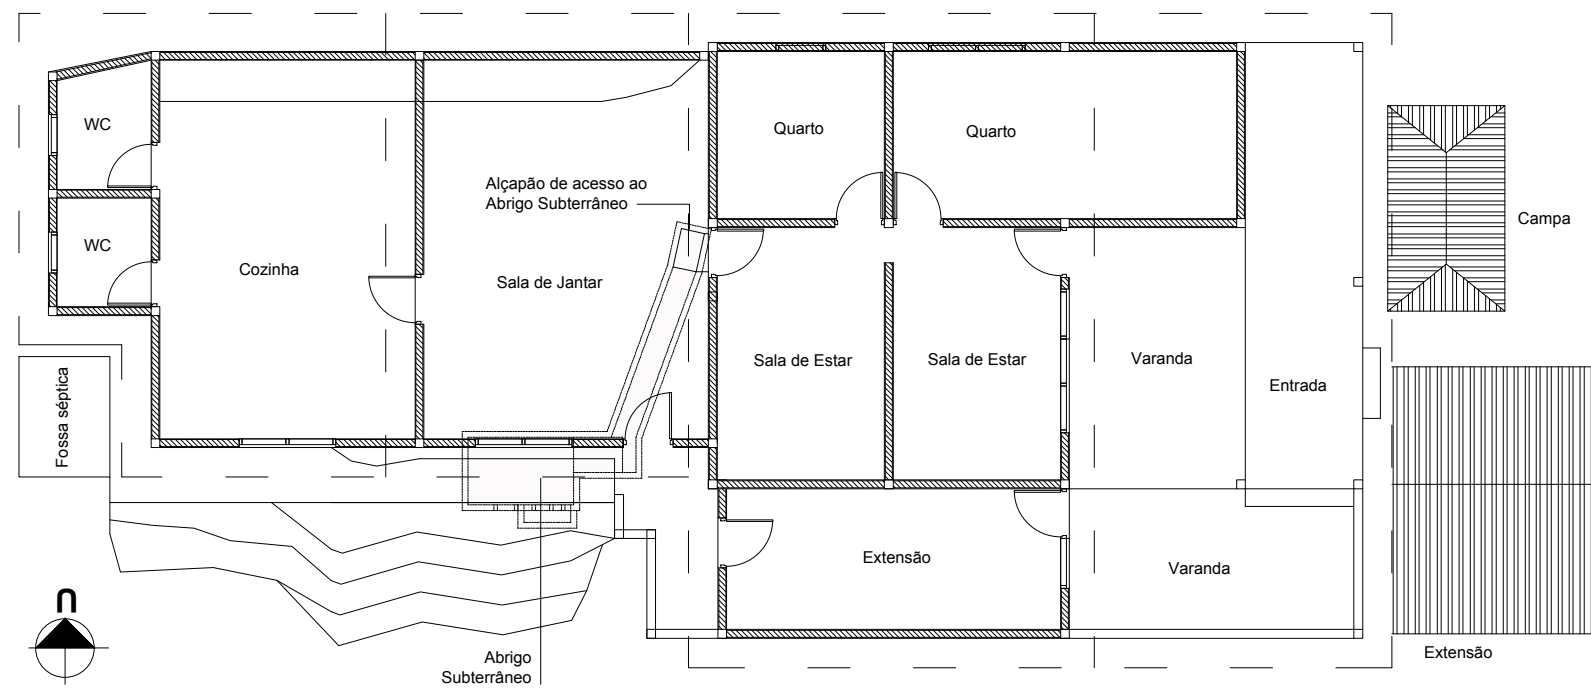

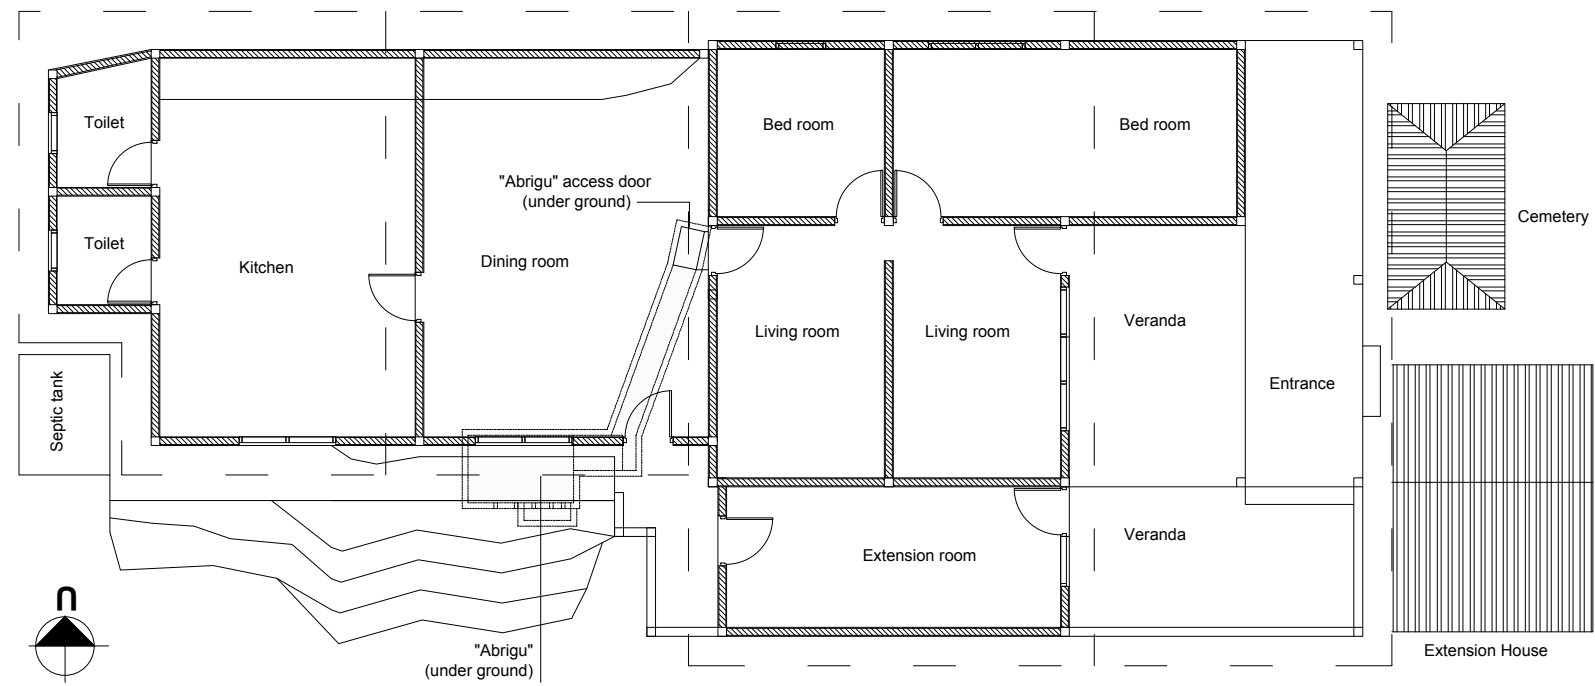

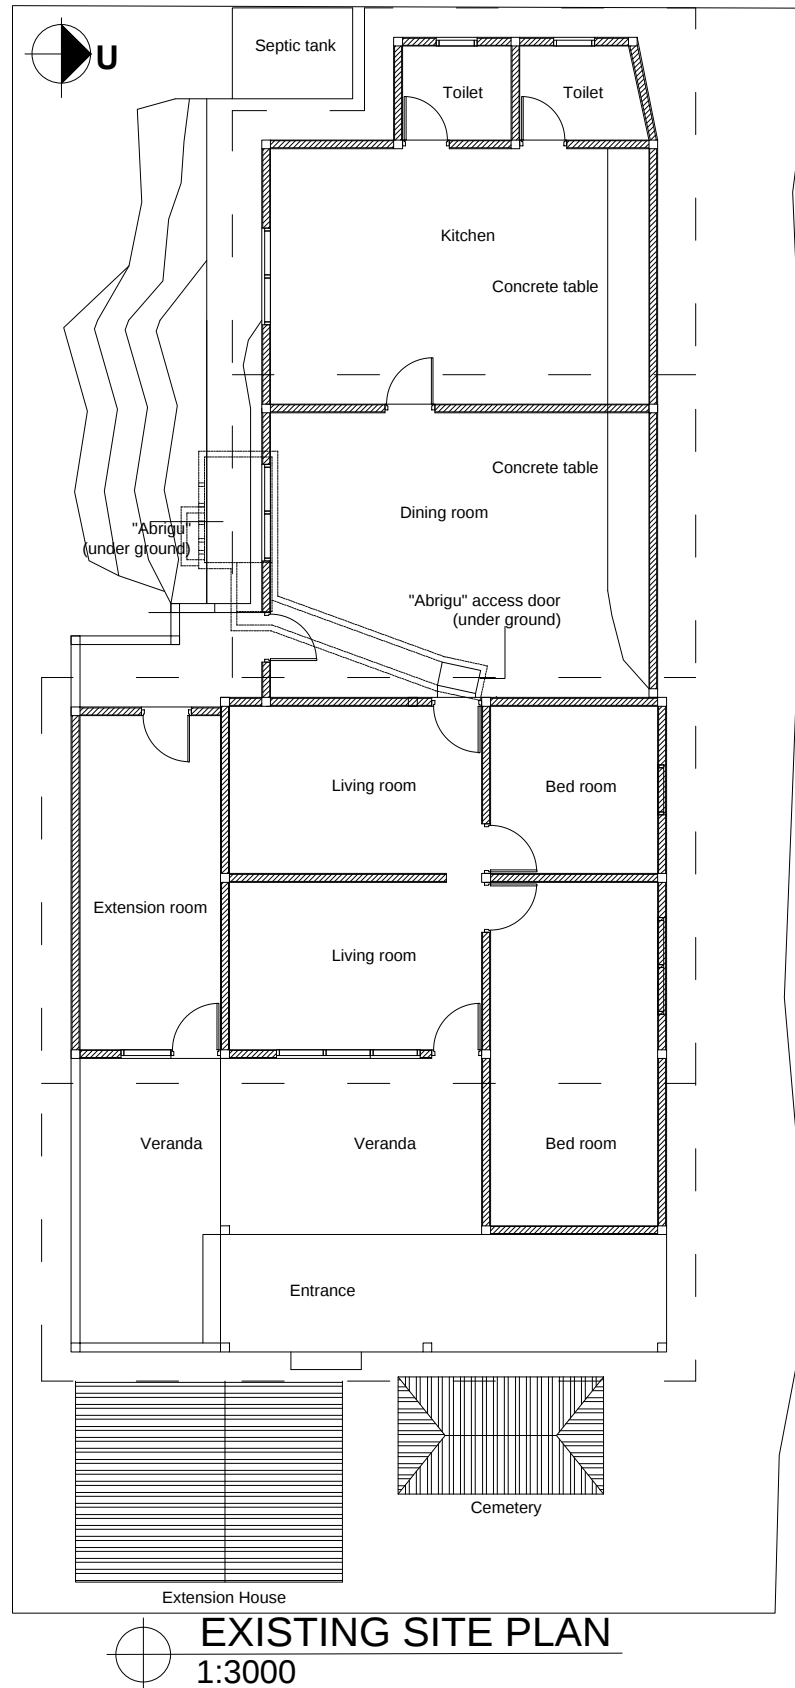


CLIENT / PROJECT OWNER		PREPARED BY	PROJECT TITLE	DRAWING TITLE	CONSULTANT DESIGN: A3R CONSULTANT		PROJECT OWNER	DEMOCRATIC REPUBLIC OF TIMOR LESTE MINISTRY OF PUBLIC WORK, TRANSPORT AND COMMUNICATION GENERAL DIRECTORATE OF PUBLIC WORKS NATIONAL DIRECTORATE OF BUILDING				SHEET NO:
 ARQUIVO & MUSEU RESISTÊNCIA TIMORENSE INSTITUTO PÚBLICO REPÚBLICA DEMOCRÁTICA DE TIMOR LESTE Avenida Cidade de Lisboa, Dili, Timor Leste Phone: +670 - 77305782		 ANGEL'AQUIRA Consultant, Unipessoal Lda. Architectural & Engineering Design, Supervision and Project Management Vila Verde, Dili, Timor - Leste, Phone: +670 - 7238140 E-mail: ino_neves@yahoo.com	REHABILITAÇÃO DE ABRIGUS DA RESISTÊNCIA ABRIGU FATU META FATU META, DILI TIMOR LESTE	EXISTING SITE PLAN	DRAWING BY:	APPROVED BY:	APPROVED BY:					02 OF 29
					Arch. Aquilino F. das Neves	Eng. Jesuino J.X. Neves	Sr. Hamar Antoninho Baptista Alves Director e Presidente AMRT	VERIFIED BY:	DATE	APPROVED BY:	DATE	DRAWING NO:
			LOCATION : DILI	SCALE : 1:3000	DATE :	DATE :	DATE :	Eng. Octavio P. Marques, M.Eng. HEAD OF PROJECT DEPARTMENT		Arch. Rosa Amaral Vong Directress of DNE		ARCH 02 OF 29

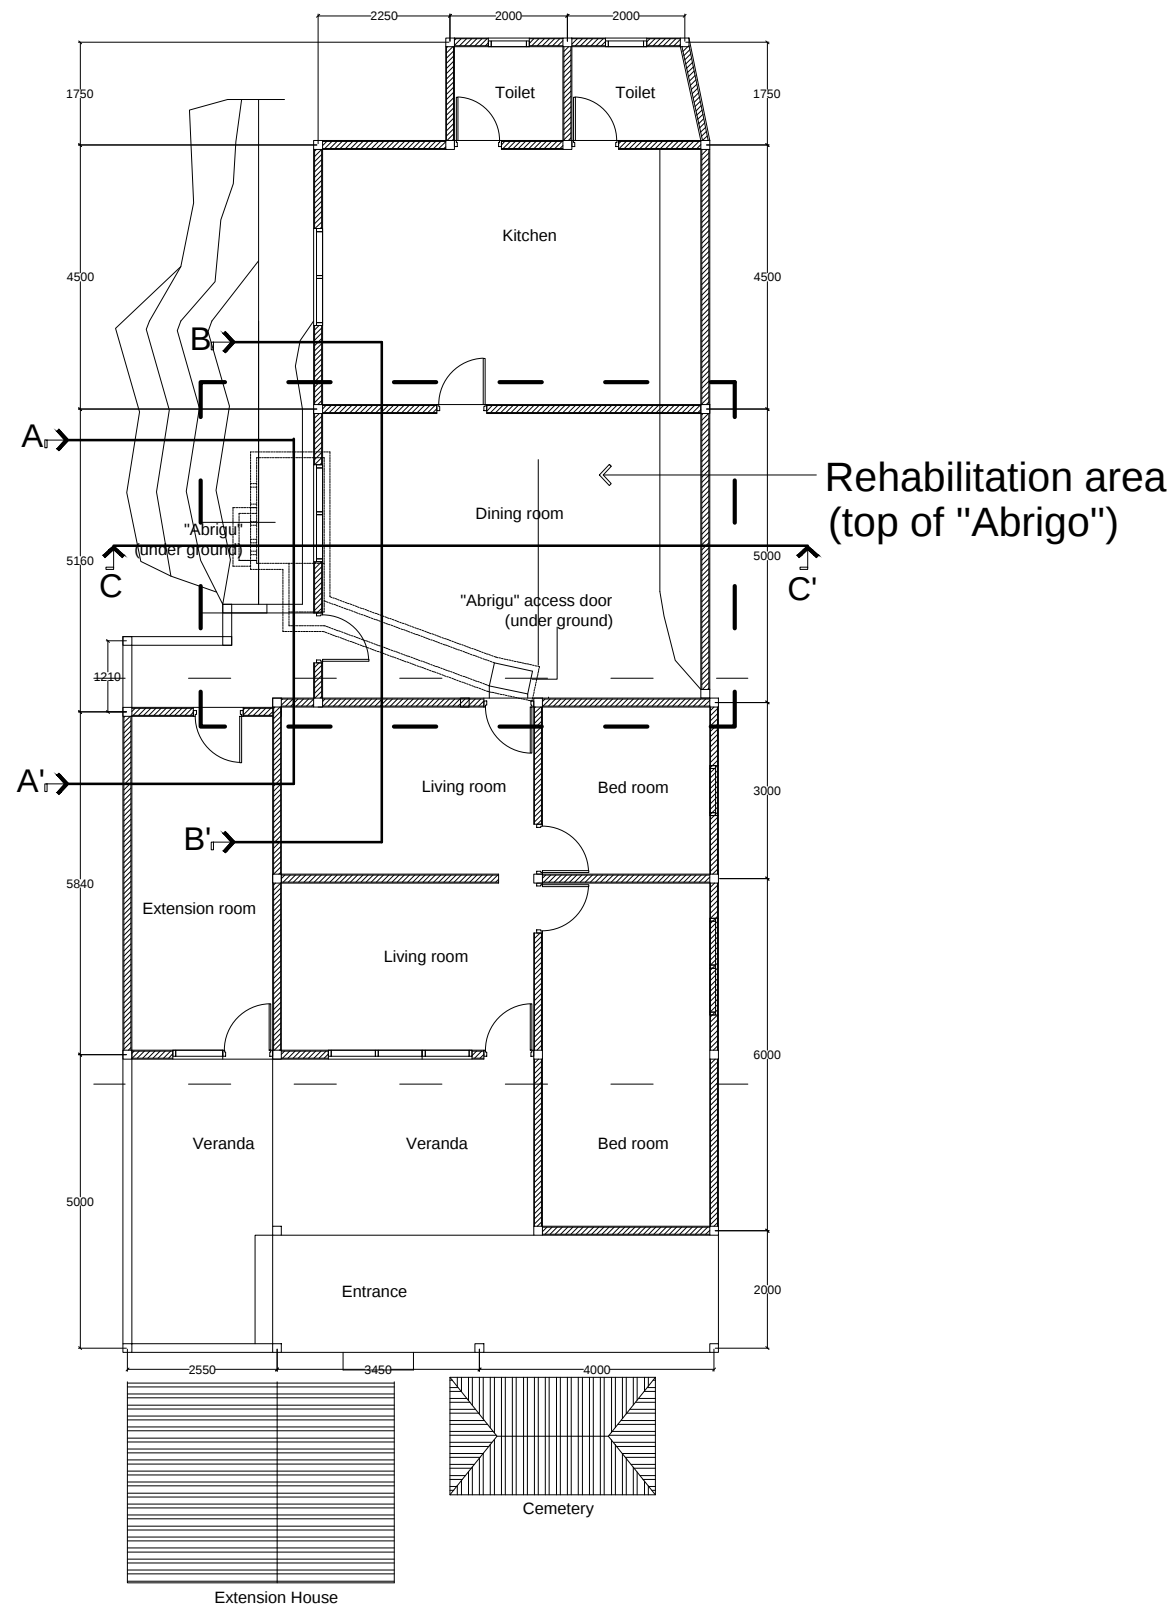


EXISTING PLAN
1:3000


CLIENT / PROJECT OWNER		PREPARED BY	PROJECT TITLE	DRAWING TITLE	CONSULTANT DESIGN: A3R CONSULTANT		PROJECT OWNER	DEMOCRATIC REPUBLIC OF TIMOR LESTE MINISTRY OF PUBLIC WORK, TRANSPORT AND COMMUNICATION GENERAL DIRECTORATE OF PUBLIC WORKS NATIONAL DIRECTORATE OF BUILDING				SHEET NO:
 ARQUIVO & MUSEU RESISTÊNCIA TIMORENSE INSTITUTO PÚBLICO REPÚBLICA DEMOCRÁTICA DE TIMOR LESTE Avenida Cidade de Lisboa, Díli, Timor Leste Phone: +670 - 77305782		 ANGEL'AQUIRA Consultant, Unipessoal Lda. Architectural & Engineering Design, Supervision and Project Management Vila Verde, Díli, Timor - Leste, Phone: +670 - 7238140 E-mail: ino_neves@yahoo.com	REHABILITAÇÃO DE ABRIGUS DA RESISTÊNCIA ABRIGU FATU META FATU META, DILI TIMOR LESTE	EXISTING PLAN	DRAWING BY:	APPROVED BY:	APPROVED BY:					03 OF 29
					Arch. Aquilino F. das Neves	Eng. Jesuino J.X. Neves	Sr. Hamar Antoninho Baptista Alves Director e Presidente AMRT	VERIFIED BY:	DATE	APPROVED BY:	DATE	
			LOCATION :	DILI	SCALE :	1:3000	DATE :	DATE :	DATE :	Eng. Octavio P. Marques, M.Eng. HEAD OF PROJECT DEPARTMENT	Arch. Rosa Amaral Vong Directress of DNE	DRAWING NO: ARCH 03 OF 29

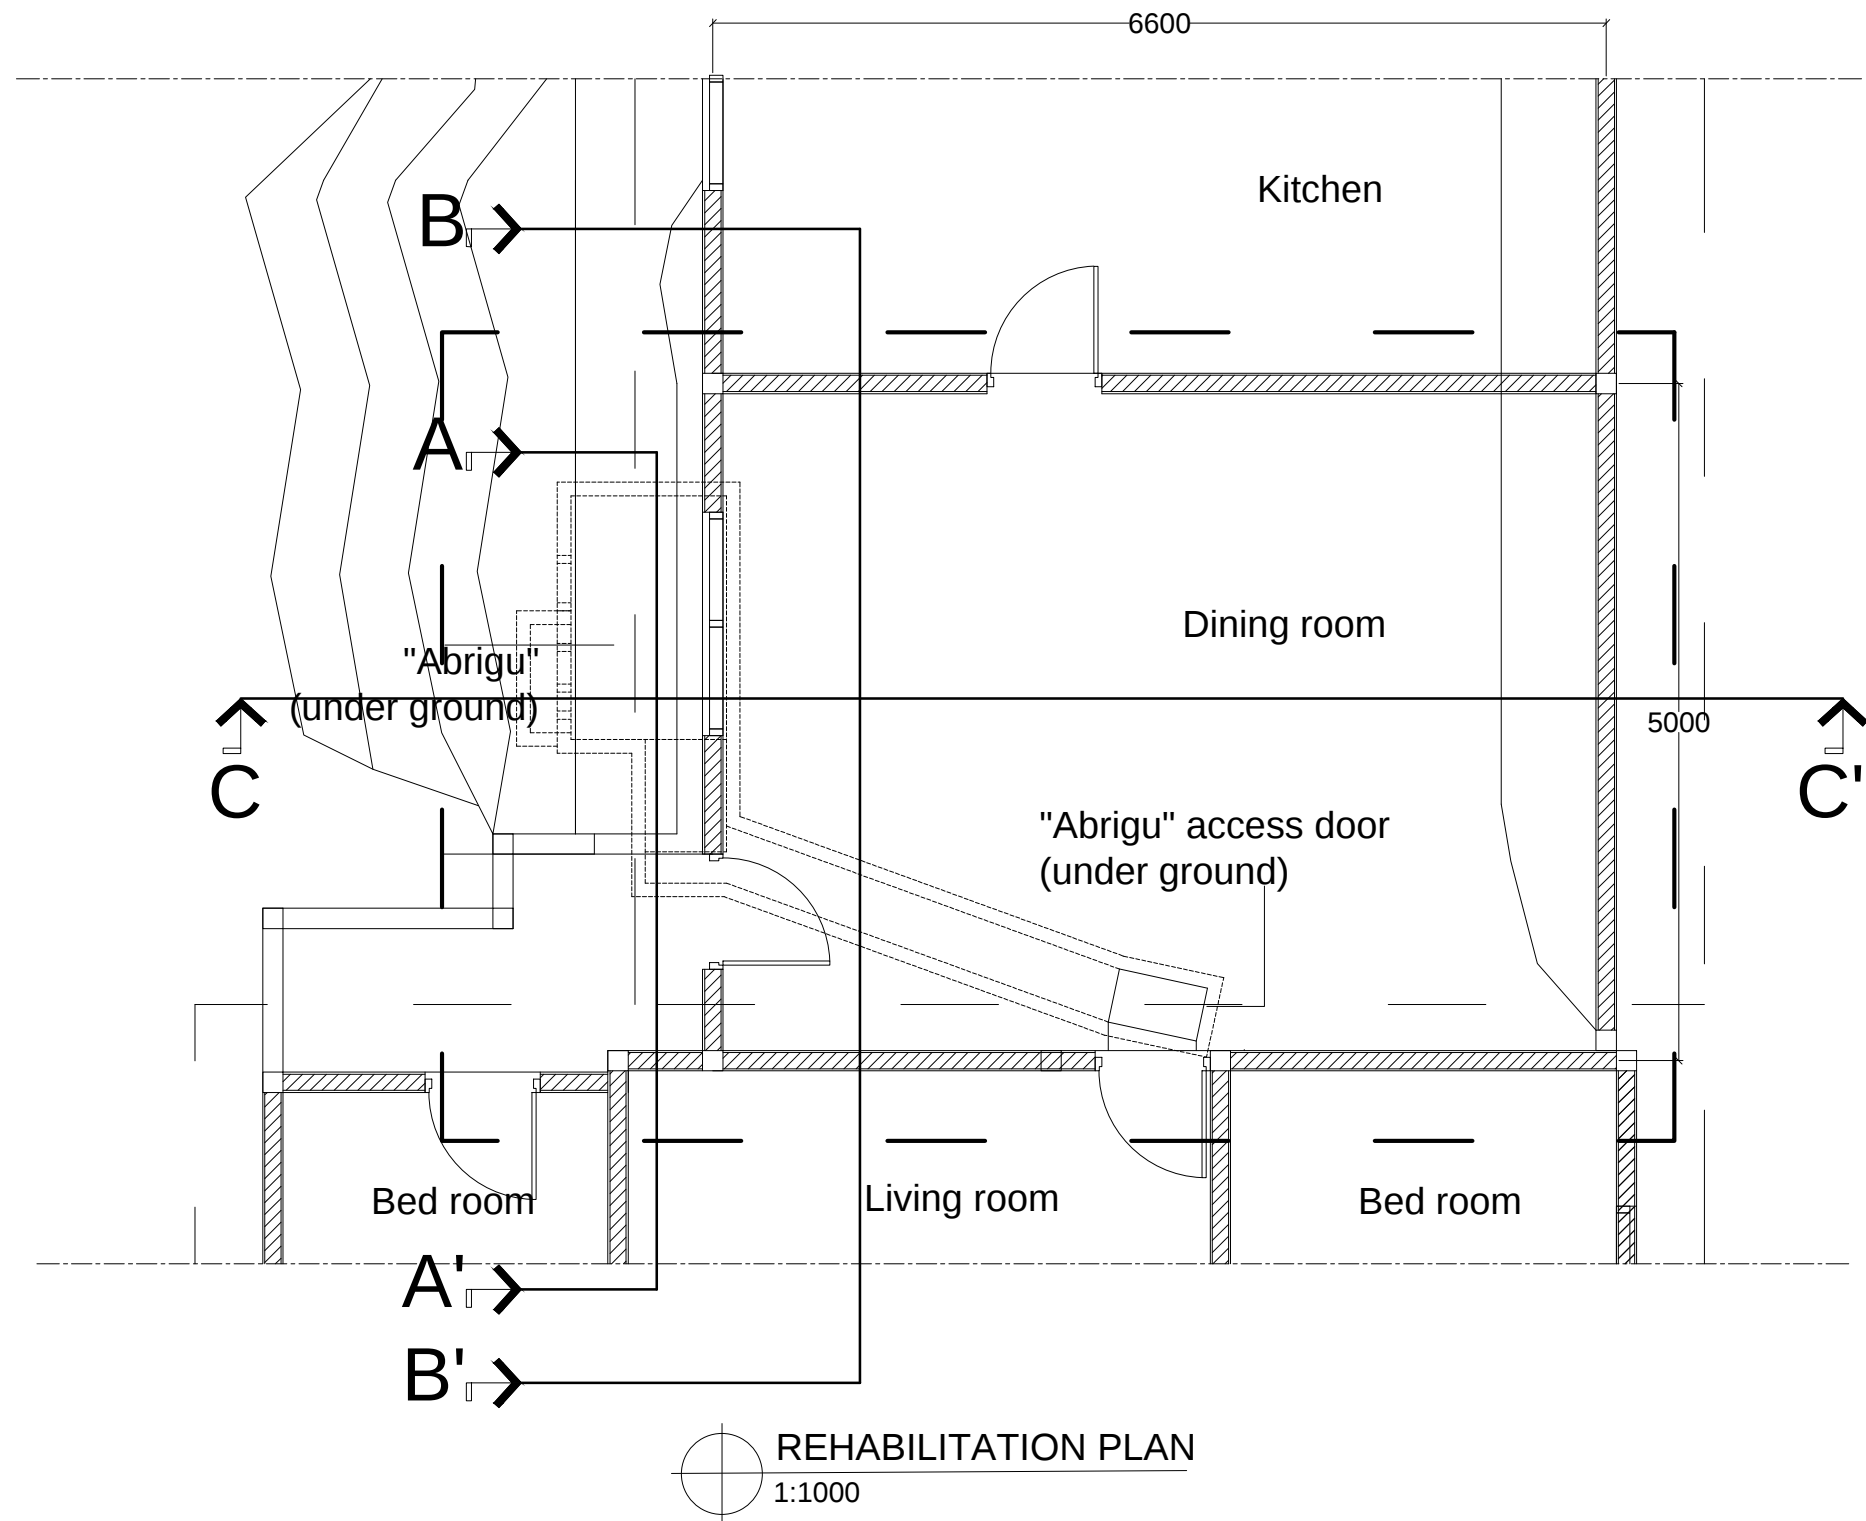



CLIENT / PROJECT OWNER	PREPARED BY	PROJECT TITLE	DRAWING TITLE	CONSULTANT DESIGN: A3R CONSULTANT		PROJECT OWNER	DEMOCRATIC REPUBLIC OF TIMOR LESTE MINISTRY OF PUBLIC WORK, TRANSPORT AND COMMUNICATION GENERAL DIRECTORATE OF PUBLIC WORKS NATIONAL DIRECTORATE OF BUILDING				SHEET NO:	
 ARQUIVO & MUSEU RESISTÊNCIA TIMORENSE INSTITUTO PÚBLICO REPÚBLICA DEMOCRÁTICA DE TIMOR LESTE Avenida Cidade de Lisboa, Dili, Timor Leste Phone: +670 - 77305782	 ANGEL'AQUIRA Consultancy, Unipessoal Lda. Architectural & Engineering Design, Supervision and Project Management Vila Verde, Dili, Timor - Leste, Phone: +670 - 7238140 E-mail: ino_neves@yahoo.com	REHABILITAÇÃO DE ABRIGOS DA RESISTÊNCIA ABRIGU FATU META FATU META, DILI TIMOR LESTE	REHABILITATION PLAN	DRAWING BY:	APPROVED BY:	APPROVED BY:		VERIFIED BY:	DATE	APPROVED BY:	DATE	04 OF 29
				Arch. Aquilino F. das Neves	Eng. Jesuino J.X. Neves	Sr. Hamar Antoninho Baptista Alves Director e Presidente AMRT		Eng. Octavio P. Marques, M.Eng. HEAD OF PROJECT DEPARTMENT	Arch. Rosa Amaral Vong Directress of DNE			
				DATE :	DATE :	DATE :	LOCATION : DILI		SCALE : 1:1000	DRAWING NO:		ARCH 04 OF 29

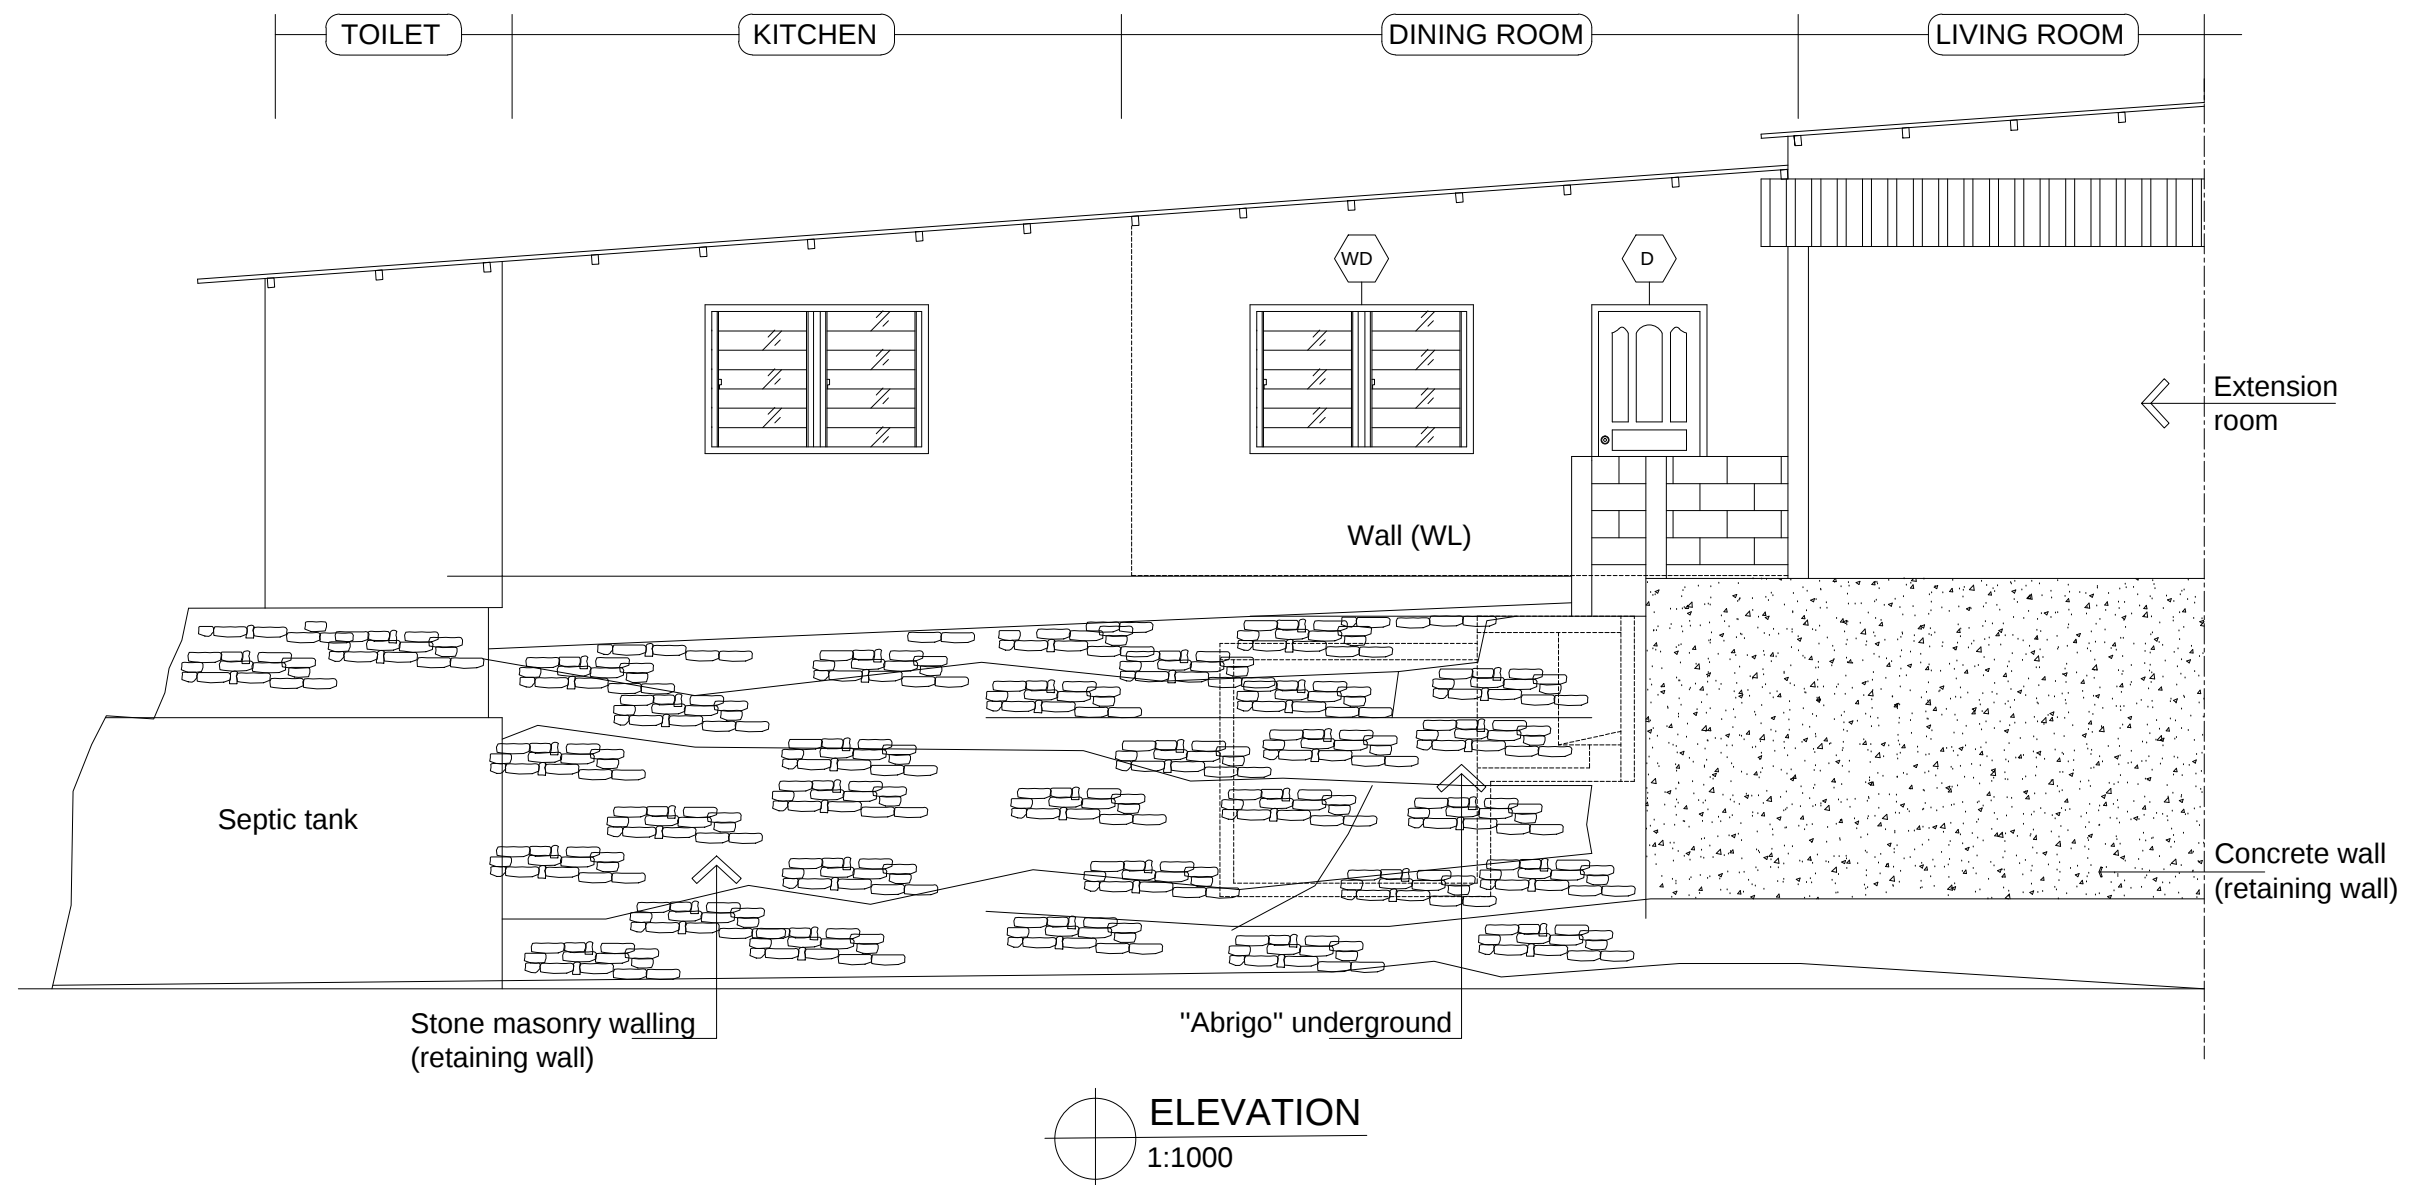


CLIENT / PROJECT OWNER	PREPARED BY	PROJECT TITLE	DRAWING TITLE	CONSULTANT DESIGN: A3R CONSULTANT		PROJECT OWNER	DEMOCRATIC REPUBLIC OF TIMOR LESTE MINISTRY OF PUBLIC WORK, TRANSPORT AND COMMUNICATION GENERAL DIRECTORATE OF PUBLIC WORKS NATIONAL DIRECTORATE OF BUILDING				SHEET NO:						
 ARQUIVO & MUSEU RESISTÊNCIA TIMORENSE INSTITUTO PÚBLICO REPÚBLICA DEMOCRÁTICA DE TIMOR LESTE Avenida Cidade de Lisboa, Dili, Timor Leste Phone: +670 - 77305782	 ANGEL'AQUIRA Consultant, Unipessoal Lda. Architectural & Engineering Design, Supervision and Project Management Vila Verde, Dili, Timor - Leste, Phone: +670 - 7238140 E-mail: ino_neves@yahoo.com	REHABILITAÇÃO DE ABRIGUS DA RESISTÊNCIA	ELEVATION	DRAWING BY:	APPROVED BY:	APPROVED BY:		VERIFIED BY:		DATE		APPROVED BY:		DATE		05 OF 29	
		ABRIGU FATU META															
		FATU META, DILI TIMOR LESTE		Arch. Aquilino F. das Neves	Eng. Jesuino J.X. Neves	Sr. Hamar Antoninho Baptista Alves Director e Presidente AMRT											
		LOCATION : DILI	SCALE : 1:1000	DATE :	DATE :	DATE :											

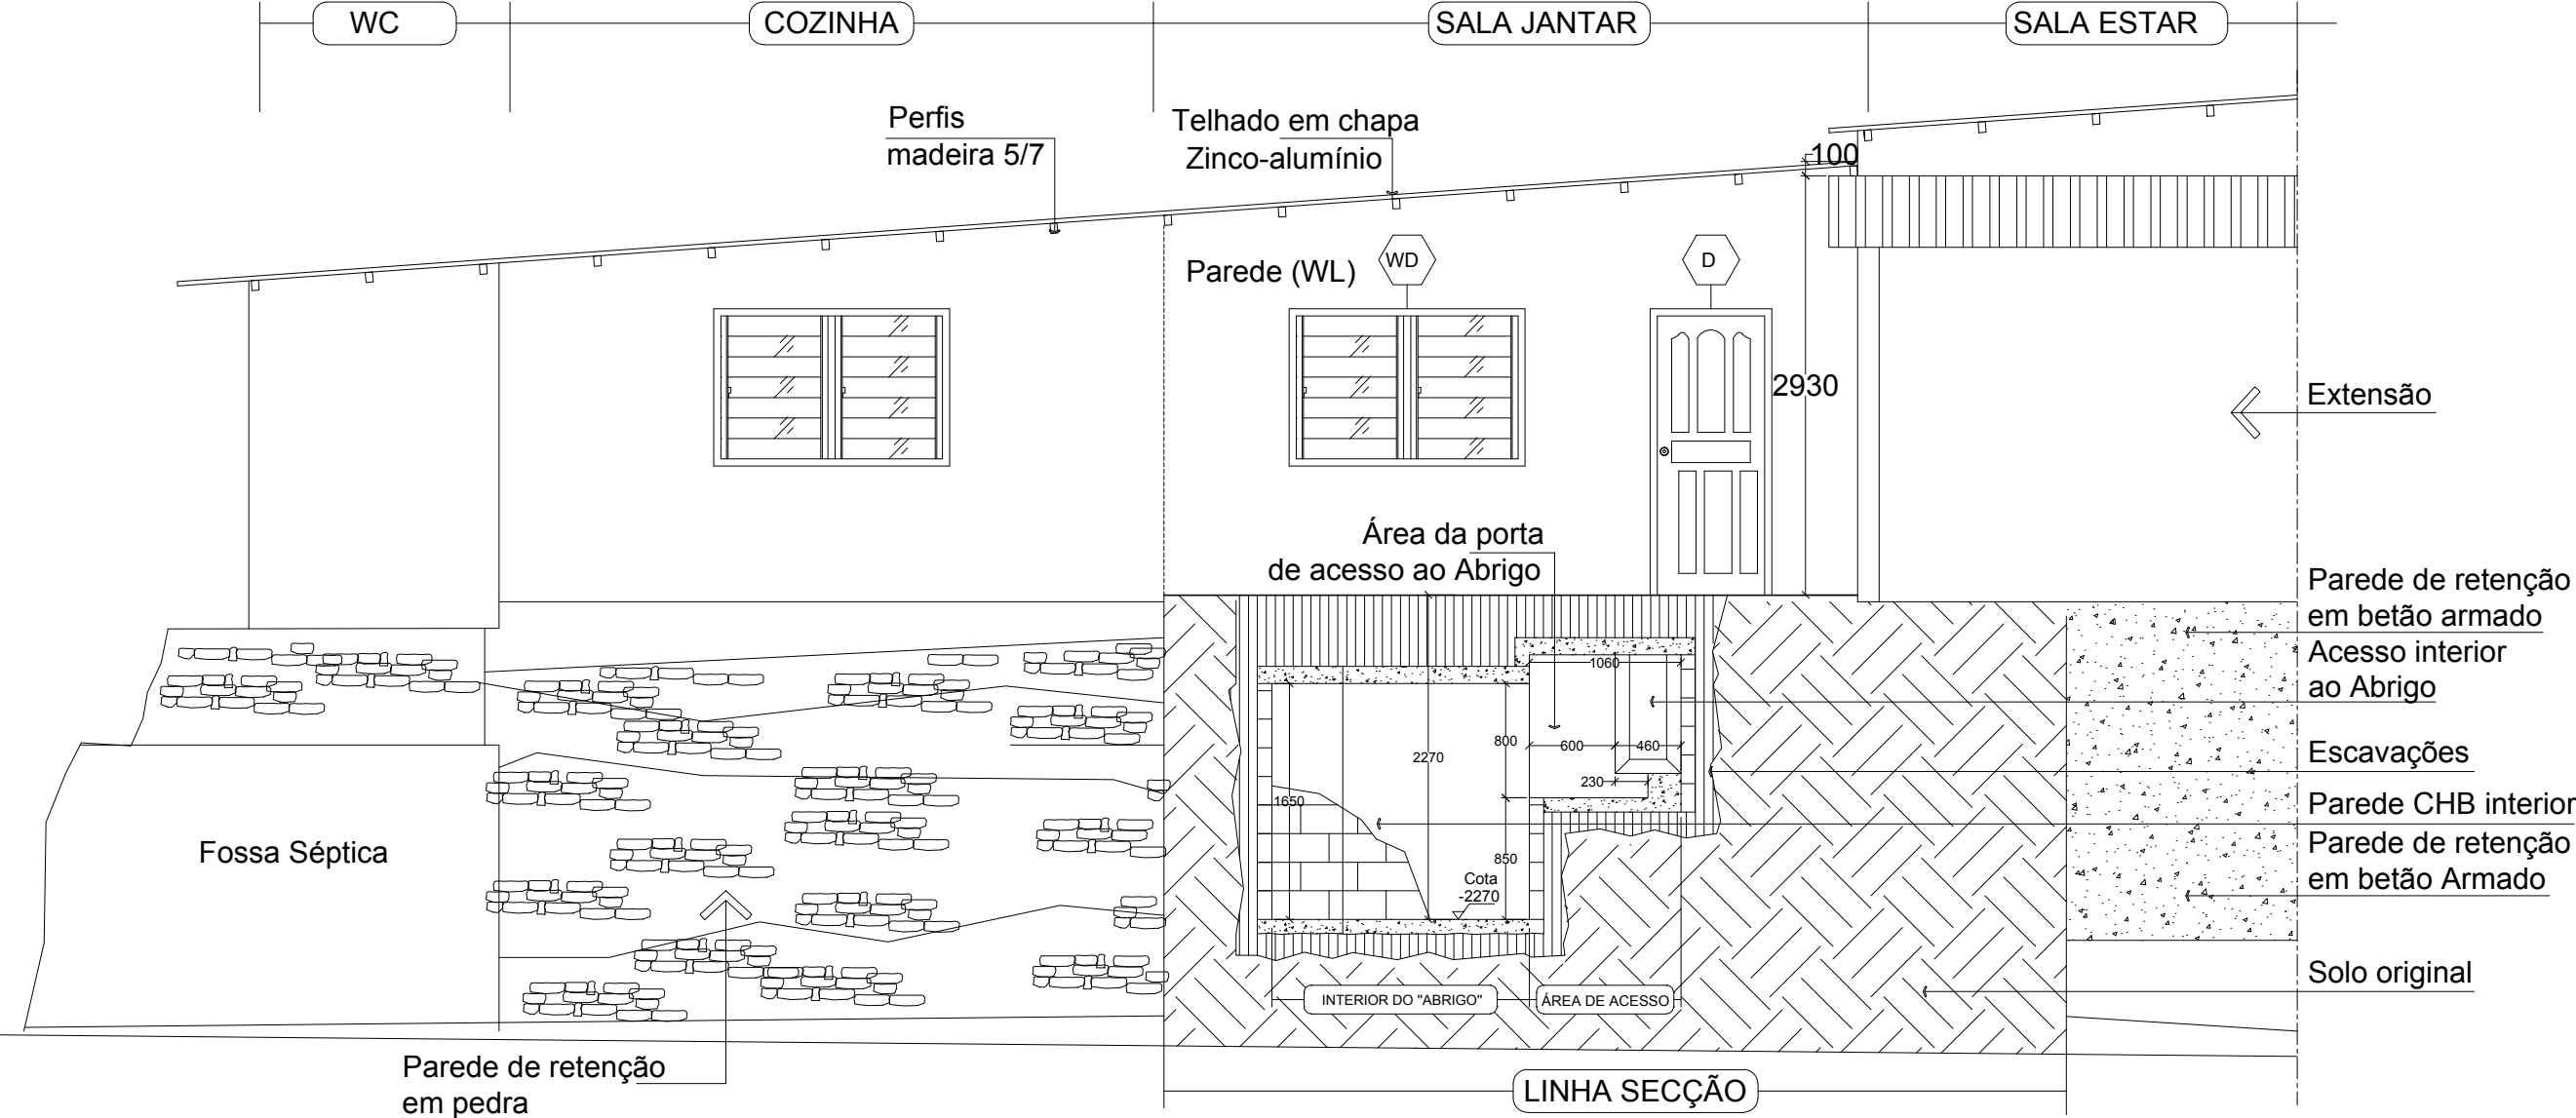

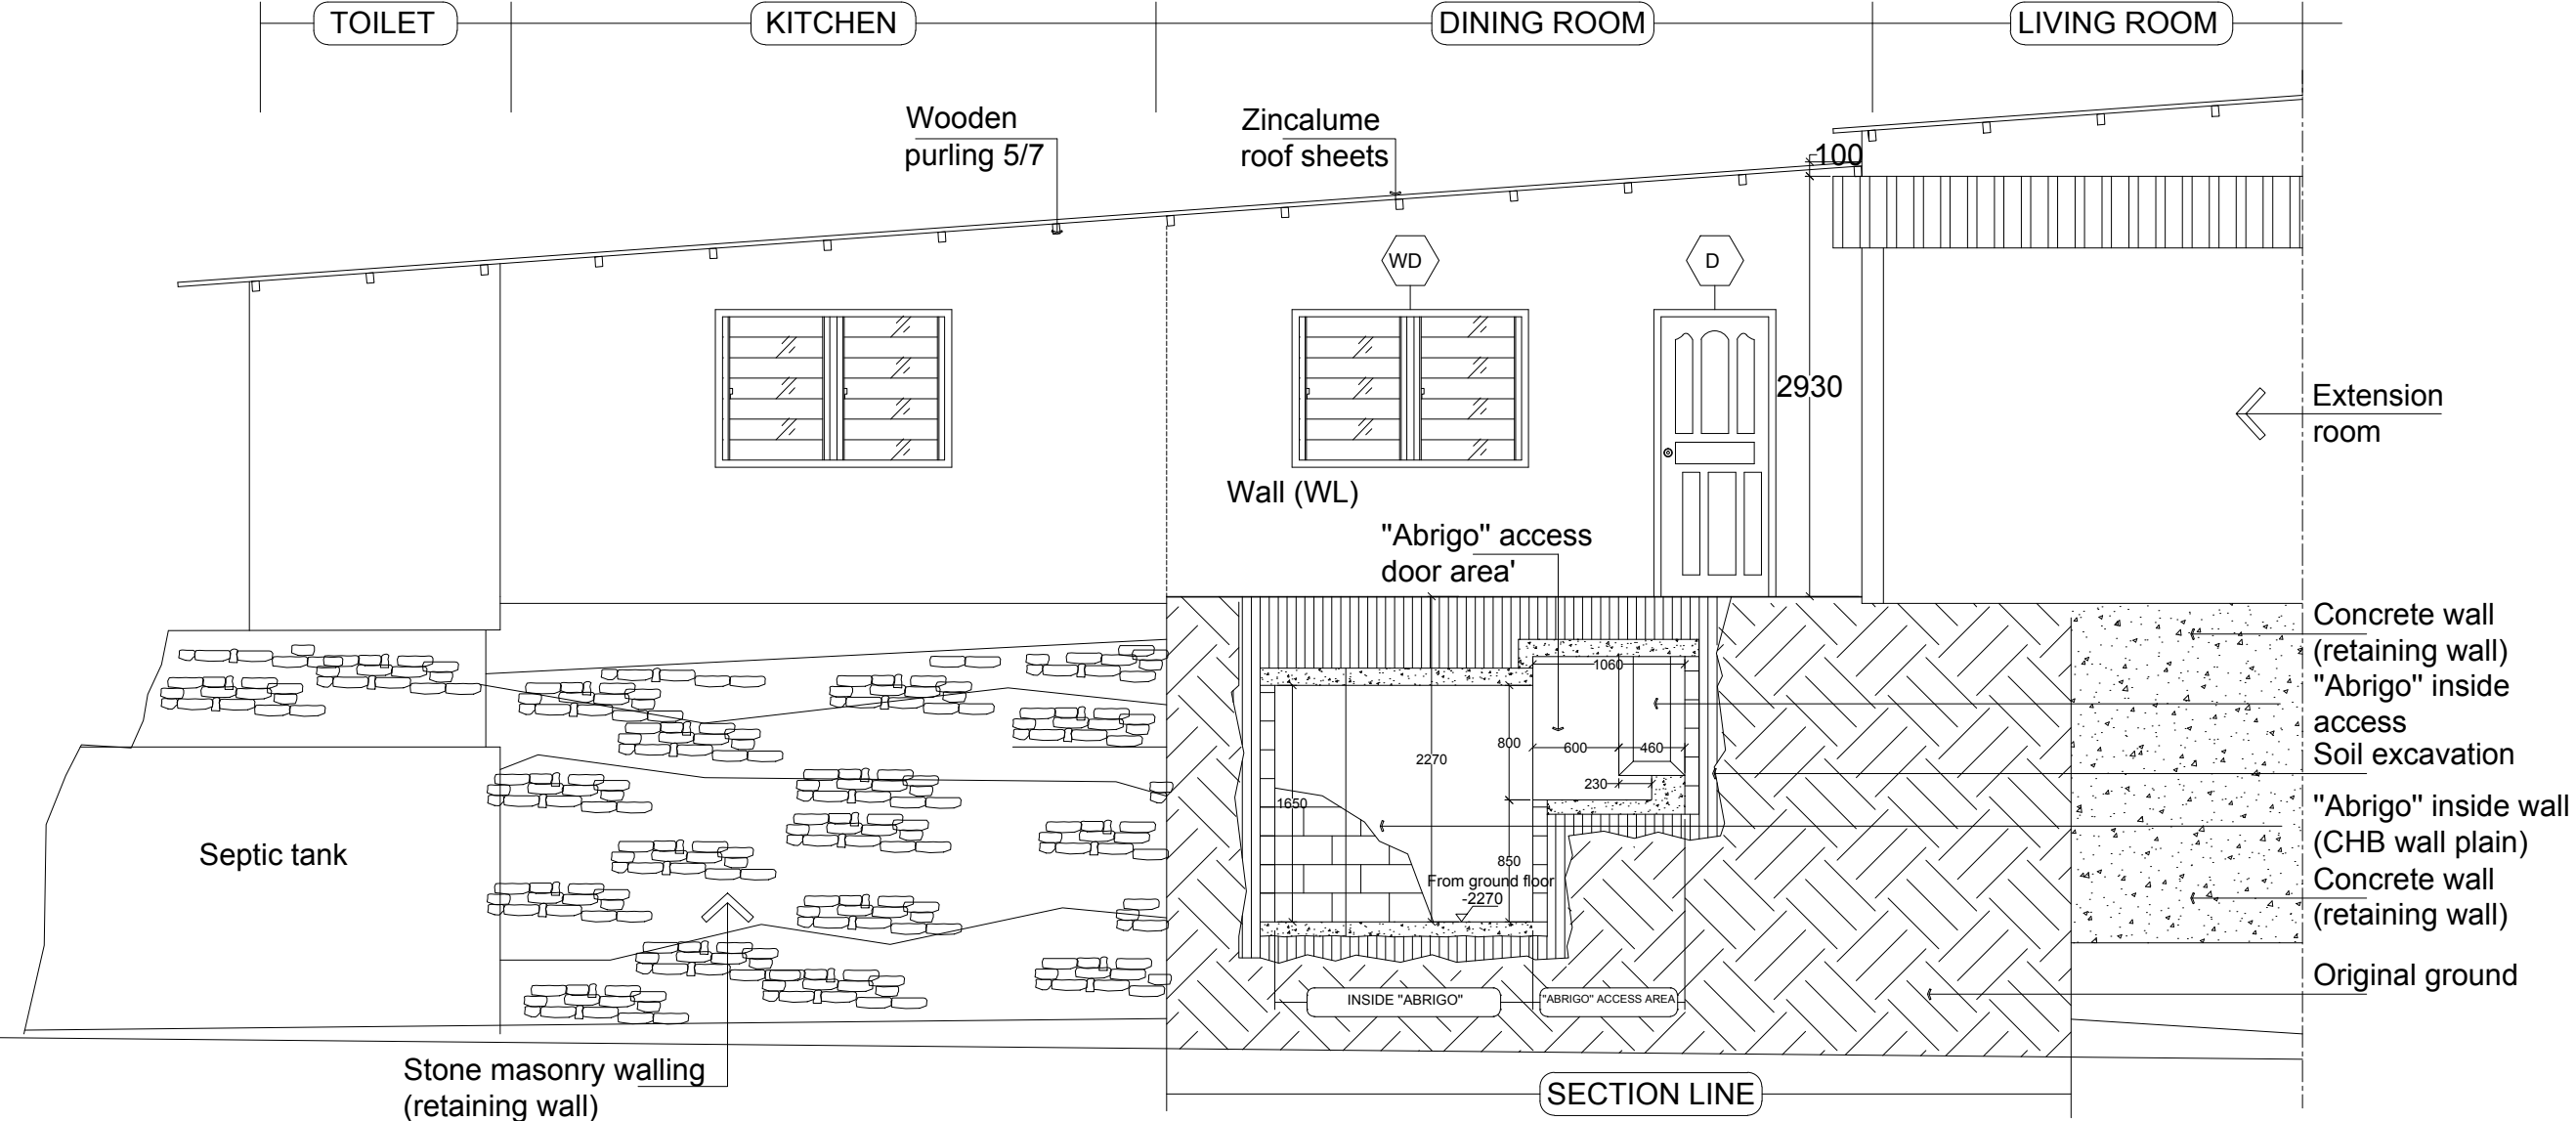


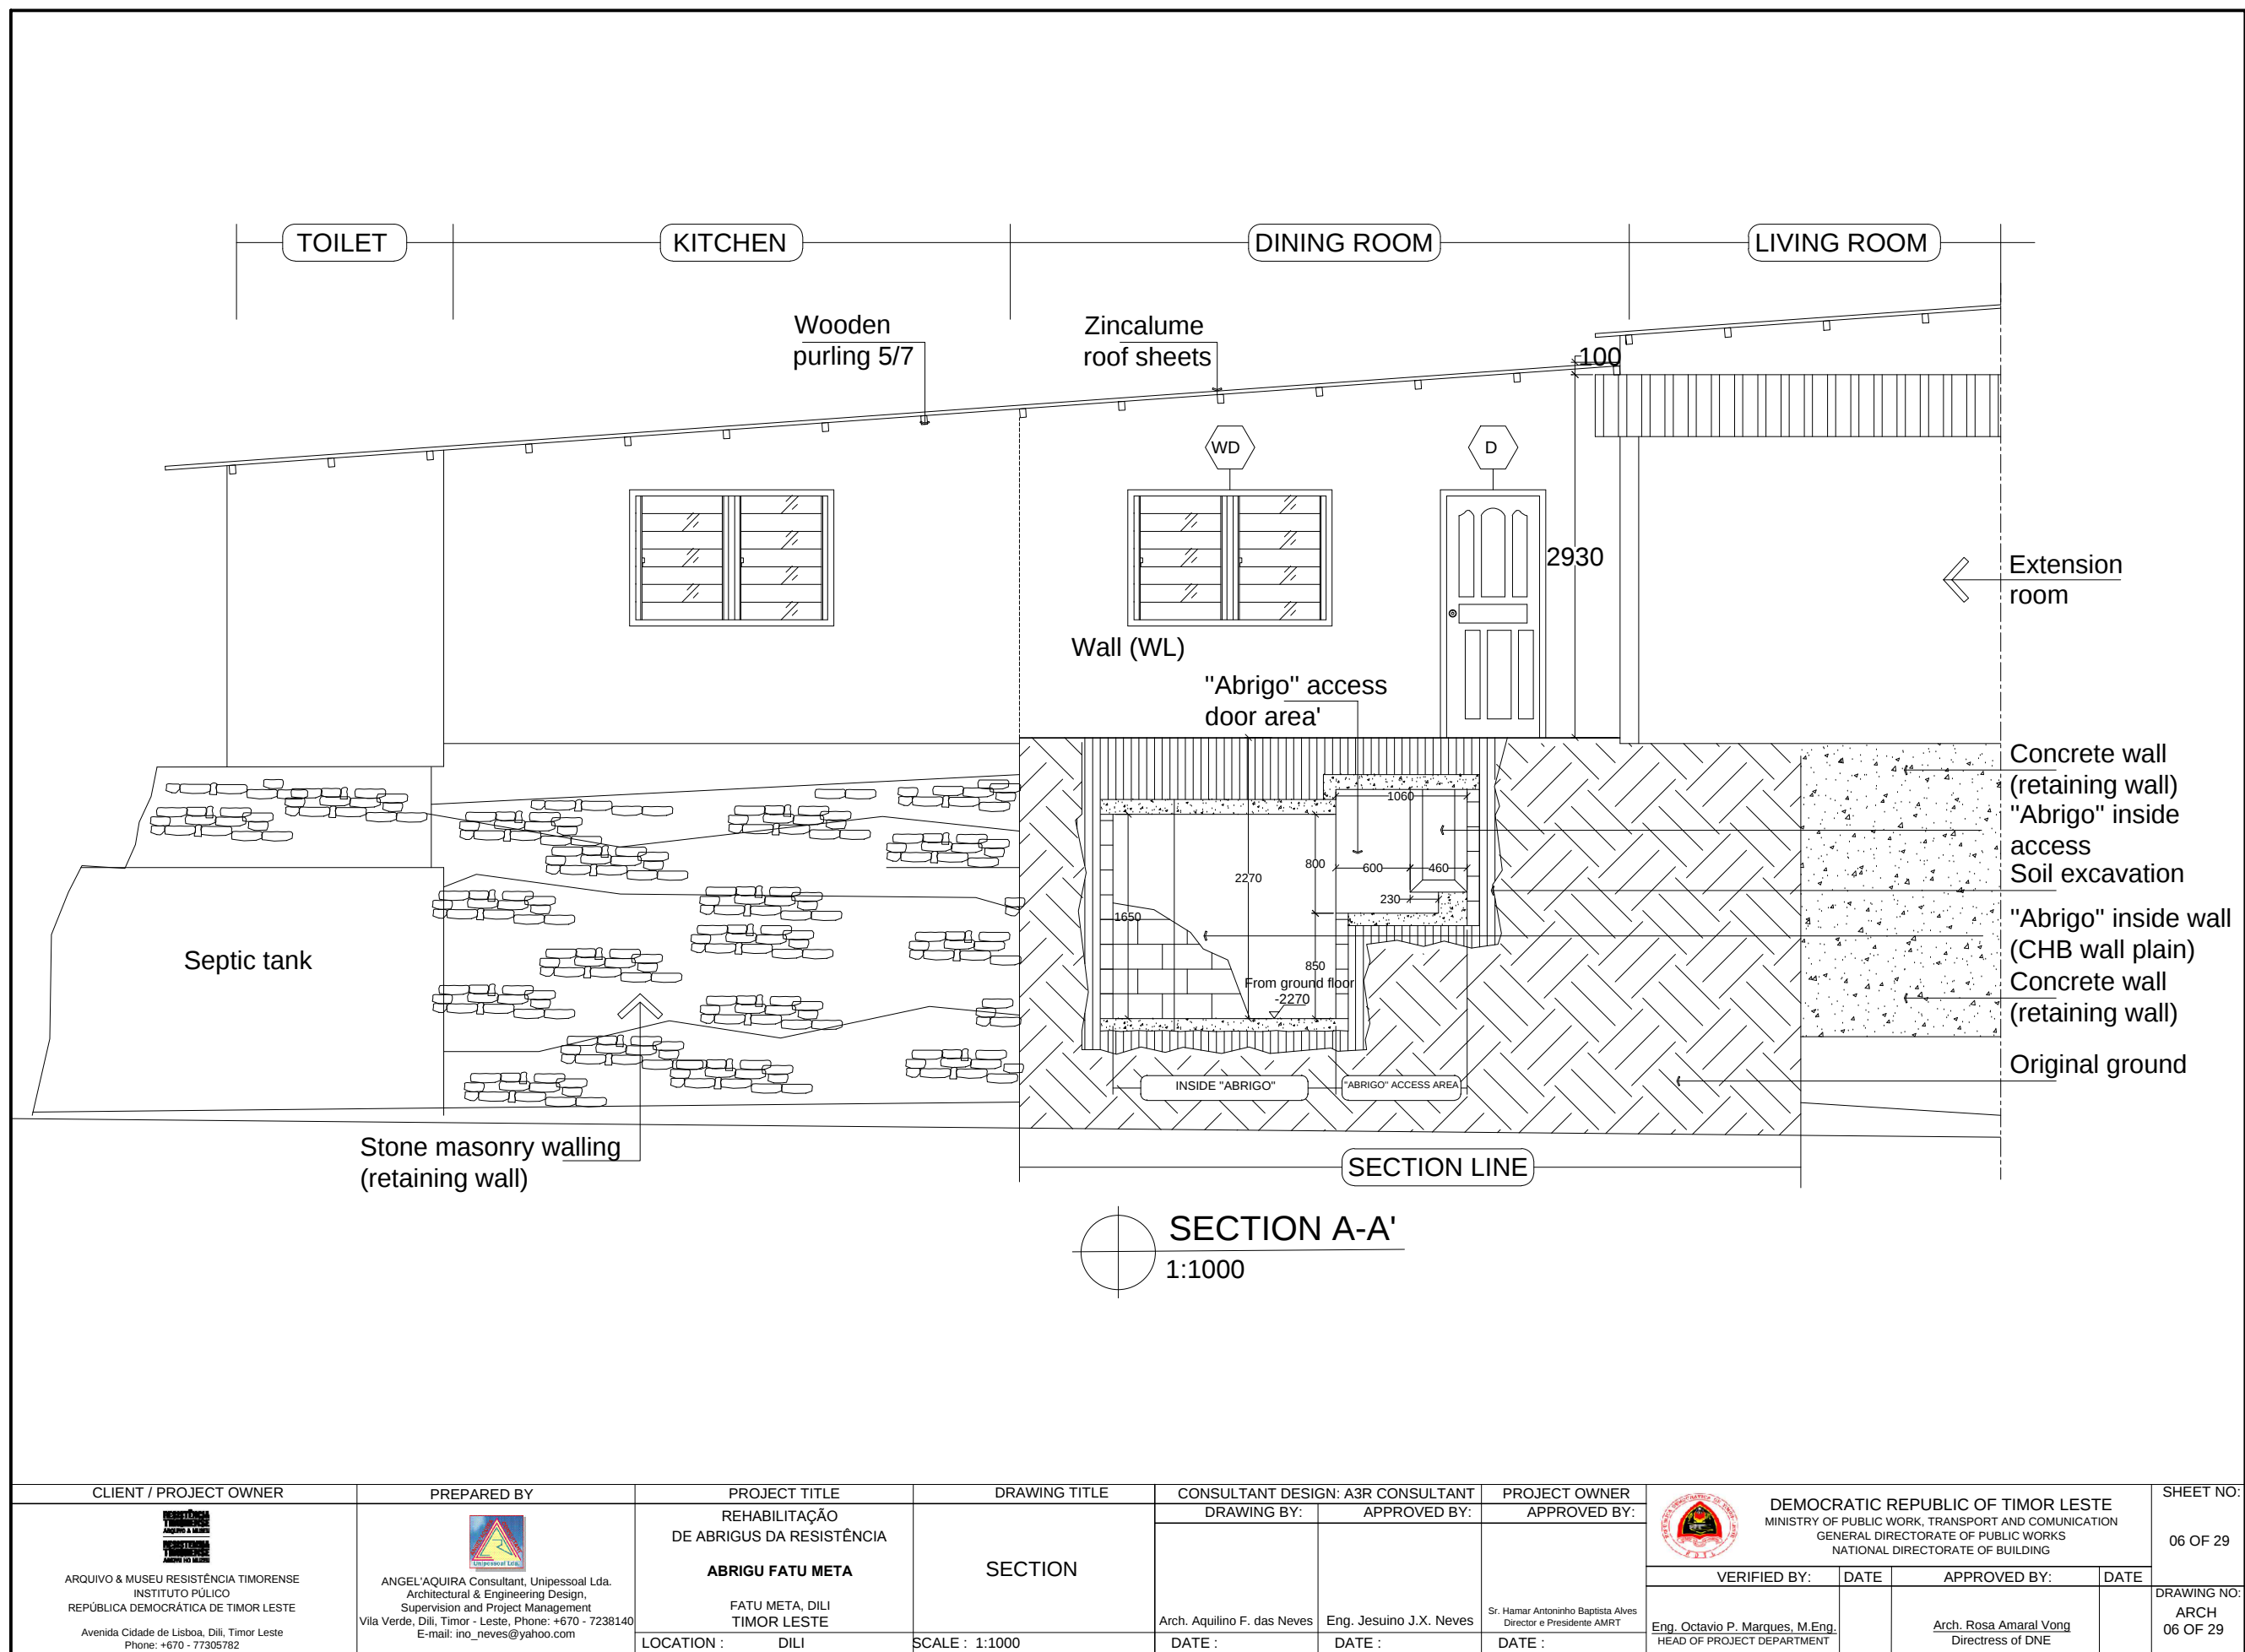



CLIENT / PROJECT OWNER  ARQUIVO & MUSEU RESISTÊNCIA TIMORENSE INSTITUTO PÚBLICO REPÚBLICA DEMOCRÁTICA DE TIMOR LESTE Avenida Cidade de Lisboa, Dili, Timor Leste Phone: +670 - 77305782	PREPARED BY  ANGEL'AQUIRA Consultant, Unipessoal Lda. Architectural & Engineering Design, Supervision and Project Management Vila Verde, Dili, Timor - Leste, Phone: +670 - 7238140 E-mail: ino_neves@yahoo.com	PROJECT TITLE REHABILITAÇÃO DE ABRIGOS DA RESISTÊNCIA ABRIGU FATU META FATU META, DILI TIMOR LESTE LOCATION : DILI	DRAWING TITLE SECTION SCALE : 1:1000	CONSULTANT DESIGN: A3R CONSULTANT		PROJECT OWNER APPROVED BY: Sr. Hamar Antoninho Baptista Alves Director e Presidente AMRT DATE :	DEMOCRATIC REPUBLIC OF TIMOR LESTE MINISTRY OF PUBLIC WORK, TRANSPORT AND COMMUNICATION GENERAL DIRECTORATE OF PUBLIC WORKS NATIONAL DIRECTORATE OF BUILDING				SHEET NO: 06 OF 29 DRAWING NO: ARCH 06 OF 29
				DRAWING BY:	APPROVED BY:		VERIFIED BY:	DATE	APPROVED BY:	DATE	
				Arch. Aquilino F. das Neves	Eng. Jesuino J.X. Neves		Eng. Octavio P. Marques, M.Eng. HEAD OF PROJECT DEPARTMENT		Arch. Rosa Amaral Vong Directress of DNE		

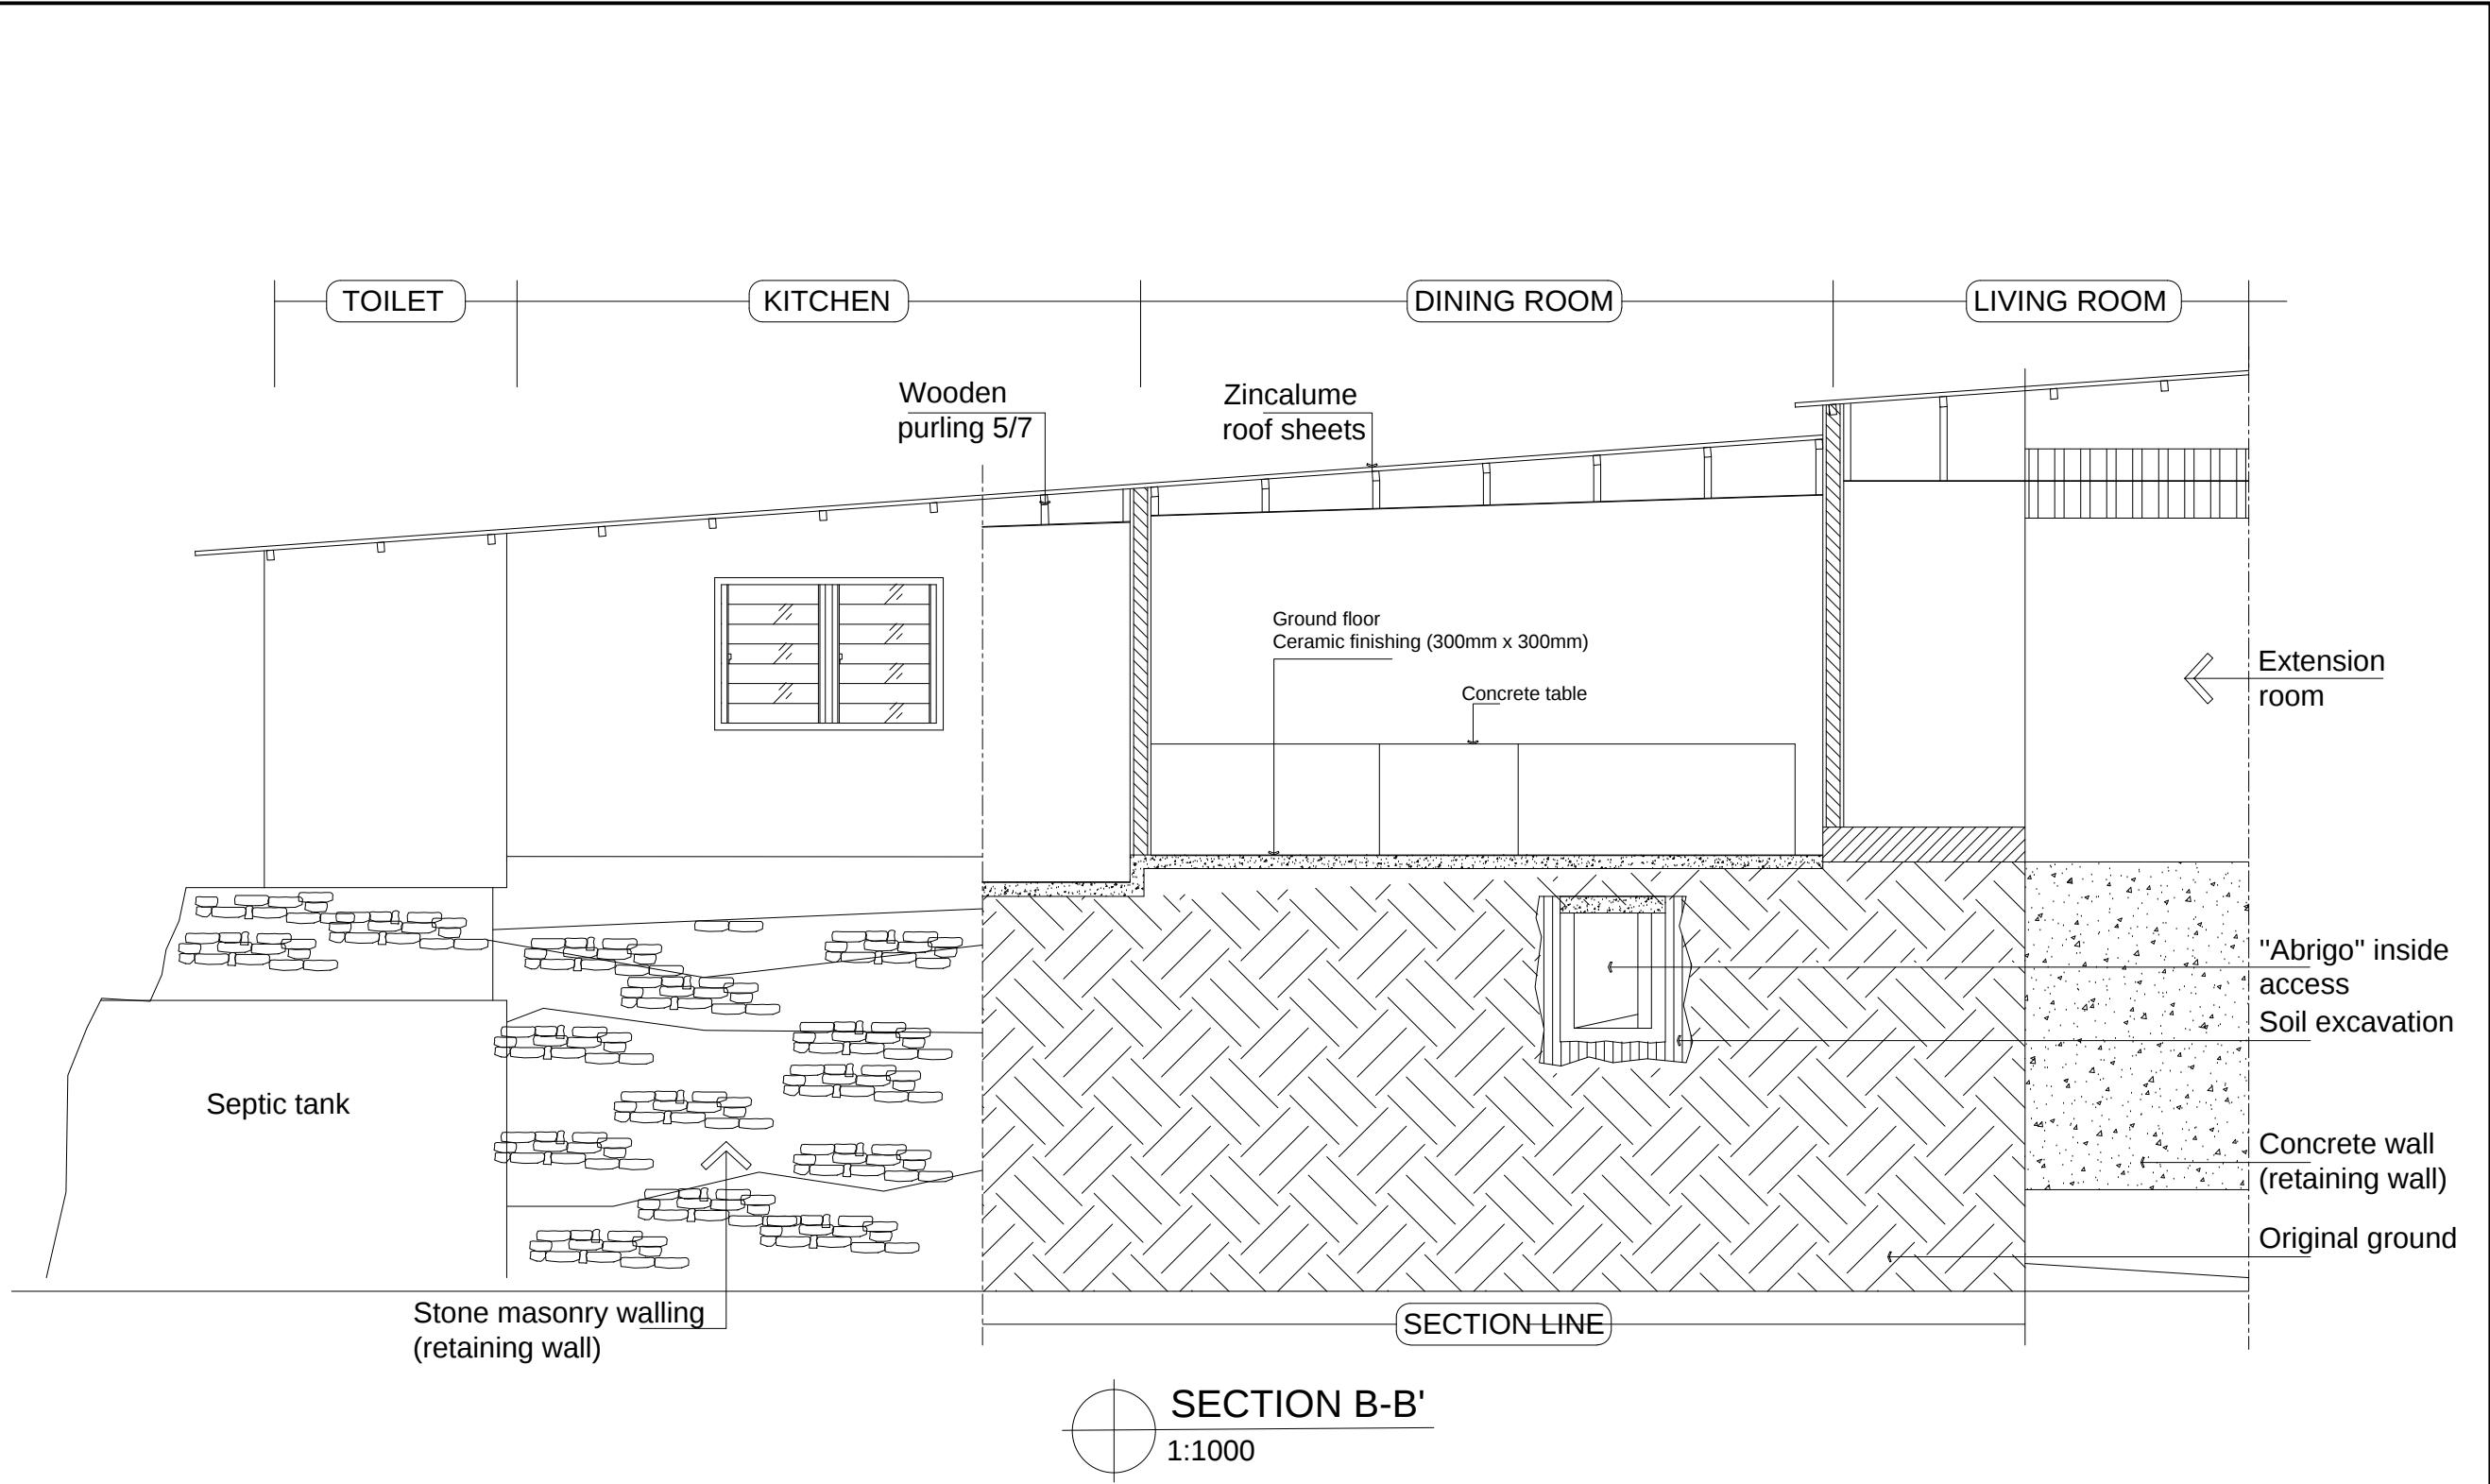


CLIENT / PROJECT OWNER		PREPARED BY	PROJECT TITLE	DRAWING TITLE	CONSULTANT DESIGN: A3R CONSULTANT		PROJECT OWNER	DEMOCRATIC REPUBLIC OF TIMOR LESTE MINISTRY OF PUBLIC WORK, TRANSPORT AND COMMUNICATION GENERAL DIRECTORATE OF PUBLIC WORKS NATIONAL DIRECTORATE OF BUILDING				SHEET NO:
 ARQUIVO & MUSEU RESISTÊNCIA TIMORENSE INSTITUTO PÚBLICO REPÚBLICA DEMOCRÁTICA DE TIMOR LESTE Avenida Cidade de Lisboa, Dili, Timor Leste Phone: +670 - 77305782		 ANGEL'AQUIRA Consultant, Unipessoal Lda. Architectural & Engineering Design, Supervision and Project Management Vila Verde, Dili, Timor - Leste, Phone: +670 - 7238140 E-mail: ino_neves@yahoo.com	REHABILITAÇÃO DE ABRIGOS DA RESISTÊNCIA ABRIGU FATU META FATU META, DILI TIMOR LESTE	SECTION	DRAWING BY:	APPROVED BY:	APPROVED BY:					07 OF 29
					Arch. Aquilino F. das Neves	Eng. Jesuino J.X. Neves	Sr. Hamar Antoninho Baptista Alves Director e Presidente AMRT	VERIFIED BY:	DATE	APPROVED BY:	DATE	DRAWING NO:
			LOCATION : DILI	SCALE : 1:1000	DATE :	DATE :	DATE :	Eng. Octavio P. Marques, M.Eng. HEAD OF PROJECT DEPARTMENT		Arch. Rosa Amaral Vong Directress of DNE		ARCH 07 OF 29

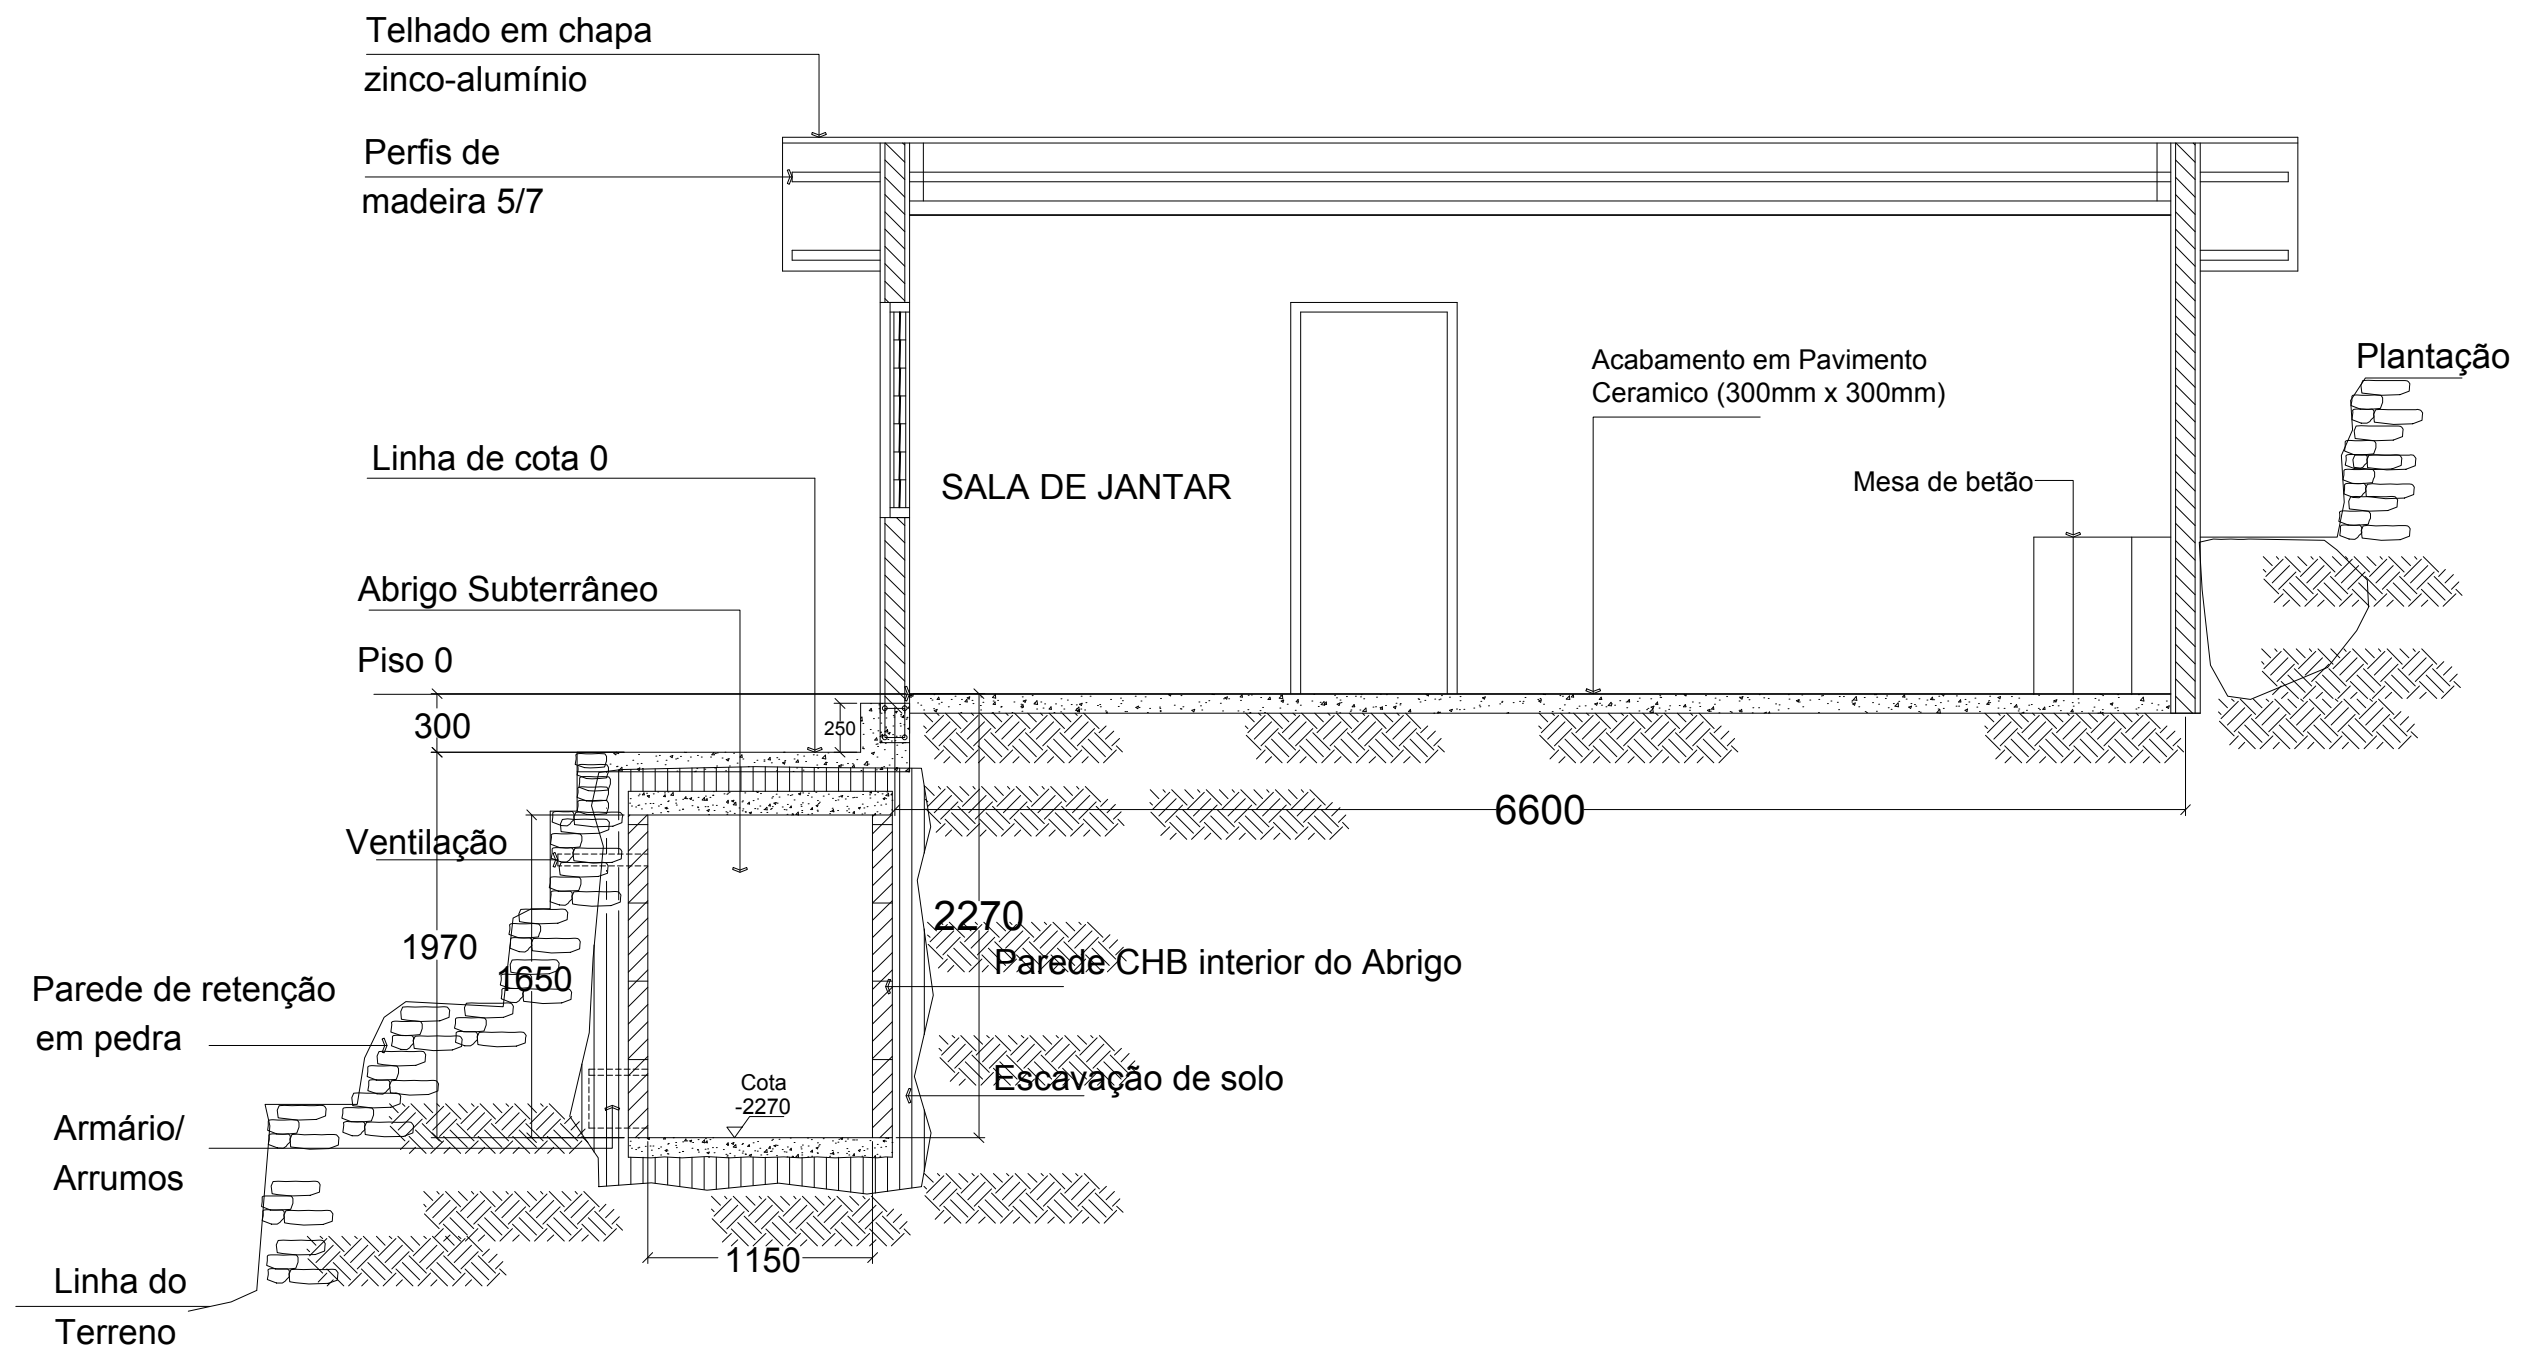


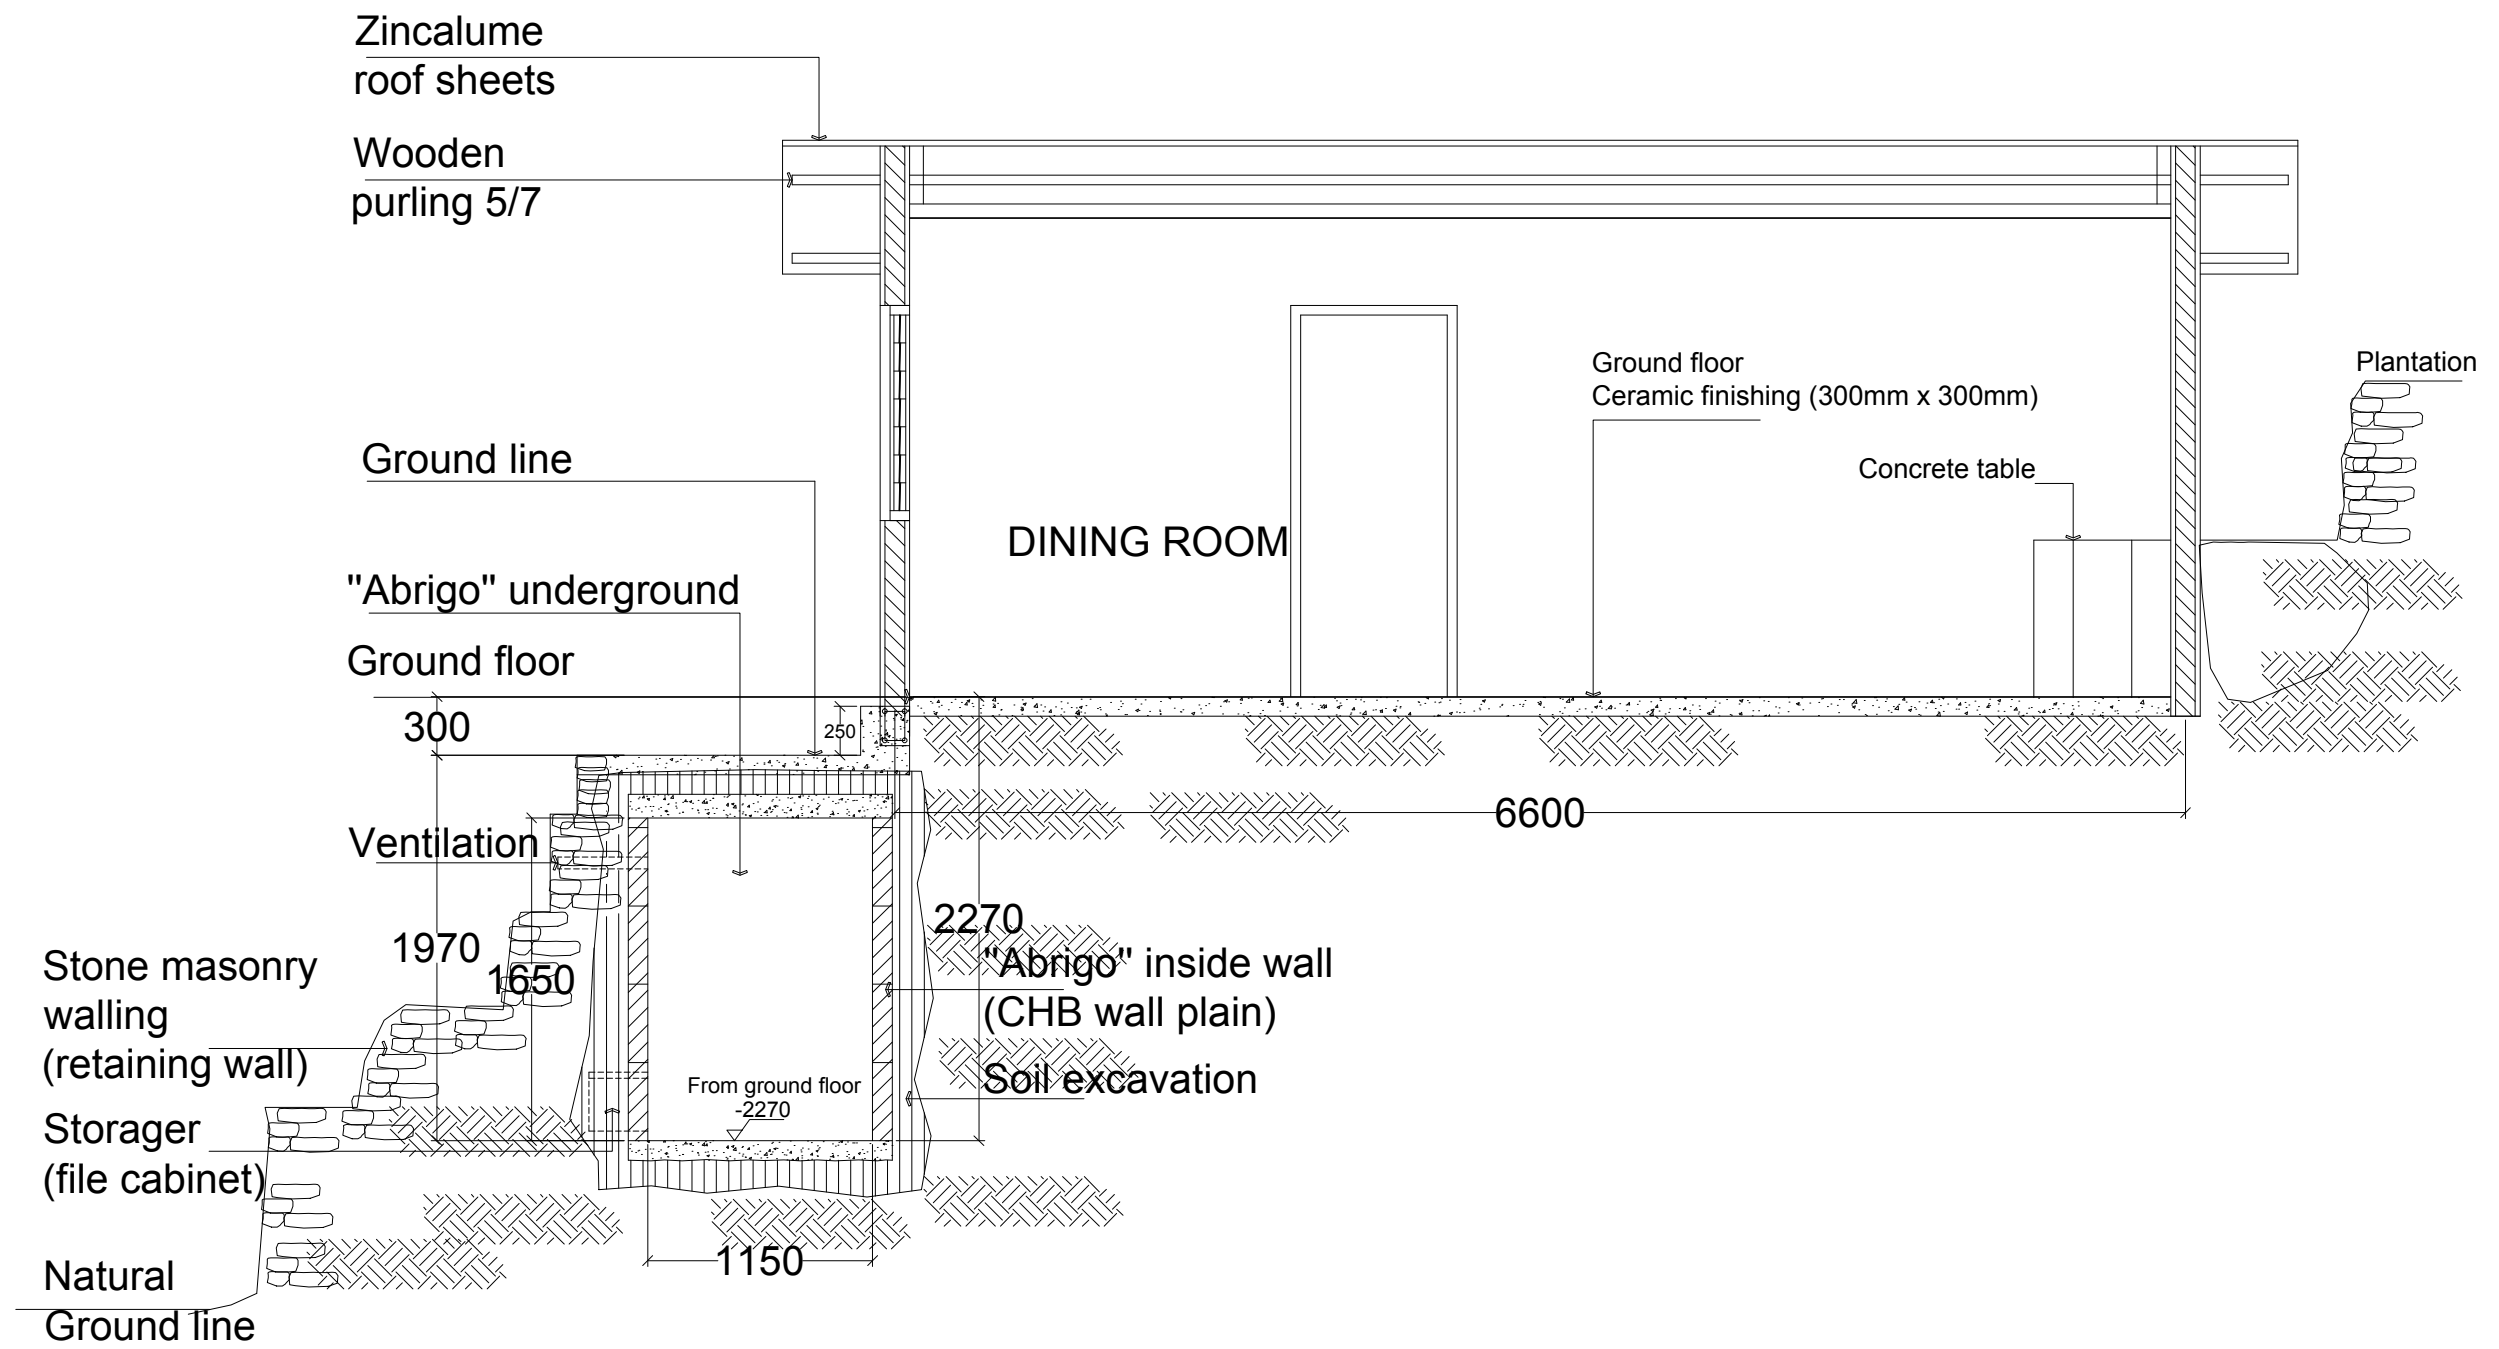


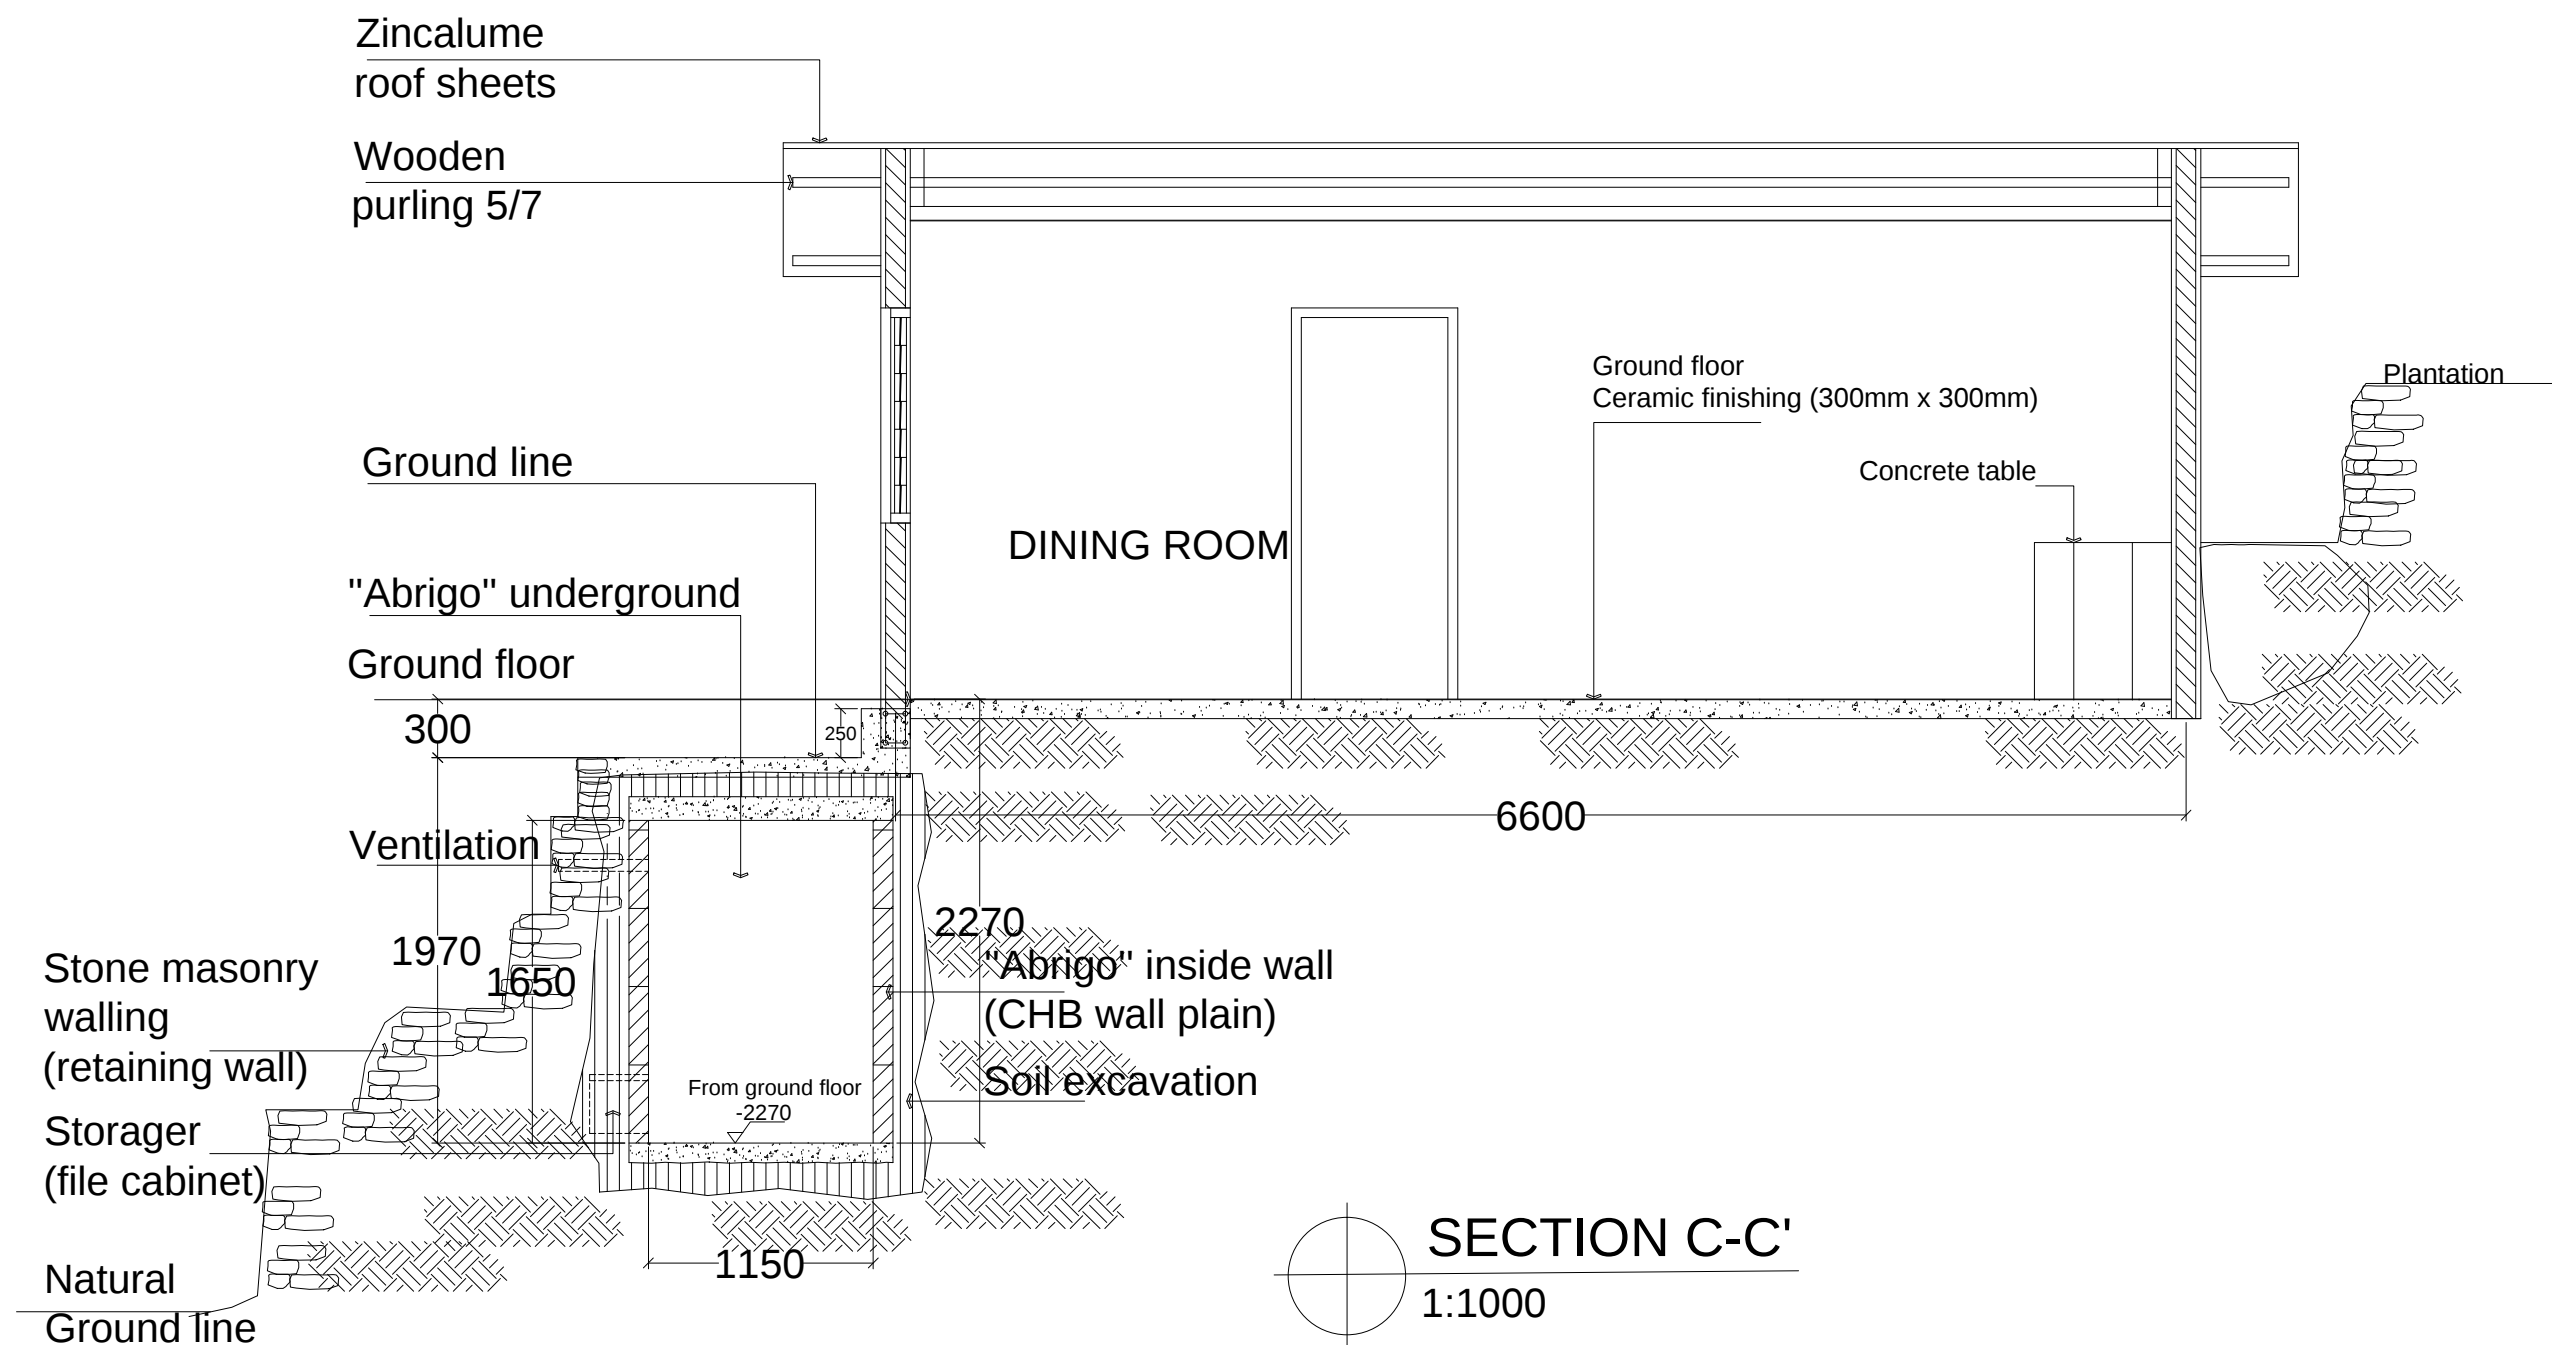


CLIENT / PROJECT OWNER	PREPARED BY	PROJECT TITLE	DRAWING TITLE	CONSULTANT DESIGN: A3R CONSULTANT		PROJECT OWNER	DEMOCRATIC REPUBLIC OF TIMOR LESTE				SHEET NO:
 ARQUIVO & MUSEU RESISTÊNCIA TIMORENSE INSTITUTO PÚBLICO REPÚBLICA DEMOCRÁTICA DE TIMOR LESTE Avenida Cidade de Lisboa, Dili, Timor Leste Phone: +670 - 77305782	 ANGEL'AQUIRA Consultant, Unipessoal Lda. Architectural & Engineering Design, Supervision and Project Management Vila Verde, Dili, Timor - Leste, Phone: +670 - 7238140 E-mail: ino_neves@yahoo.com	REHABILITAÇÃO DE ABRIGUS DA RESISTÊNCIA	SECTION	DRAWING BY:	APPROVED BY:	APPROVED BY:	 MINISTRY OF PUBLIC WORK, TRANSPORT AND COMMUNICATION GENERAL DIRECTORATE OF PUBLIC WORKS NATIONAL DIRECTORATE OF BUILDING				08 OF 29
						VERIFIED BY:	DATE	APPROVED BY:	DATE		
		Arch. Aquilino F. das Neves		Eng. Jesuino J.X. Neves	Sr. Hamar Antoninho Baptista Alves Director e Presidente AMRT	Eng. Octavio P. Marques, M.Eng. HEAD OF PROJECT DEPARTMENT		Arch. Rosa Amaral Vong Directress of DNE		DRAWING NO: ARCH 08 OF 29	
		LOCATION : DILI		SCALE : 1:1000		DATE :	DATE :	DATE :			

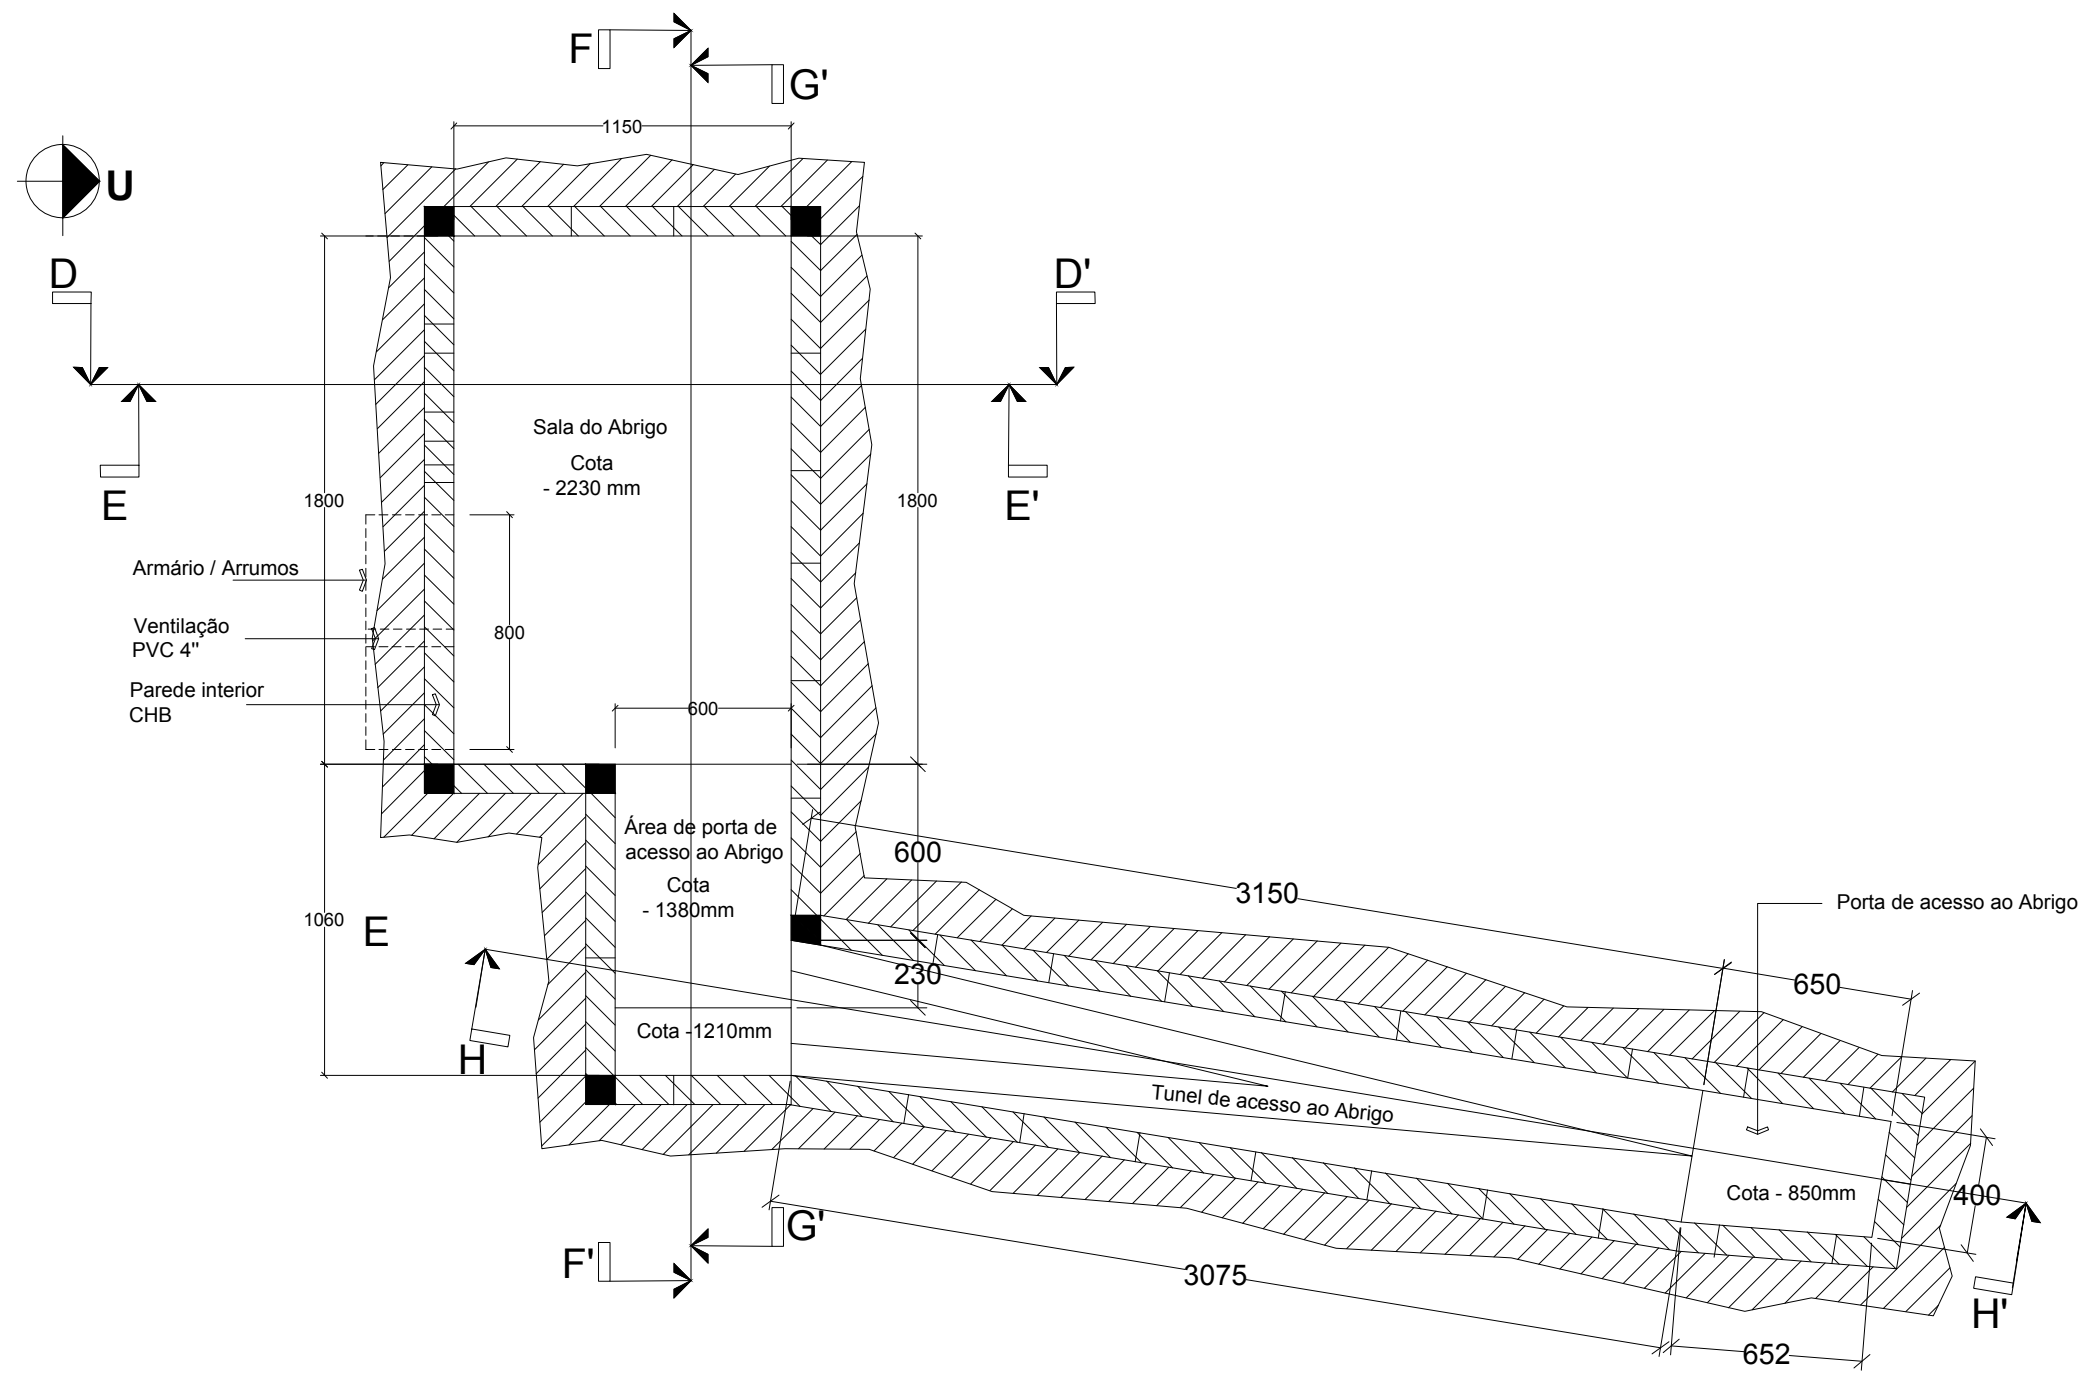

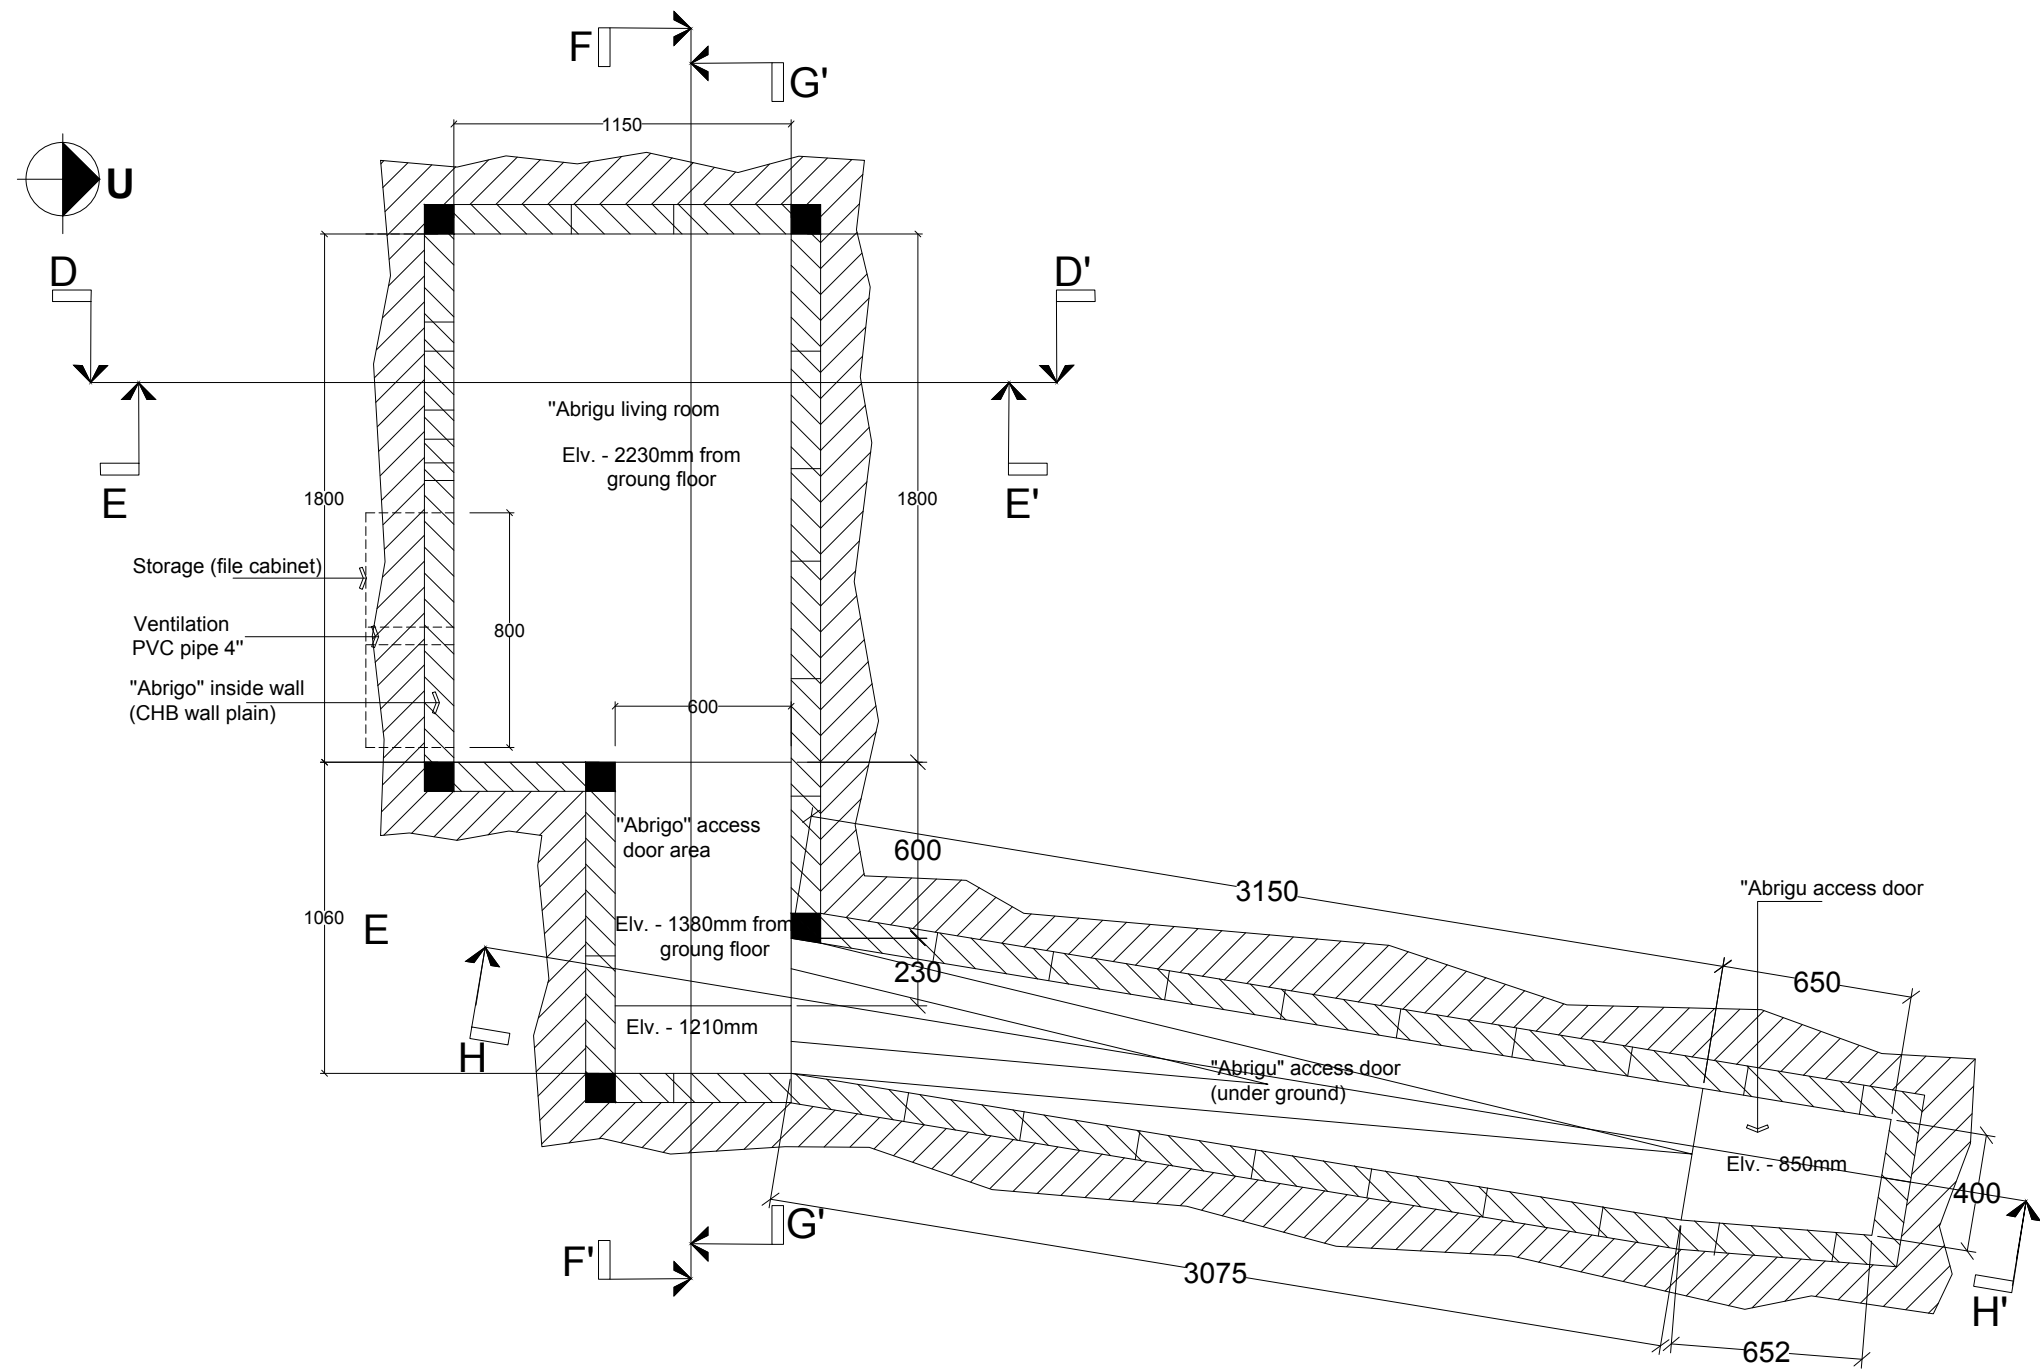


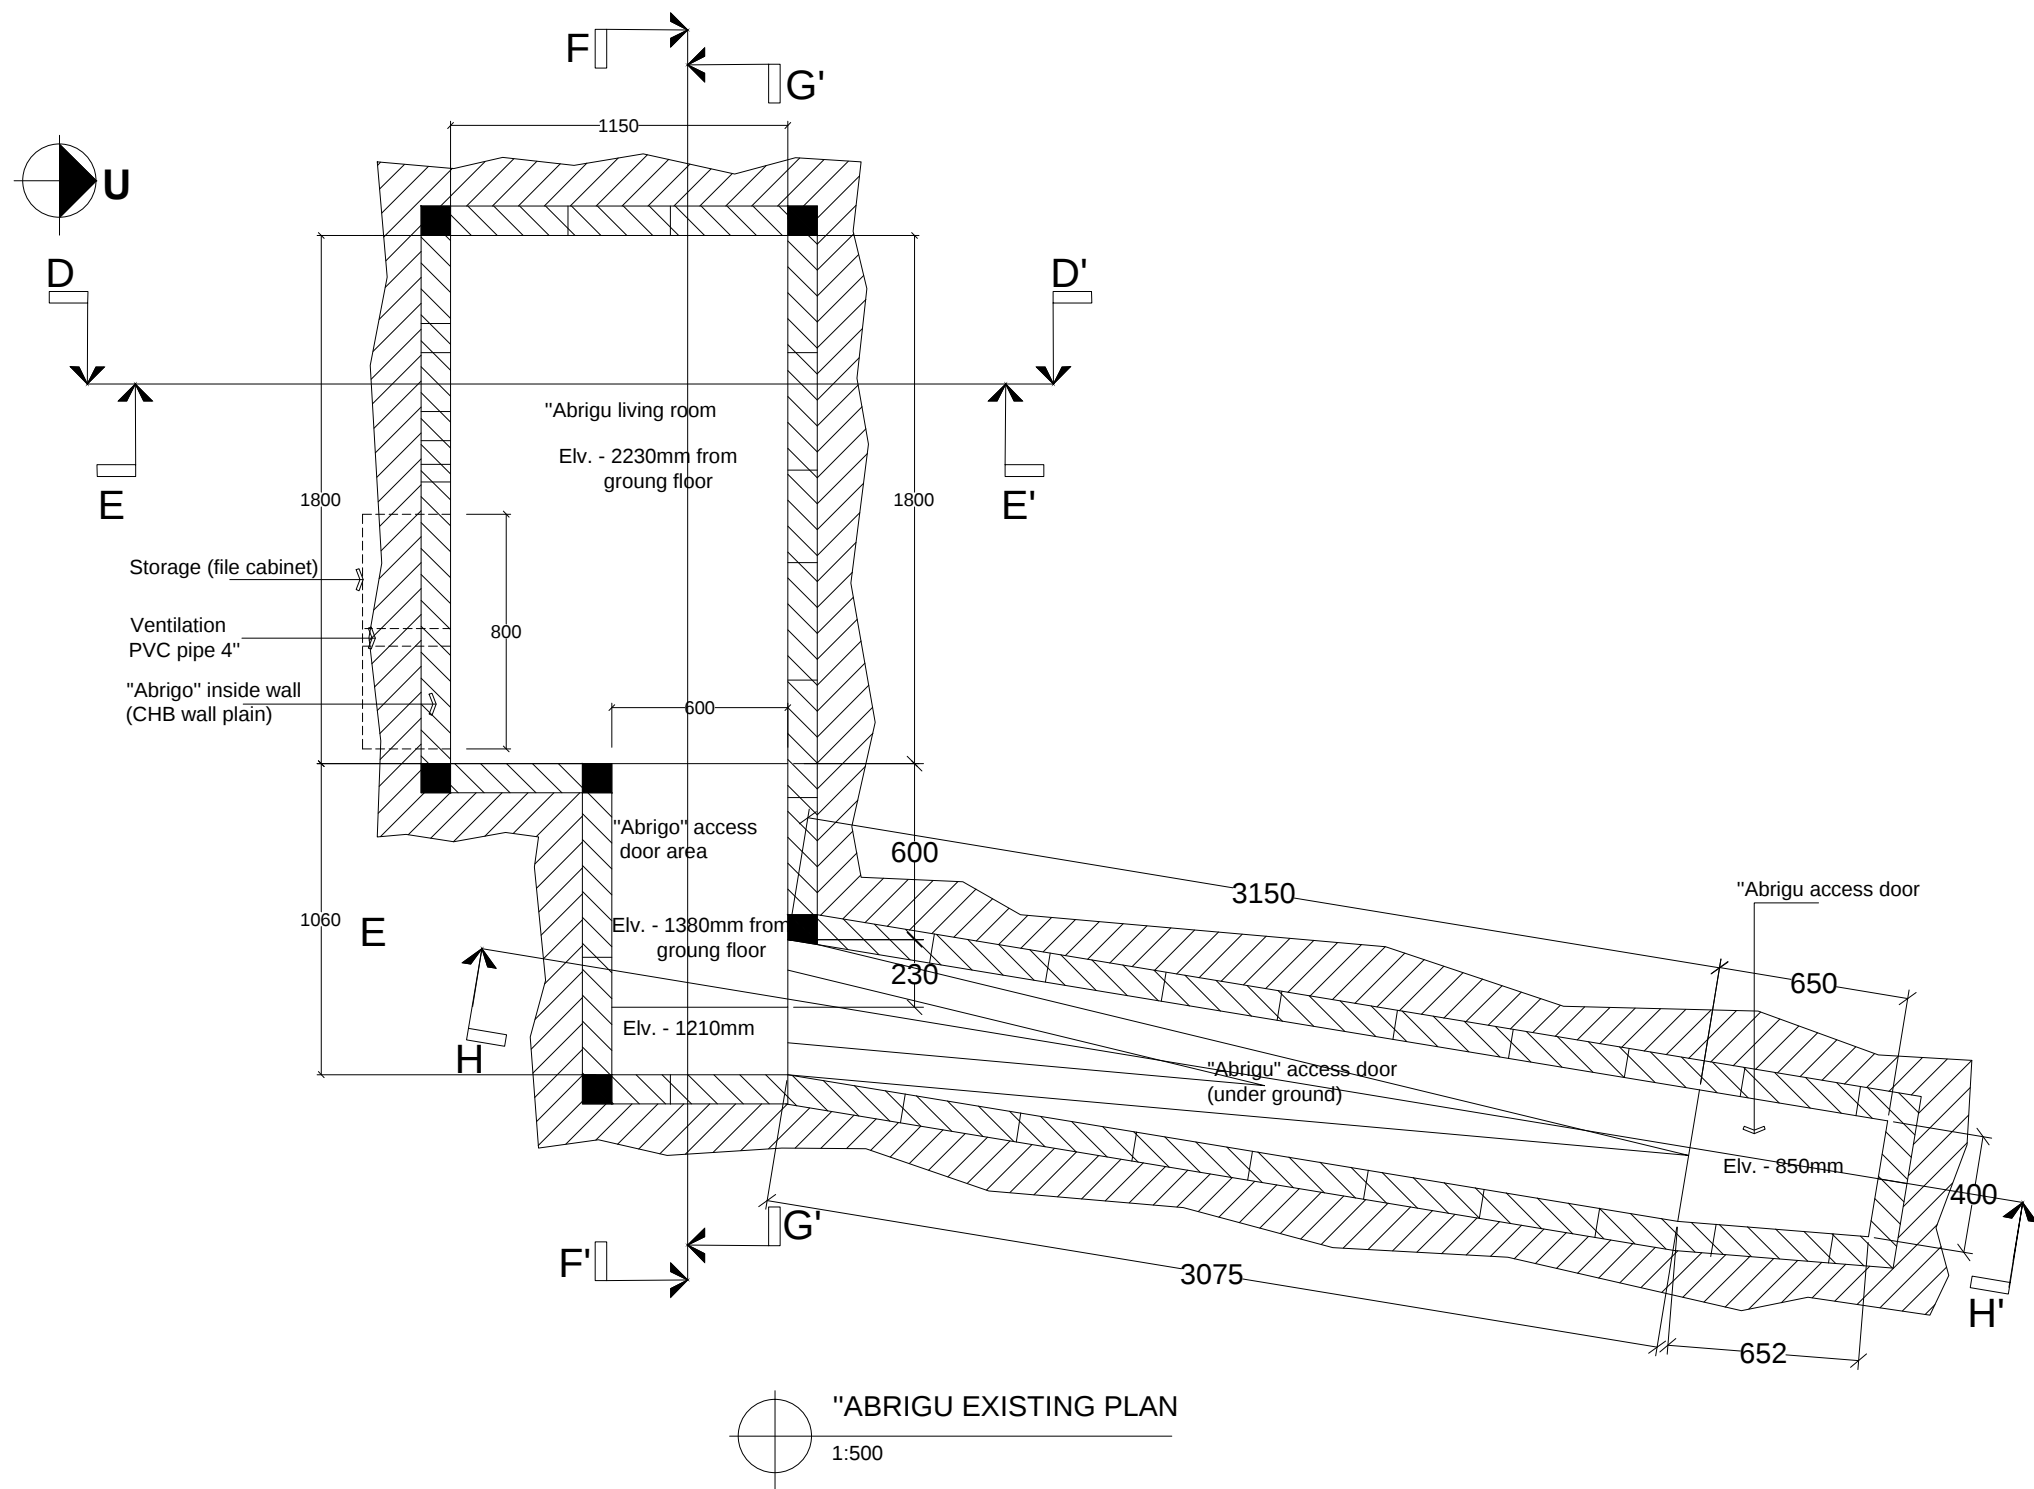

CLIENT / PROJECT OWNER		PREPARED BY	PROJECT TITLE	DRAWING TITLE	CONSULTANT DESIGN: A3R CONSULTANT		PROJECT OWNER			SHEET NO:		
 ARQUIVO & MUSEU RESISTÊNCIA TIMORENSE INSTITUTO PÚBLICO REPÚBLICA DEMOCRÁTICA DE TIMOR LESTE Avenida Cidade de Lisboa, Díli, Timor Leste Phone: +670 - 77305782	 ANGEL'AQUIRA Consultant, Unipessoal Lda. Architectural & Engineering Design Supervision and Project Management Vila Verde, Díli, Timor - Leste, Phone: +670 - 7238140 E-mail: ino_neves@yahoo.com	REHABILITAÇÃO DE ABRIGUS DA RESISTÊNCIA ABRIGU FATU META FATU META, DILI TIMOR LESTE LOCATION : DILI	"ABRIGU" EXISTING PLAN SCALE : 1:500	Arch. Aquilino F. das Neves	Eng. Jesuino J.X. Neves	Sr. Hamar Antoninho Baptista Alves Director e Presidente AMRT	 DEMOCRATIC REPUBLIC OF TIMOR LESTE MINISTRY OF PUBLIC WORK, TRANSPORT AND COMMUNICATION GENERAL DIRECTORATE OF PUBLIC WORKS NATIONAL DIRECTORATE OF BUILDING			09 OF 29		
							VERIFIED BY:		DATE	APPROVED BY:	DATE	DRAWING NO: ARCH 09 OF 29
							Eng. Octavio P. Marques, M.Eng. HEAD OF PROJECT DEPARTMENT		Arch. Rosa Amaral Vong Directress of DNE			


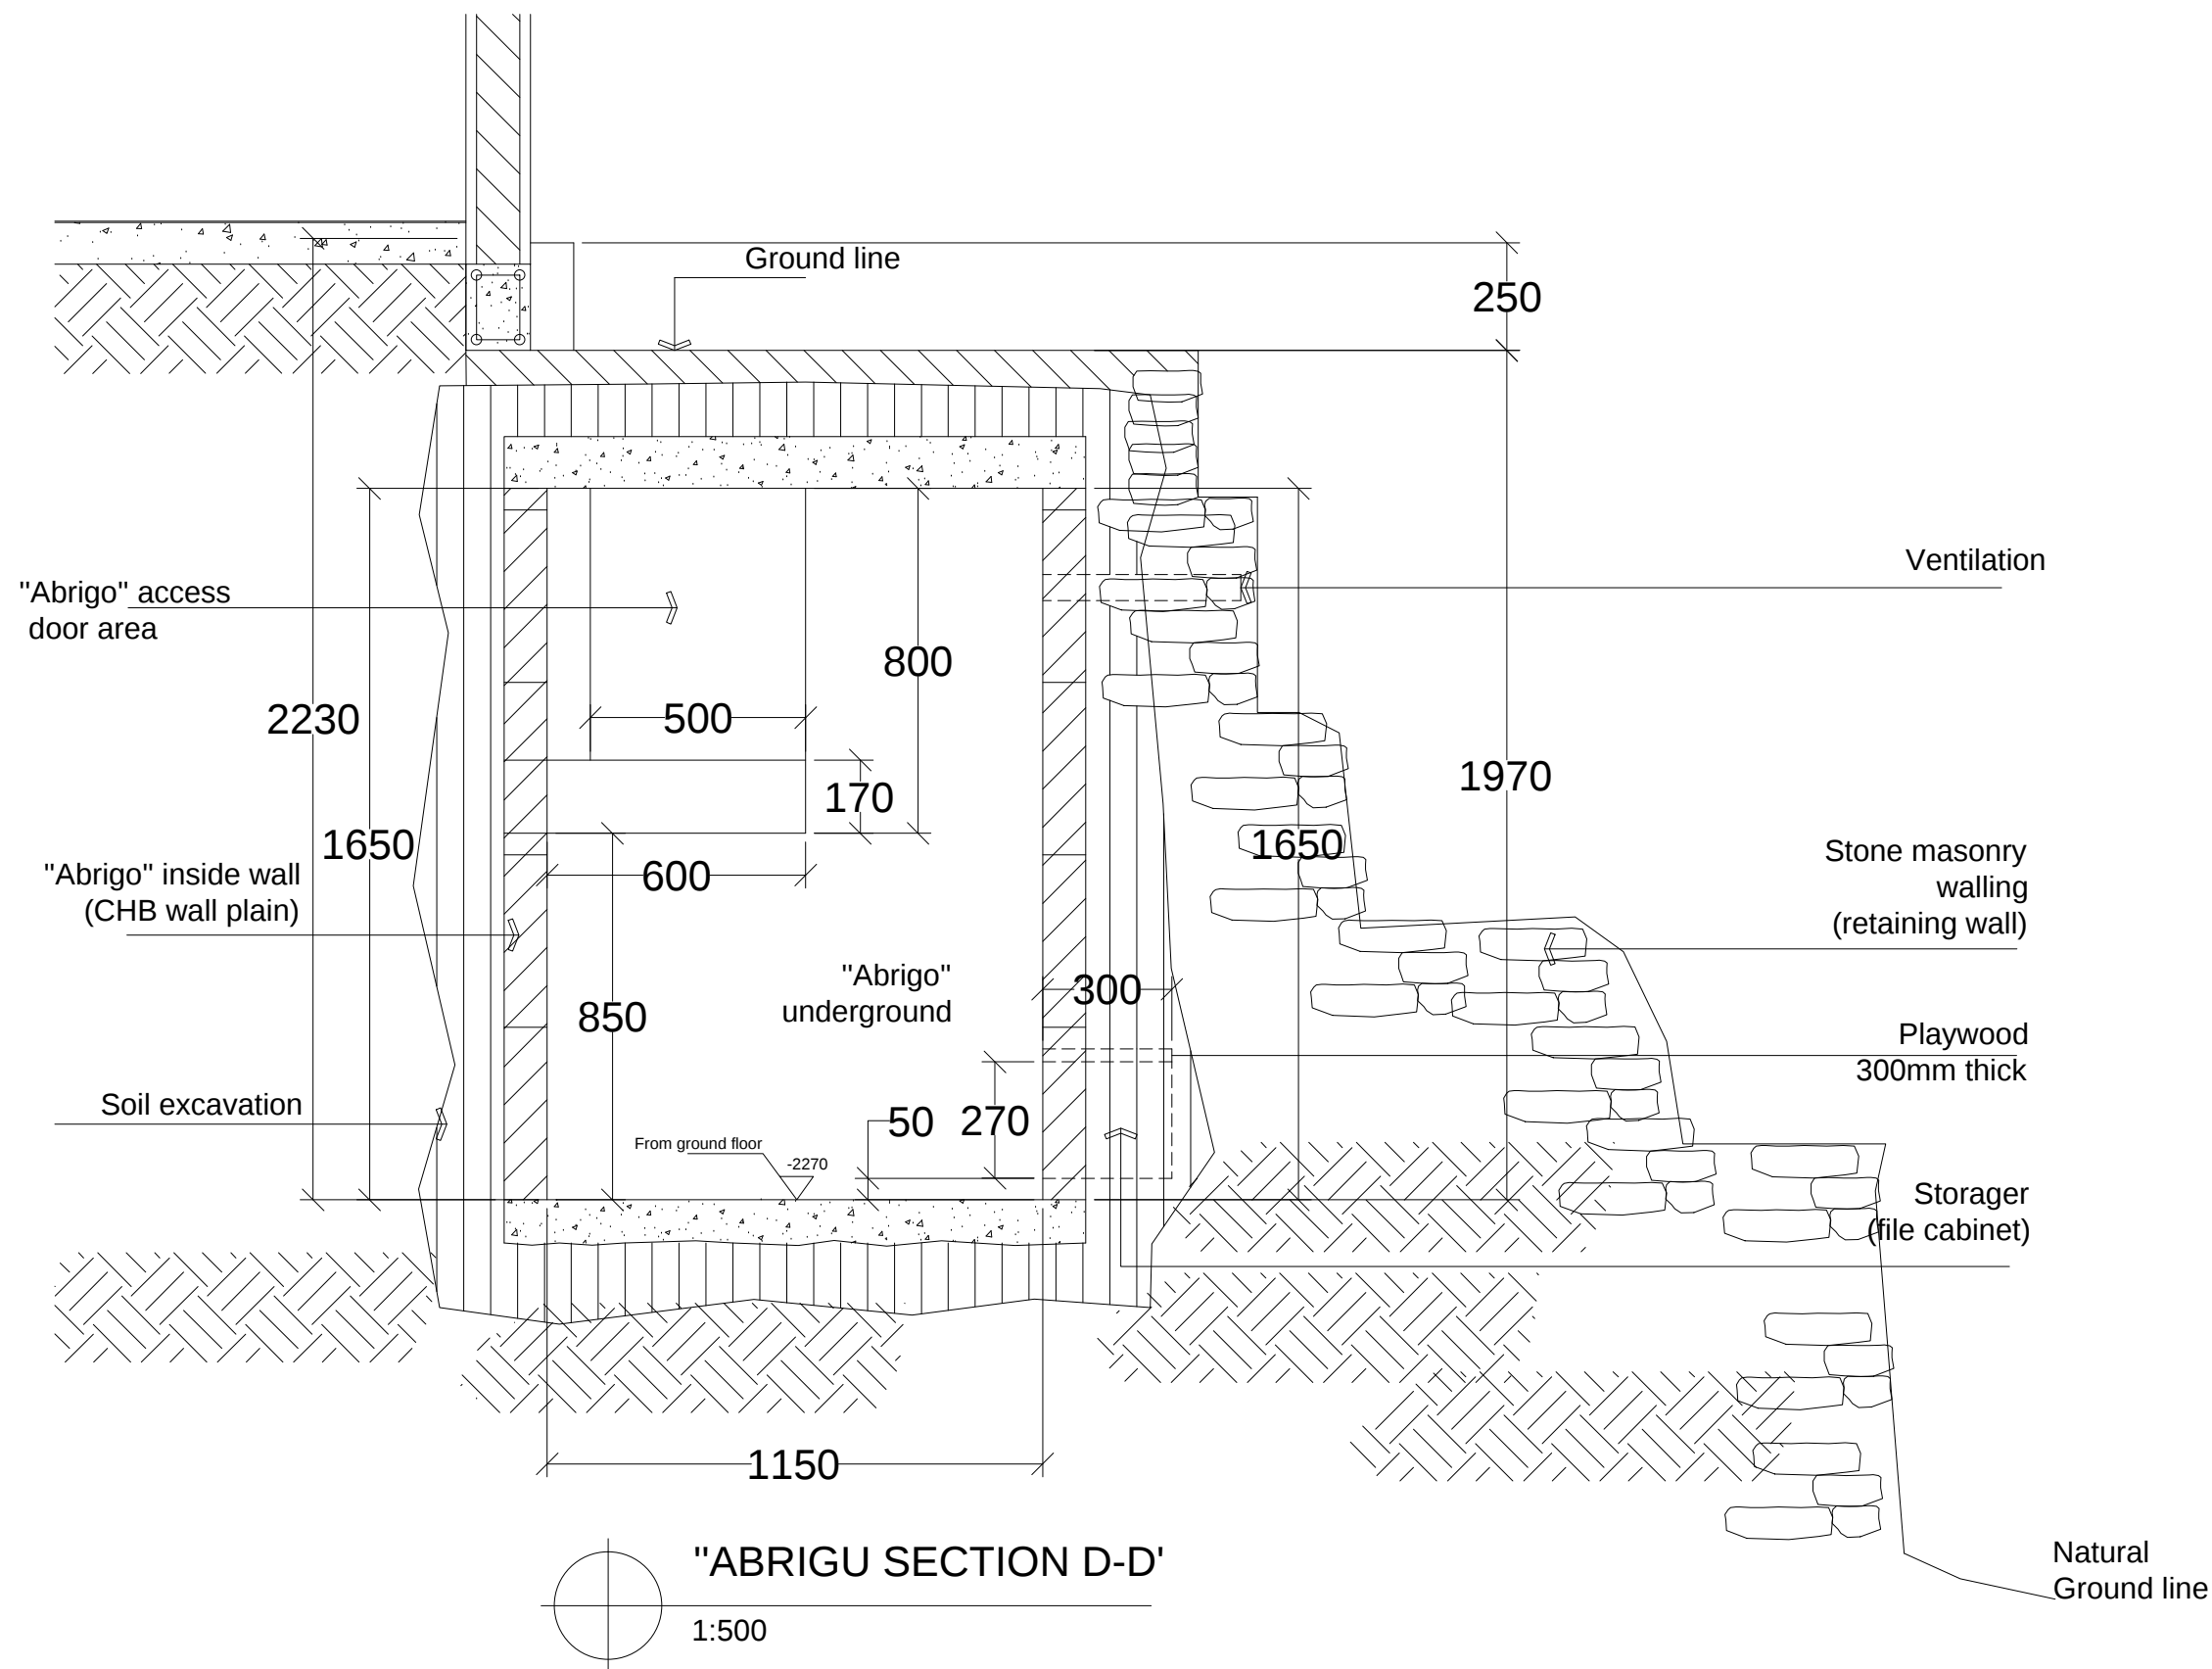


CLIENT / PROJECT OWNER	PREPARED BY	PROJECT TITLE	DRAWING TITLE	CONSULTANT DESIGN: A3R CONSULTANT		PROJECT OWNER	 DEMOCRATIC REPUBLIC OF TIMOR LESTE MINISTRY OF PUBLIC WORK, TRANSPORT AND COMMUNICATION GENERAL DIRECTORATE OF PUBLIC WORKS NATIONAL DIRECTORATE OF BUILDING				SHEET NO:
				DRAWING BY:	APPROVED BY:	APPROVED BY:					10 OF 29
 ARQUIVO & MUSEU RESISTÊNCIA TIMORENSE INSTITUTO PÚBLICO REPÚBLICA DEMOCRÁTICA DE TIMOR LESTE Avenida Cidade de Lisboa, Dili, Timor Leste Phone: +670 - 77305782	 ANGEL'AQUIRA Consultant, Unipessoal Lda. Architectural & Engineering Design, Supervision and Project Management Vila Verde, Dili, Timor - Leste, Phone: +670 - 7238140 E-mail: ino_neves@yahoo.com	REHABILITAÇÃO DE ABRIGOS DA RESISTÊNCIA ABRIGU FATU META FATU META, DILI TIMOR LESTE	"ABRIGU" SECTION	Arch. Aquilino F. das Neves	Eng. Jesuino J.X. Neves	Sr. Hamar Antoninho Baptista Alves Director e Presidente AMRT	VERIFIED BY:	DATE	APPROVED BY:	DATE	DRAWING NO:
		LOCATION : DILI	SCALE : 1:500	DATE :	DATE :	DATE :	Eng. Octavio P. Marques, M.Eng. HEAD OF PROJECT DEPARTMENT		Arch. Rosa Amaral Vong Directress of DNE		ARCH 10 OF 29

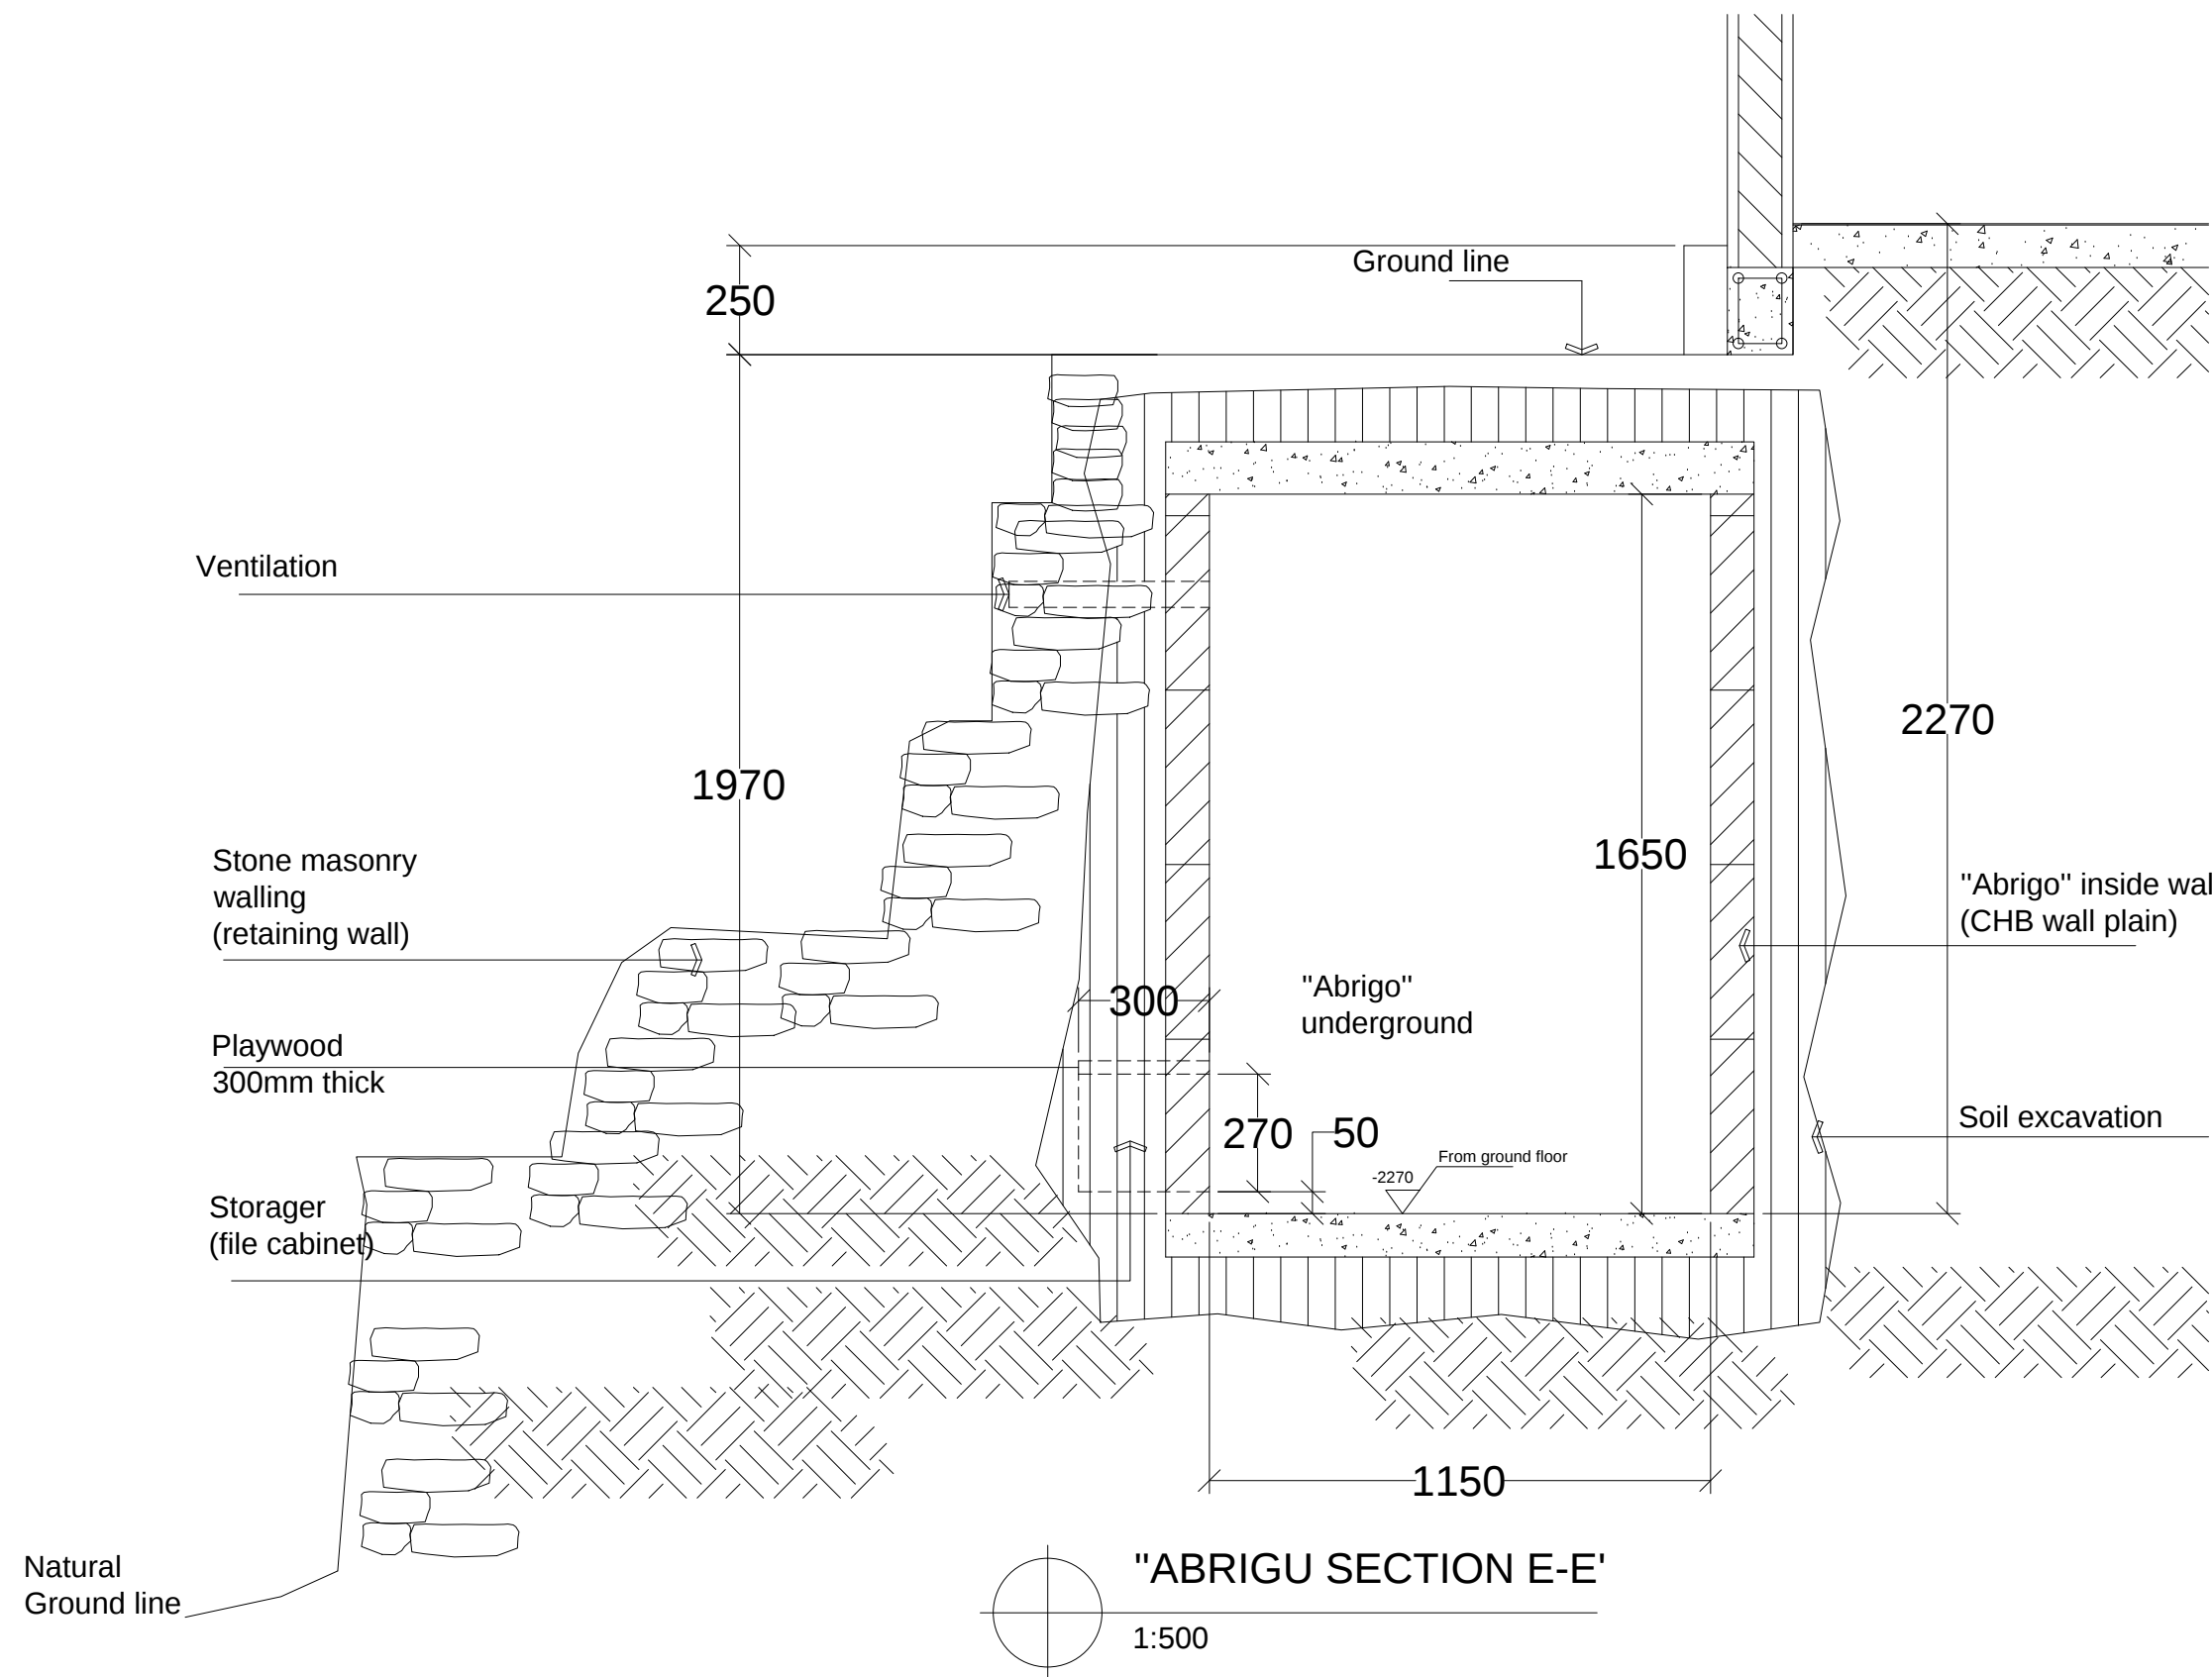

CLIENT / PROJECT OWNER		PREPARED BY	PROJECT TITLE	DRAWING TITLE	CONSULTANT DESIGN: A3R CONSULTANT		PROJECT OWNER	DEMOCRATIC REPUBLIC OF TIMOR LESTE MINISTRY OF PUBLIC WORK, TRANSPORT AND COMMUNICATION GENERAL DIRECTORATE OF PUBLIC WORKS NATIONAL DIRECTORATE OF BUILDING				SHEET NO:
 ARQUIVO & MUSEU RESISTÊNCIA TIMORENSE INSTITUTO PÚBLICO REPÚBLICA DEMOCRÁTICA DE TIMOR LESTE Avenida Cidade de Lisboa, Dili, Timor Leste Phone: +670 - 77305782		 ANGEL/AQUIRA Consultant, Unipessoal Lda. Architectural & Engineering Design, Supervision and Project Management Vila Verde, Dili, Timor - Leste, Phone: +670 - 7238140 E-mail: ino_neves@yahoo.com	REHABILITAÇÃO DE ABRIGOS DA RESISTÊNCIA ABRIGU FATU META FATU META, DILI TIMOR LESTE	"ABRIGU" SECTION	DRAWING BY:	APPROVED BY:	APPROVED BY:					11 OF 29
					Arch. Aquilino F. das Neves	Eng. Jesuino J.X. Neves	Sr. Hamar Antoninho Baptista Alves Director e Presidente AMRT	VERIFIED BY:	DATE	APPROVED BY:	DATE	DRAWING NO: ARCH 11 OF 29
			LOCATION : DILI	SCALE : 1:500	DATE :	DATE :	DATE :	Eng. Octavio P. Marques, M.Eng. HEAD OF PROJECT DEPARTMENT		Arch. Rosa Amaral Vong Directress of DNE		

Ground line

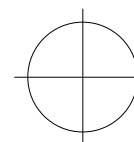
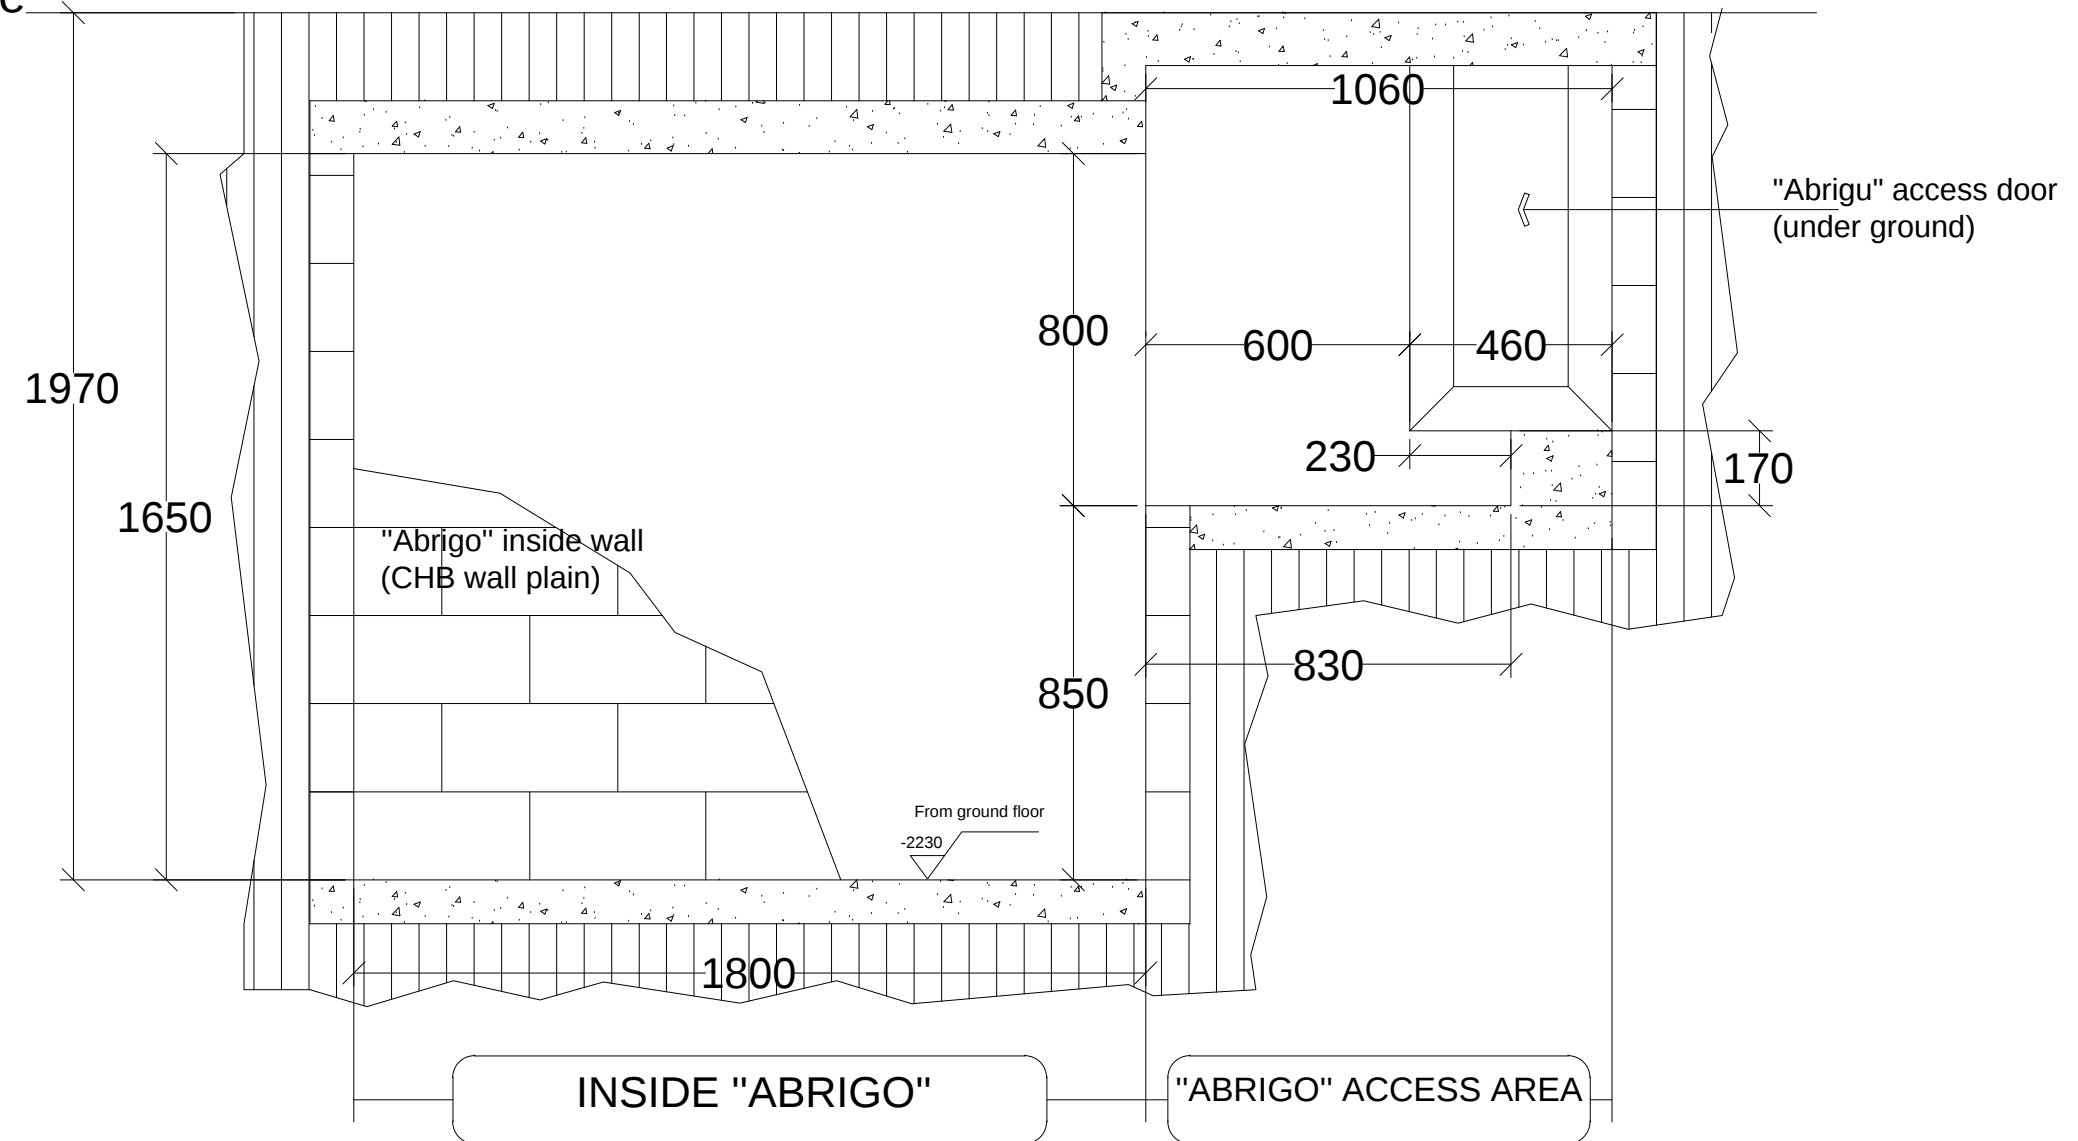


"ABRIGU SECTION F-F"

1:500

CLIENT / PROJECT OWNER		PREPARED BY	PROJECT TITLE	DRAWING TITLE	CONSULTANT DESIGN: A3R CONSULTANT		PROJECT OWNER	DEMOCRATIC REPUBLIC OF TIMOR LESTE				SHEET NO:
 ARQUIVO & MUSEU RESISTÊNCIA TIMORENSE INSTITUTO PÚBLICO REPÚBLICA DEMOCRÁTICA DE TIMOR LESTE Avenida Cidade de Lisboa, Dili, Timor Leste Phone: +670 - 77305782		 ANGEL'AQUIRA Consultant, Unipessoal Lda. Architectural & Engineering Design, Supervision and Project Management Vila Verde, Dili, Timor - Leste, Phone: +670 - 7238140 E-mail: ino_neves@yahoo.com	REHABILITAÇÃO DE ABRIGOS DA RESISTÊNCIA ABRIGU FATU META FATU META, DILI TIMOR LESTE	"ABRIGU" SECTION	DRAWING BY:	APPROVED BY:	APPROVED BY:	 MINISTRY OF PUBLIC WORK, TRANSPORT AND COMMUNICATION GENERAL DIRECTORATE OF PUBLIC WORKS NATIONAL DIRECTORATE OF BUILDING				12 OF 29
					Arch. Aquilino F. das Neves	Eng. Jesuino J.X. Neves	Sr. Hamar Antoninho Baptista Alves Director e Presidente AMRT					DRAWING NO:
					DATE :	DATE :	DATE :	VERIFIED BY:	DATE	APPROVED BY:	DATE	ARCH 12 OF 29
			LOCATION : DILI	SCALE : 1:500				Eng. Octavio P. Marques, M.Eng. HEAD OF PROJECT DEPARTMENT		Arch. Rosa Amaral Vong Directress of DNE		


Ground line

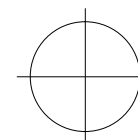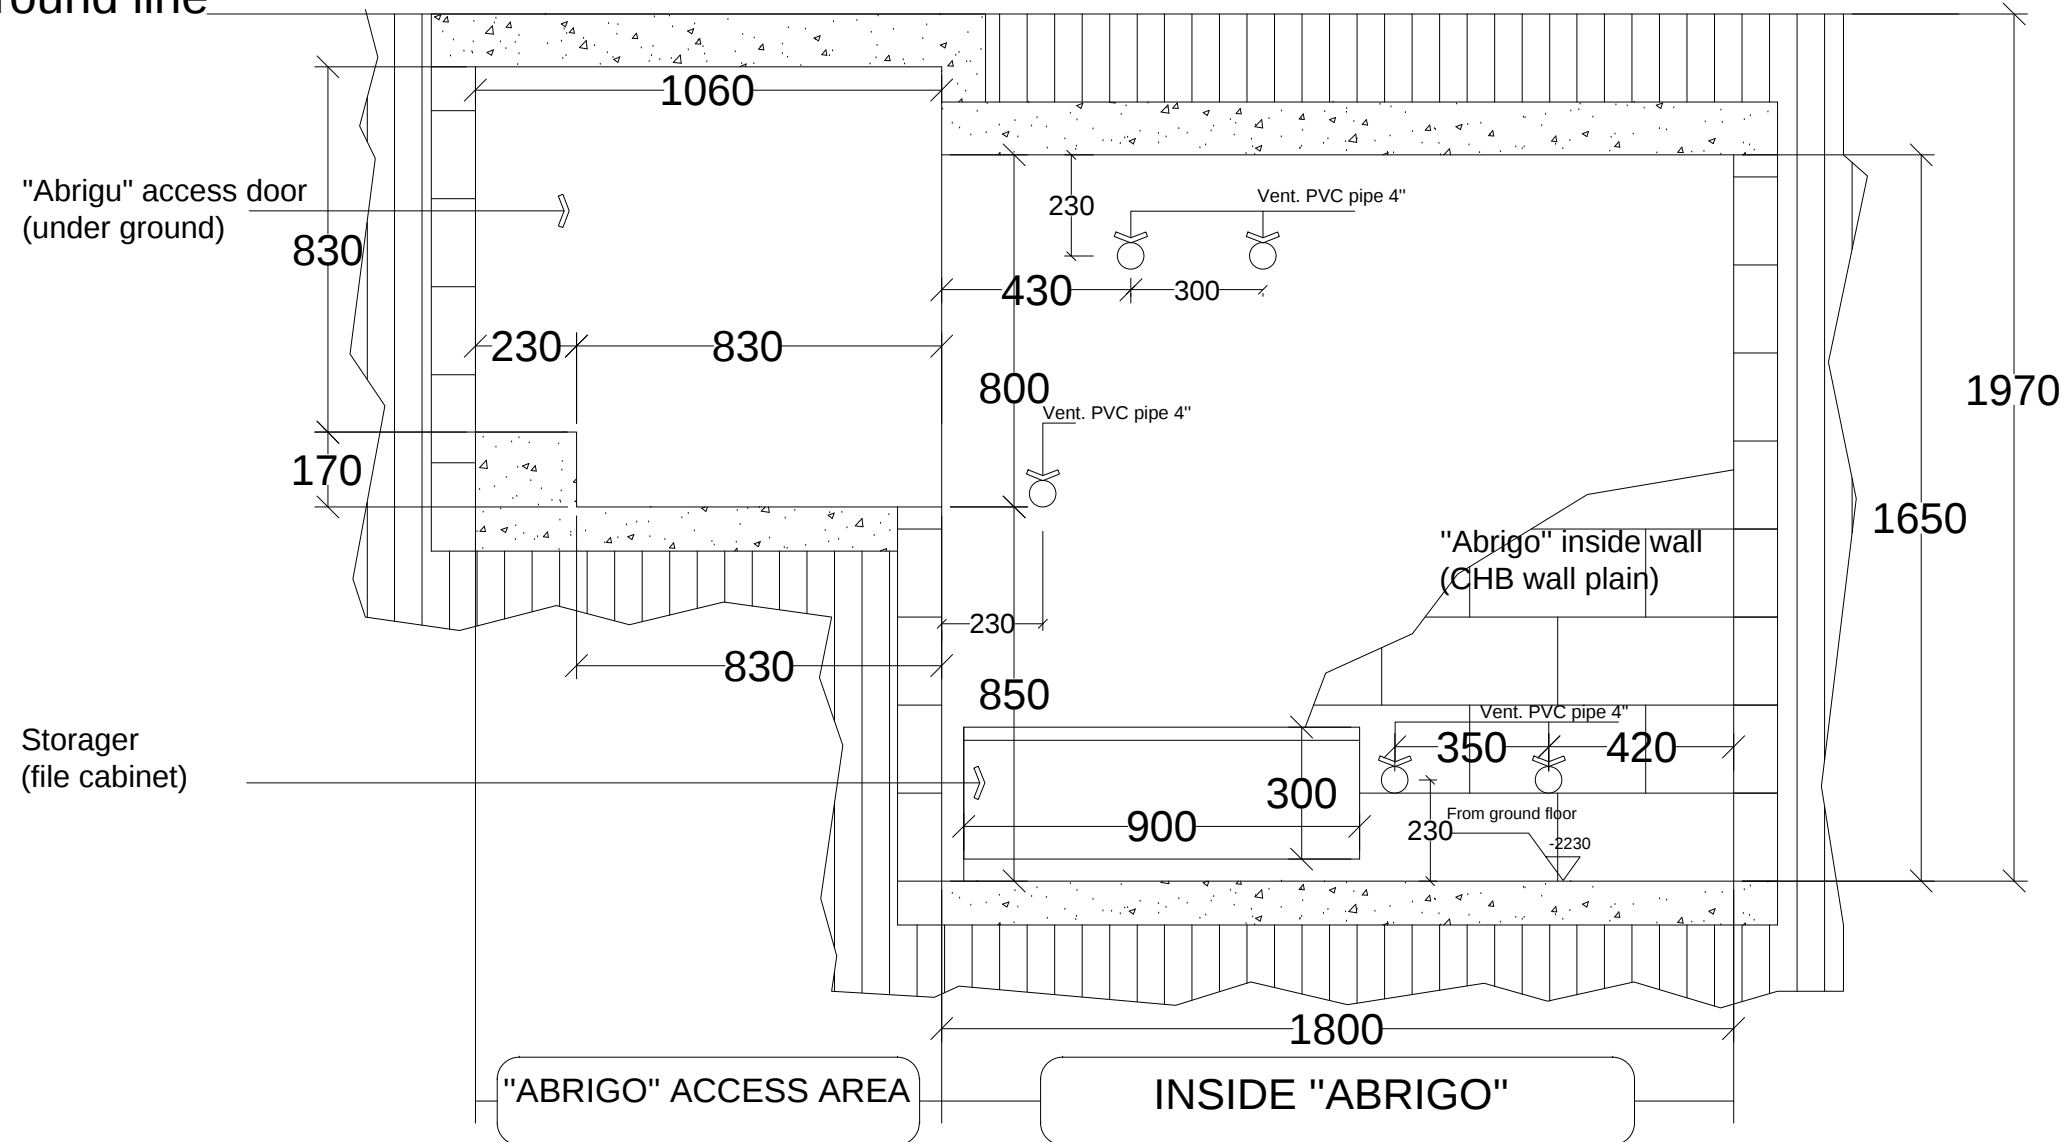

"ABRIGO SECTION G-G"

1:500

CLIENT / PROJECT OWNER		PREPARED BY	PROJECT TITLE	DRAWING TITLE	CONSULTANT DESIGN: A3R CONSULTANT		PROJECT OWNER	DEMOCRATIC REPUBLIC OF TIMOR LESTE				SHEET NO:
 ARQUIVO & MUSEU RESISTÊNCIA TIMORENSE INSTITUTO PÚBLICO REPÚBLICA DEMOCRÁTICA DE TIMOR LESTE Avenida Cidade de Lisboa, Dili, Timor Leste Phone: +670 - 77305782		 ANGEL'AQUIRA Consultant, Unipessoal Lda. Architectural & Engineering Design, Supervision and Project Management Vila Verde, Dili, Timor - Leste, Phone: +670 - 7238140 E-mail: ino_neves@yahoo.com	REHABILITAÇÃO DE ABRIGOS DA RESISTÊNCIA ABRIGO FATU META FATU META, DILI TIMOR LESTE	"ABRIGO" SECTION	DRAWING BY:	APPROVED BY:	APPROVED BY:	 MINISTRY OF PUBLIC WORK, TRANSPORT AND COMMUNICATION GENERAL DIRECTORATE OF PUBLIC WORKS NATIONAL DIRECTORATE OF BUILDING				13 OF 29
					Arch. Aquilino F. das Neves	Eng. Jesuino J.X. Neves	Sr. Hamar Antoninho Baptista Alves Director e Presidente AMRT					DRAWING NO:
					DATE :	DATE :	DATE :	VERIFIED BY:	DATE	APPROVED BY:	DATE	ARCH 13 OF 29
			LOCATION : DILI	SCALE : 1:500				Eng. Octavio P. Marques, M.Eng. HEAD OF PROJECT DEPARTMENT		Arch. Rosa Amaral Vong Directress of DNE		

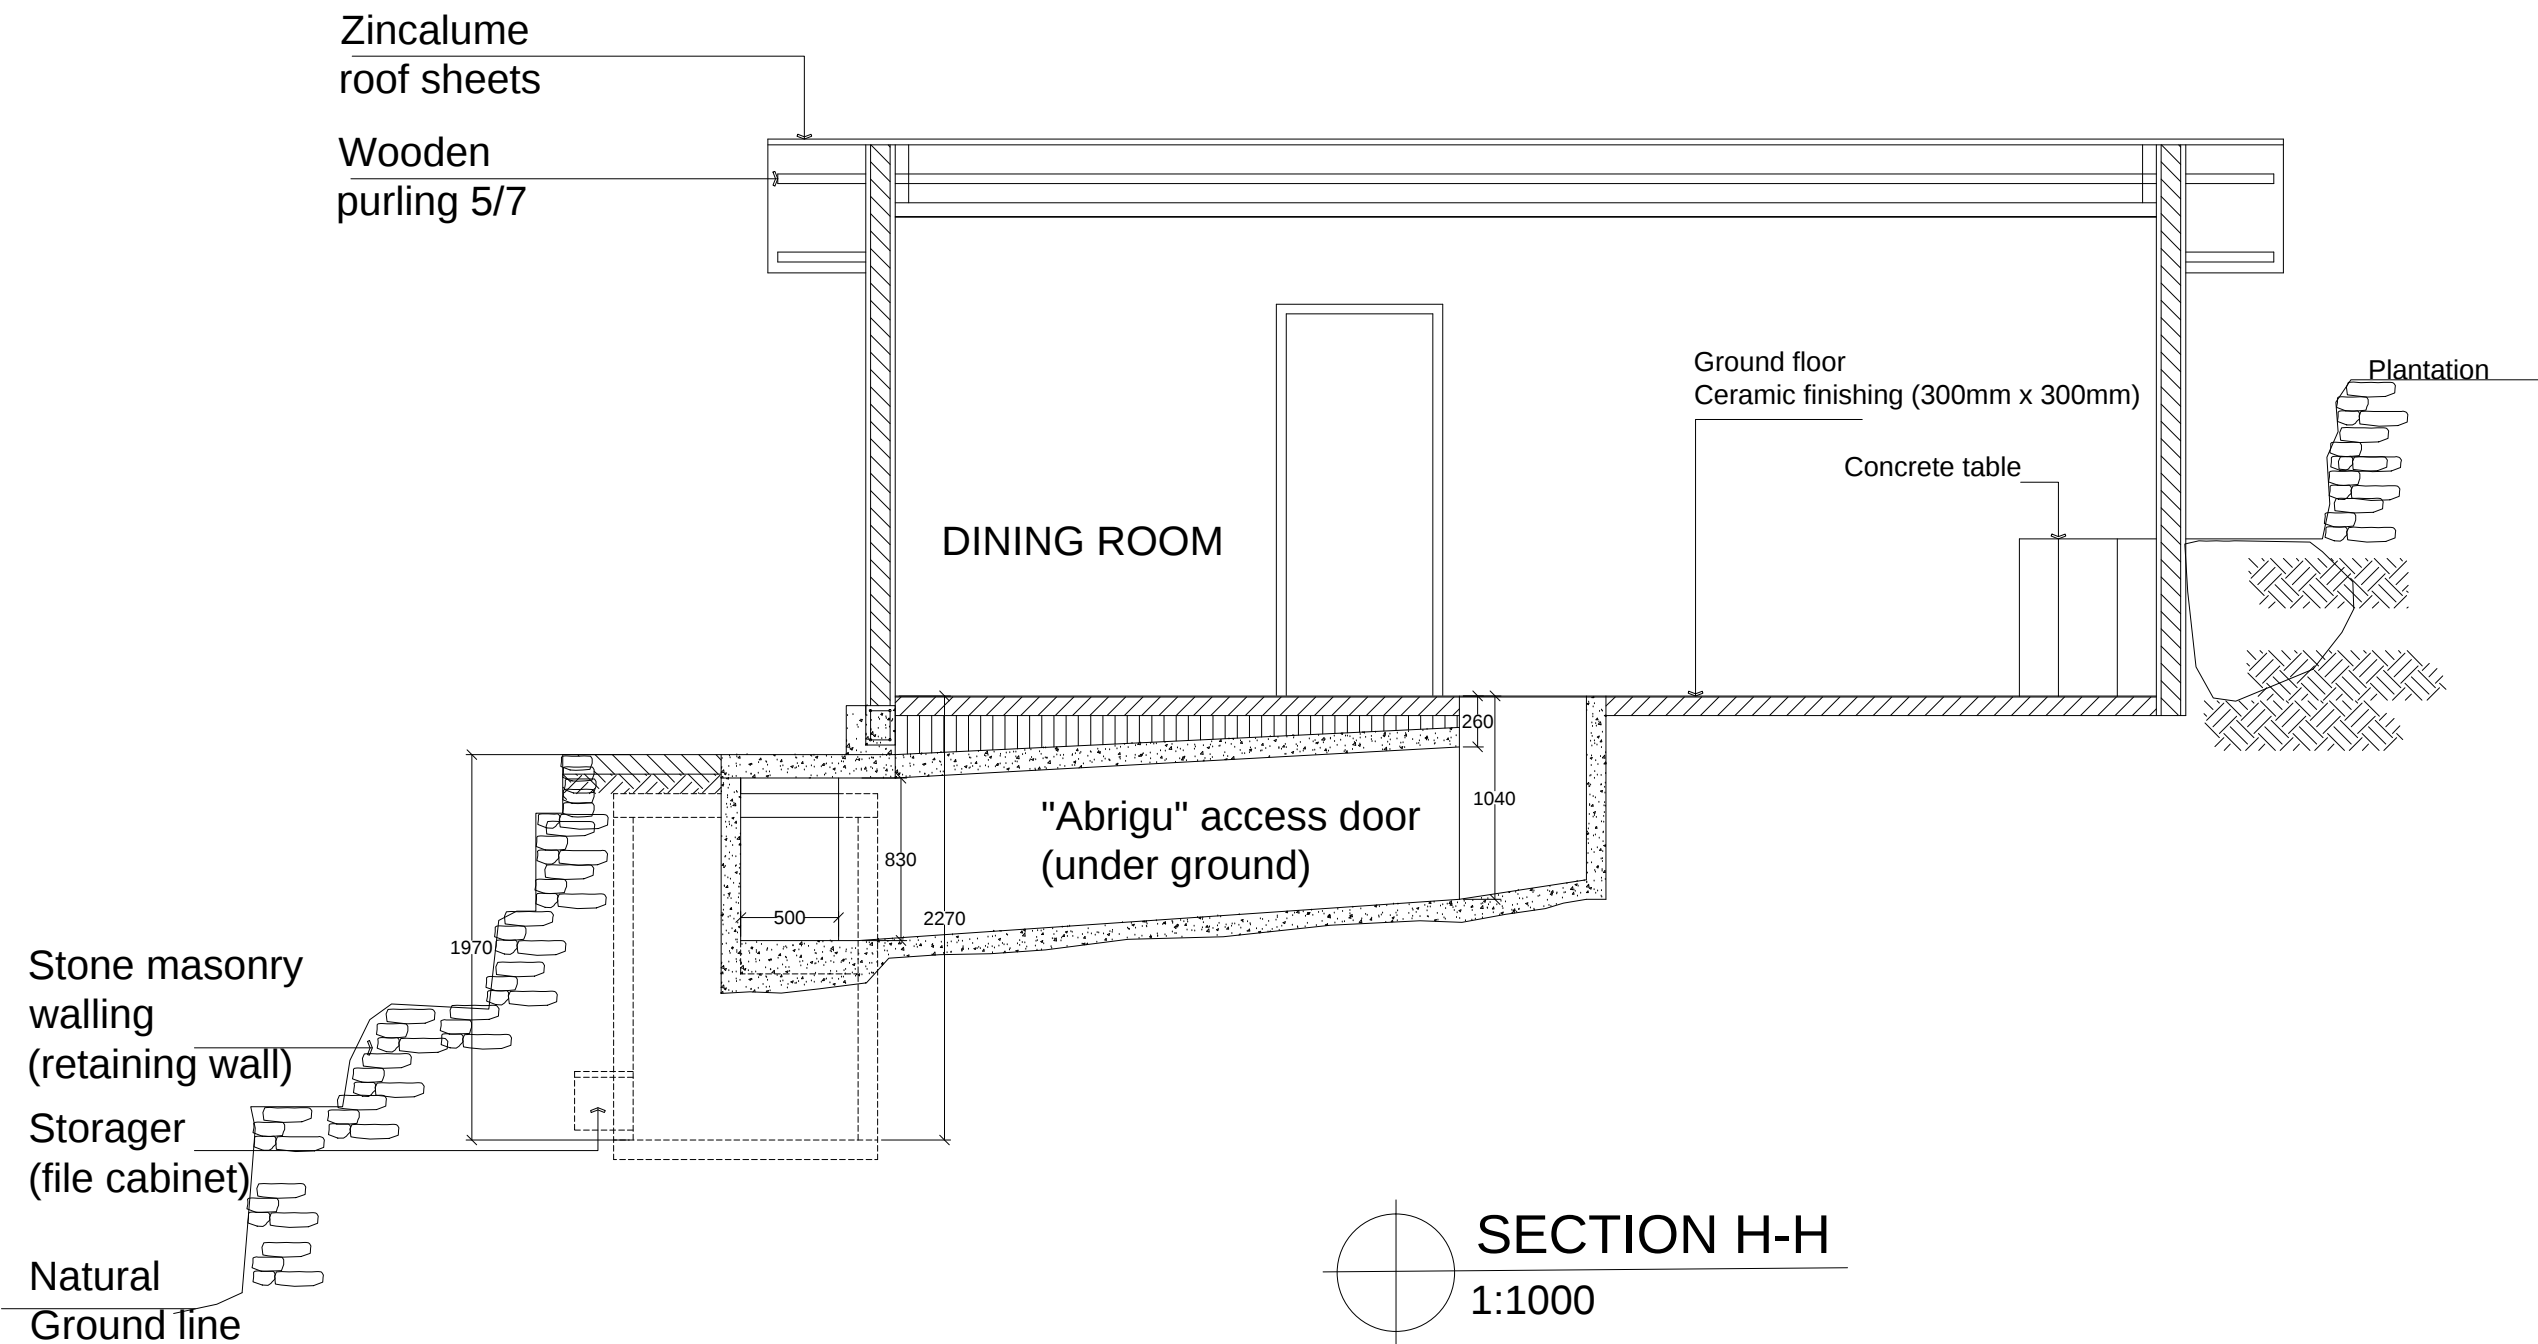

CLIENT / PROJECT OWNER		PREPARED BY	PROJECT TITLE	DRAWING TITLE	CONSULTANT DESIGN: A3R CONSULTANT		PROJECT OWNER		 DEMOCRATIC REPUBLIC OF TIMOR LESTE MINISTRY OF PUBLIC WORK, TRANSPORT AND COMMUNICATION GENERAL DIRECTORATE OF PUBLIC WORKS NATIONAL DIRECTORATE OF BUILDING	SHEET NO:
 ARQUIVO & MUSEU RESISTÊNCIA TIMORENSE INSTITUTO PÚBLICO REPÚBLICA DEMOCRÁTICA DE TIMOR LESTE Avenida Cidade de Lisboa, Dili, Timor Leste Phone: +670 - 77305782	 ANGEL'AQUIRA Consultant, Unipessoal Lda. Architectural & Engineering Design, Supervision and Project Management Vila Verde, Dili, Timor - Leste, Phone: +670 - 7238140 E-mail: ino_neves@yahoo.com	REHABILITAÇÃO DE ABRIGUS DA RESISTÊNCIA ABRIGU FATU META FATU META, DILI TIMOR LESTE	"ABRIGU" SECTION	DRAWING BY:	APPROVED BY:	APPROVED BY:		14 OF 29		
				Arch. Aquilino F. das Neves	Eng. Jesuino J.X. Neves	Sr. Hamar Antoninho Baptista Alves Director e Presidente AMRT	DRAWING NO: ARCH 14 OF 29			
					VERIFIED BY:	DATE	APPROVED BY:	DATE		
				Eng. Octavio P. Marques, M.Eng. HEAD OF PROJECT DEPARTMENT		Arch. Rosa Amaral Vong Directress of DNE				





NO	ITEM
1.	Remove and replace roof sheets RS (dining room)
2.	Remove and replace ceiling
3.	Remove and replace window (WD)
4.	Remove and replace door (D)
5.	Remove and replace wall (WL)
6.	Remove and replace ground floor (dining room)
7.	Remove and replace beam under (WL)
8.	New foundation, column, top beam "abrigo"
9.	Remove and replace "abrigo" top deck
10.	Remove and replace wall block (CHB wall) W1,W2,W3,W4
11.	Remove and replace electricity instalation

Rehabilitation area
(top of "Abrigo")

REHABILITATION ITEMS

1:1000


CLIENT / PROJECT OWNER	PREPARED BY	PROJECT TITLE	DRAWING TITLE	CONSULTANT DESIGN: A3R CONSULTANT		PROJECT OWNER		 DEMOCRATIC REPUBLIC OF TIMOR LESTE MINISTRY OF PUBLIC WORK, TRANSPORT AND COMMUNICATION GENERAL DIRECTORATE OF PUBLIC WORKS NATIONAL DIRECTORATE OF BUILDING	SHEET NO:			
 ARQUIVO & MUSEU RESISTÊNCIA TIMORENSE INSTITUTO PÚBLICO REPÚBLICA DEMOCRÁTICA DE TIMOR LESTE Avenida Cidade de Lisboa, Dili, Timor Leste Phone: +670 - 77305782	 ANGEL'AQUIRA Consultant, Unipessoal Lda. Architectural & Engineering Design, Supervision and Project Management Vila Verde, Dili, Timor - Leste, Phone: +670 - 7238140 E-mail: ino_neves@yahoo.com	REHABILITAÇÃO DE ABRIGOS DA RESISTÊNCIA ABRIGU FATU META FATU META, DILI TIMOR LESTE	REHABILITATION ITEMS	DRAWING BY:	APPROVED BY:	APPROVED BY:	VERIFIED BY:		DATE	APPROVED BY:	DATE	15 OF 29
				Arch. Aquilino F. das Neves	Eng. Jesuino J.X. Neves	Sr. Hamar Antoninho Baptista Alves Director e Presidente AMRT	Eng. Octavio P. Marques, M.Eng. HEAD OF PROJECT DEPARTMENT			Arch. Rosa Amaral Yong Directress of DNE		DRAWING NO: ARCH 15 OF 29
		LOCATION : DILI	SCALE : 1:1000	DATE :	DATE :	DATE :						

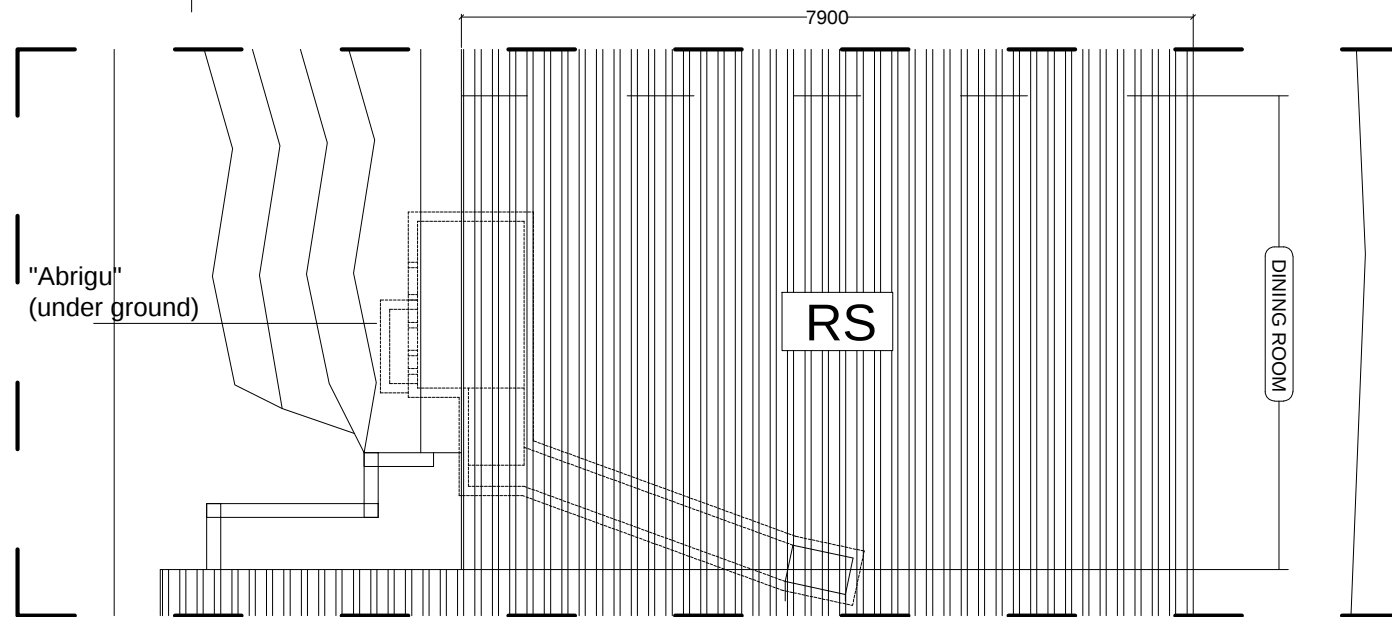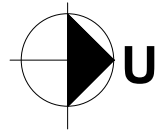

REHABILITATION ITEM FOR "ABRIGU" FATU META TIMOR LESTE

- | NO | ITEM |
|-----|--|
| 1. | Remove and replace roof sheets RS (dining room) |
| 2. | Remove and replace ceiling |
| 3. | Remove and replace window (WD) |
| 4. | Remove and replace door (D) |
| 5. | Remove and replace wall (WL) |
| 6. | Remove and replace ground floor (dining room) |
| 7. | Remove and replace beam under (WL) |
| 8. | New foundation, column, top beam "abrigu" |
| 9. | Remove and replace "abrigu" top deck |
| 10. | Remove and replace wall block (CHB wall) W1,W2,W3,W4 |
| 11. | Remove and replace electricity instalation |

ROOF SHEETS

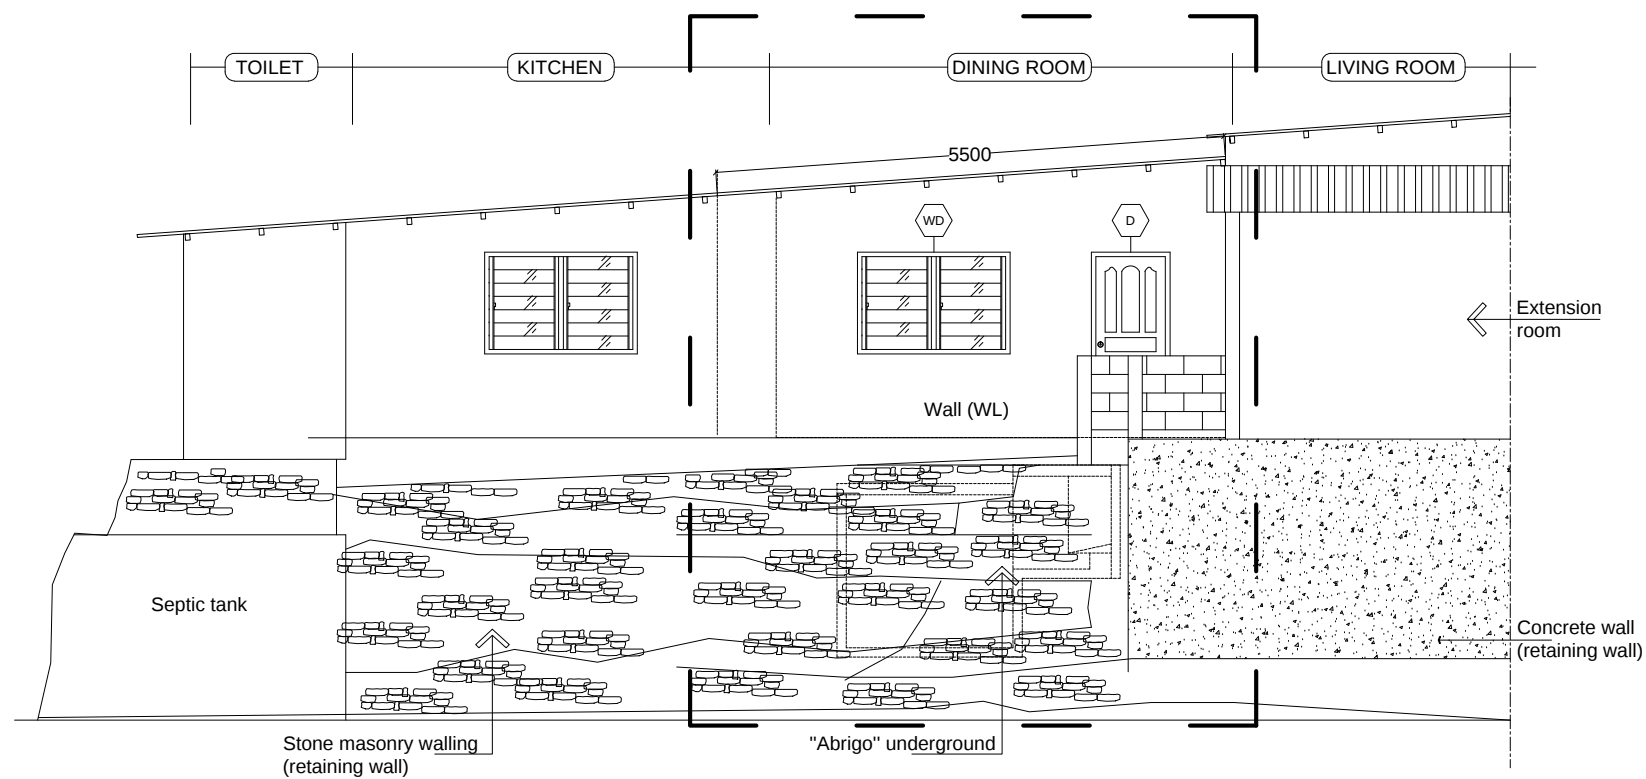

SIDE VIEW





REMOVE REPLACE ROOF

1:1500




CLIENT / PROJECT OWNER		PREPARED BY	PROJECT TITLE	DRAWING TITLE	CONSULTANT DESIGN: A3R CONSULTANT		PROJECT OWNER	DEMOCRATIC REPUBLIC OF TIMOR LESTE				SHEET NO:
 ARQUIVO & MUSEU RESISTÊNCIA TIMORENSE INSTITUTO PÚBLICO REPÚBLICA DEMOCRÁTICA DE TIMOR LESTE Avenida Cidade de Lisboa, Dili, Timor Leste Phone: +670 - 77305782		 ANGEL'AQUIRA Consultant, Unipessoal Lda. Architectural & Engineering Design, Supervision and Project Management Vila Verde, Dili, Timor - Leste, Phone: +670 - 7238140 E-mail: ino_neves@yahoo.com	REHABILITAÇÃO DE ABRIGUS DA RESISTÊNCIA ABRIGU FATU META FATU META, DILI TIMOR LESTE LOCATION : DILI	REMOVE AND REPLACE ROOF SHEETS SCALE : 1:1500	DRAWING BY:	APPROVED BY:	APPROVED BY:	 MINISTRY OF PUBLIC WORK, TRANSPORT AND COMMUNICATION GENERAL DIRECTORATE OF PUBLIC WORKS NATIONAL DIRECTORATE OF BUILDING				16 OF 29
					Arch. Aquilino F. das Neves	Eng. Jesuino J.X. Neves	Sr. Hamar Antoninho Baptista Alves Director e Presidente AMRT					
					DATE :	DATE :	DATE :	VERIFIED BY:	DATE	APPROVED BY:	DATE	DRAWING NO:
								Eng. Octavio P. Marques, M.Eng. HEAD OF PROJECT DEPARTMENT		Arch. Rosa Amaral Vong Directress of DNE		ARCH 16 OF 29


REHABILITATION ITEM FOR "ABRIGU" FATU META
TIMOR LESTE

NO	ITEM	5.	Remove and replace wall (WL)	8.	New foundation, column, top beam "abrigu"
1.	Remove and replace roof sheets (dining room)	6.	Remove and replace ground floor (dining room)	9.	Remove and replace "abrigu" top deck
2.	Remove and replace ceiling	7.	ove and replace beam under (WL)	10.	Remove and replace wall block (CHB wall) W1,W2,W3,W4
3.	Remove and replace window (WD)			11.	Remove and replace electricity instalation
4.	Remove and replace door (D)				

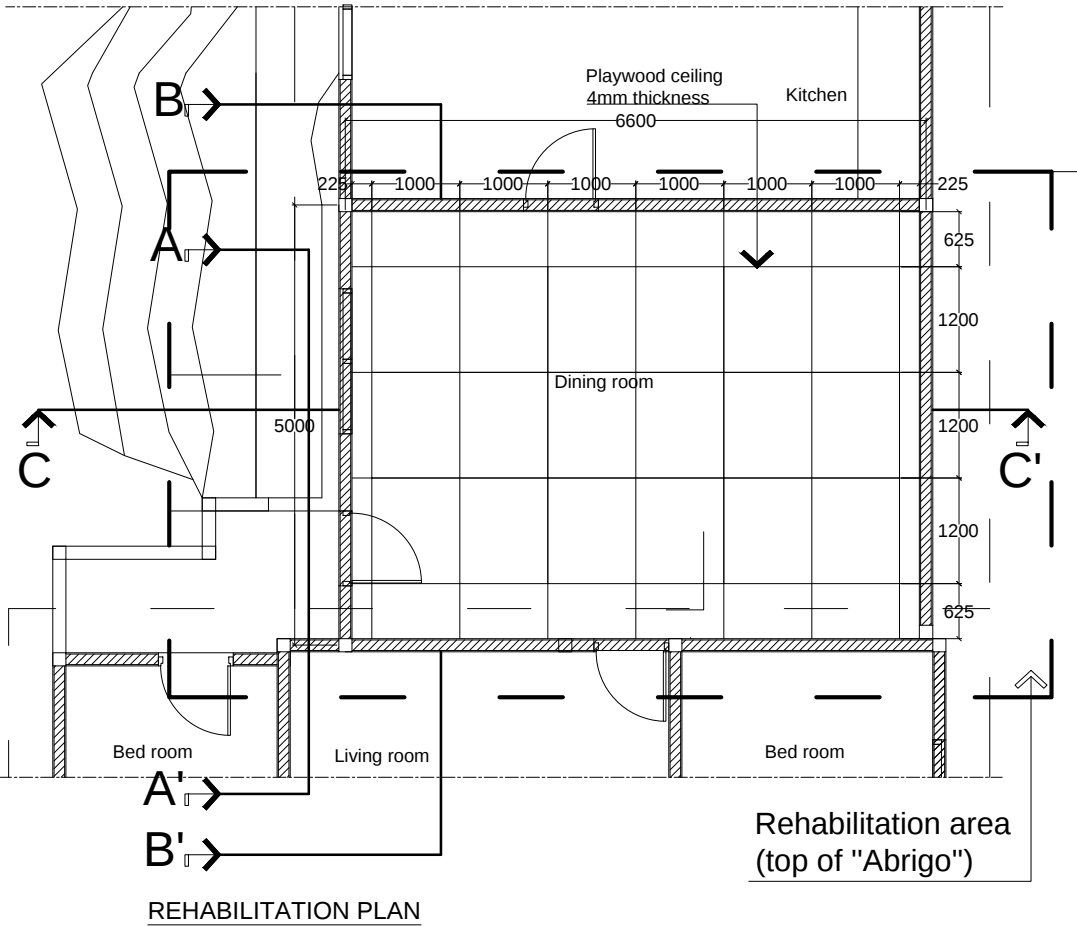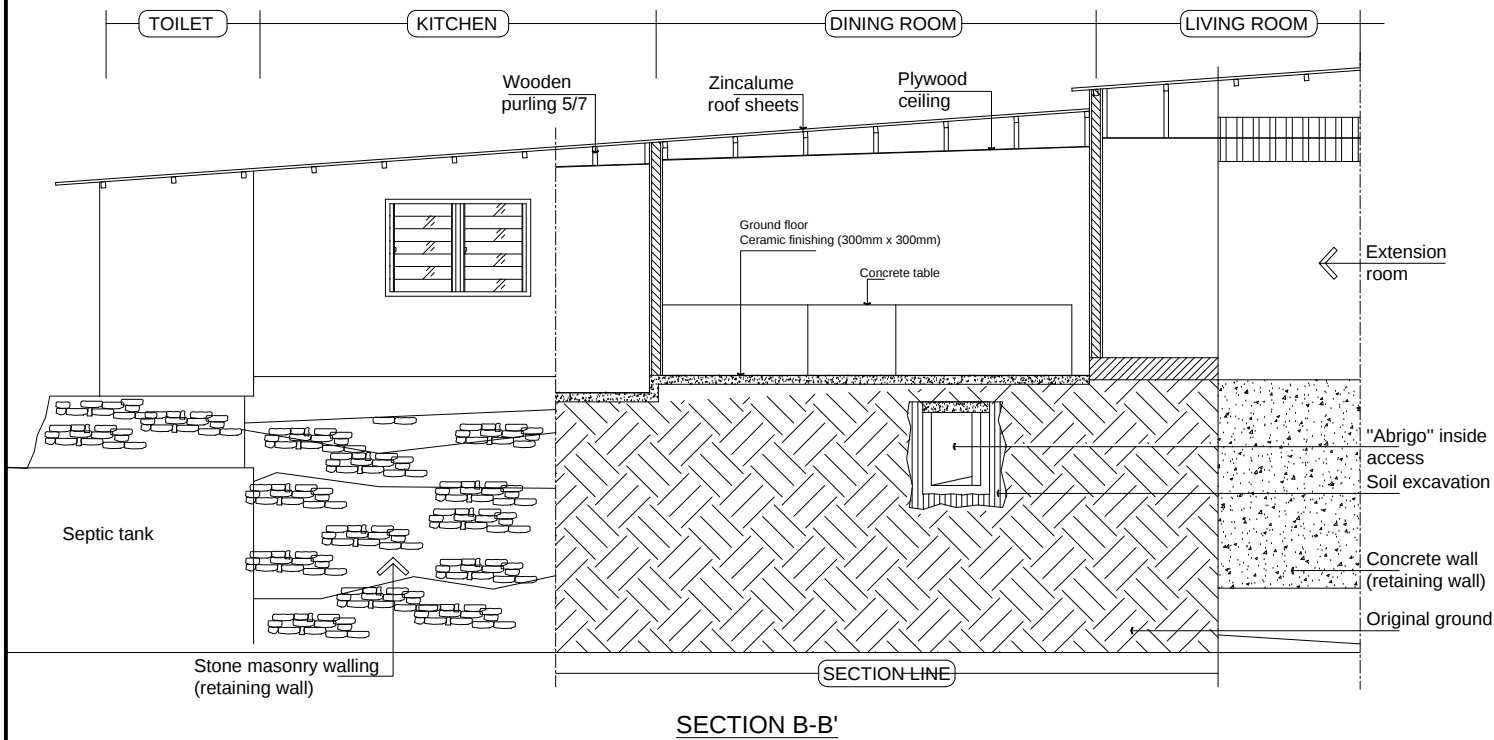

REMOVE AND REPLACE CEILING
1:1500

   CLIENT / PROJECT OWNER	PREPARED BY	PROJECT TITLE	DRAWING TITLE	CONSULTANT DESIGN: A3R CONSULTANT		PROJECT OWNER		 DEMOCRATIC REPUBLIC OF TIMOR LESTE MINISTRY OF PUBLIC WORK, TRANSPORT AND COMMUNICATION GENERAL DIRECTORATE OF PUBLIC WORKS NATIONAL DIRECTORATE OF BUILDING	SHEET NO:		
 ARQUIVO & MUSEU RESISTÊNCIA TIMORENSE INSTITUTO PÚBLICO REPÚBLICA DEMOCRÁTICA DE TIMOR LESTE Avenida Cidade de Lisboa, Dili, Timor Leste Phone: +670 - 77305782	 ANGEL'AQUIRA Consultant, Unipessoal Lda. Architectural & Engineering Design, Supervision and Project Management Vila Verde, Dili, Timor - Leste, Phone: +670 - 7238140 E-mail: ino_neves@yahoo.com	REHABILITAÇÃO DE ABRIGUS DA RESISTÊNCIA	REMOVE AND REPLACE CEILING	DRAWING BY:	APPROVED BY:	APPROVED BY:	17 OF 29				
		ABRIGU FATU META		Arch. Aquilino F. das Neves	Eng. Jesuino J.X. Neves	Sr. Hamar Antoninho Baptista Alves Director e Presidente AMRT					
		FATU META, DILI TIMOR LESTE									
		LOCATION : DILI	SCALE : 1:1500	DATE :	DATE :	DATE :	VERIFIED BY:	DATE	APPROVED BY:	DATE	DRAWING NO:
							Eng. Octavio P. Marques, M.Eng. HEAD OF PROJECT DEPARTMENT		Arch. Rosa Amaral Vong Directress of DNE		ARCH 17 OF 29

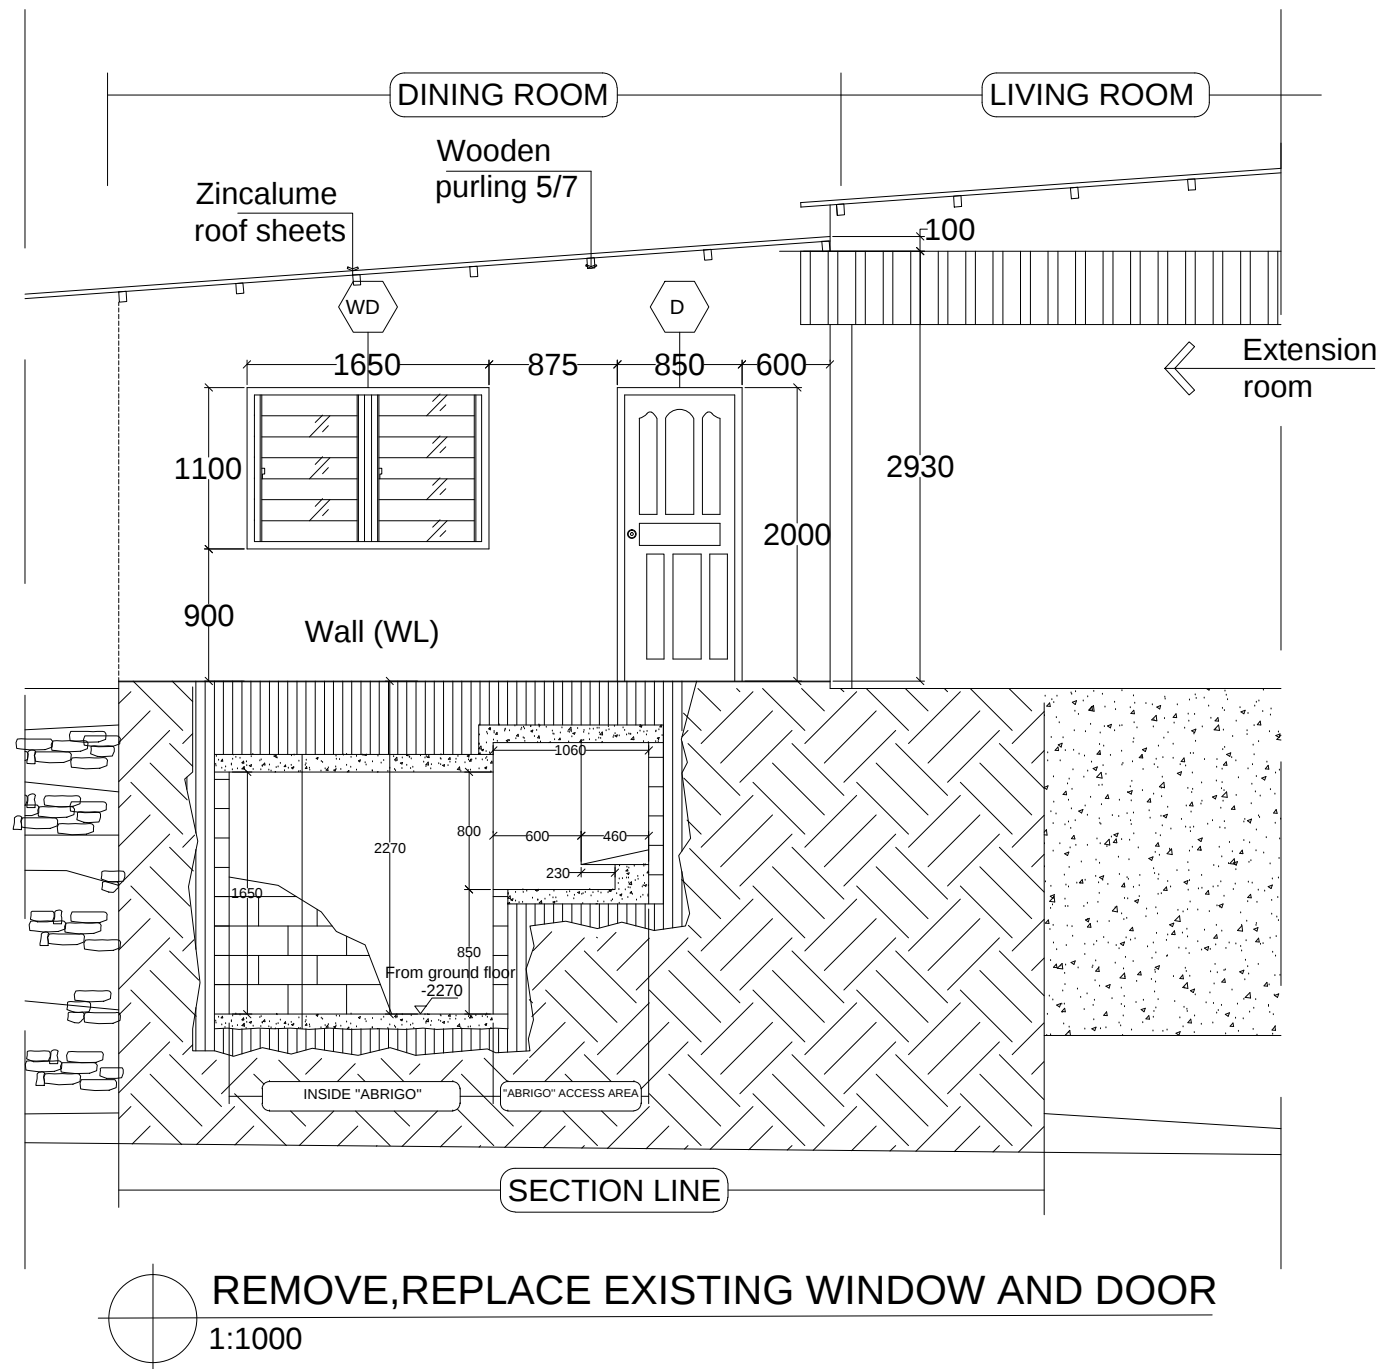

REHABILITATION ITEM
FOR "ABRIGU" FATU META
TIMOR LESTE


NO	ITEM
1.	Remove and replace roof sheets RS (dining room)
2.	Remove and replace ceoling
3.	Remove and replace window (WD)
4.	Remove and replace door (D)
5.	Remove and replace wall (WL)
6.	Remove and replace ground floor (dining room)
7.	Remove and replace beam under (WL)
8.	New foundation, column, top beam "abrigu"
9.	Remove and replace "abrigu" top deck
10.	Remove and replace wall block (CHB wall) W1,W2,W3,W4
11.	Remove and replace electricity instalation

NOTE:
Remove and replace existension window and door


CLIENT / PROJECT OWNER  ARQUIVO & MUSEU RESISTÊNCIA TIMORENSE INSTITUTO PÚBLICO REPÚBLICA DEMOCRÁTICA DE TIMOR LESTE Avenida Cidade de Lisboa, Dili, Timor Leste Phone: +670 - 77305782	PREPARED BY  ANGEL AQUIRA Consultant, Unipessoal Lda. Architectural & Engineering Design, Supervision and Project Management Vila Verde, Dili, Timor - Leste, Phone: +670 - 7238140 E-mail: ino_neves@yahoo.com	PROJECT TITLE REHABILITAÇÃO DE ABRIGUS DA RESISTÊNCIA ABRIGU FATU META FATU META, DILI TIMOR LESTE LOCATION : DILI	DRAWING TITLE REMOVE AND REPLACE EXISTING WINDOW AND ROOF SCALE : 1:1000	CONSULTANT DESIGN: A3R CONSULTANT		PROJECT OWNER  DEMOCRATIC REPUBLIC OF TIMOR LESTE MINISTRY OF PUBLIC WORK, TRANSPORT AND COMMUNICATION GENERAL DIRECTORATE OF PUBLIC WORKS NATIONAL DIRECTORATE OF BUILDING VERIFIED BY: DATE APPROVED BY: DATE Eng. Octavio P. Marques, M.Eng. HEAD OF PROJECT DEPARTMENT Arch. Rosa Amaral Vong Directress of DNE	SHEET NO: 18 OF 29 DRAWING NO: ARCH 18 OF 29
				DRAWING BY:	APPROVED BY:		
				Arch. Aquilino F. das Neves	Eng. Jesuino J.X. Neves		

REHABILITATION ITEM FOR "ABRIGU" FATU META
TIMOR LESTE

NO	ITEM	4. Remove and replace wall (WL)	7. New foundation, column, top beam "abrigu"
1.	Remove and replace roof sheets RS (dining room)	5. Remove and replace ground floor (dining room)	8. Remove and replace "abrigu" top deck
2.	Remove and replace window (WD)	6. Remove and replace beam under (WL)	9. Remove and replace wall block (CHB wall) W1,W2,W3,W4
3.	Remove and replace door (D)		10. Remove and replace electricity instalation

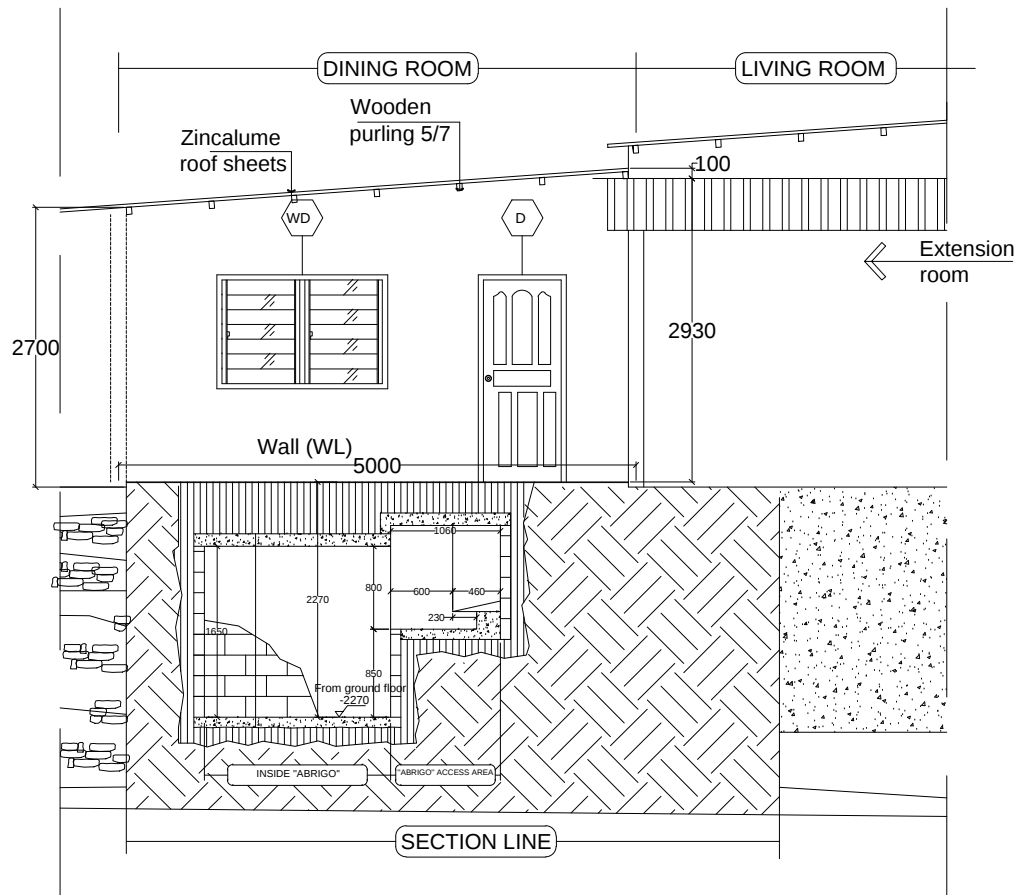

WALL (WL)

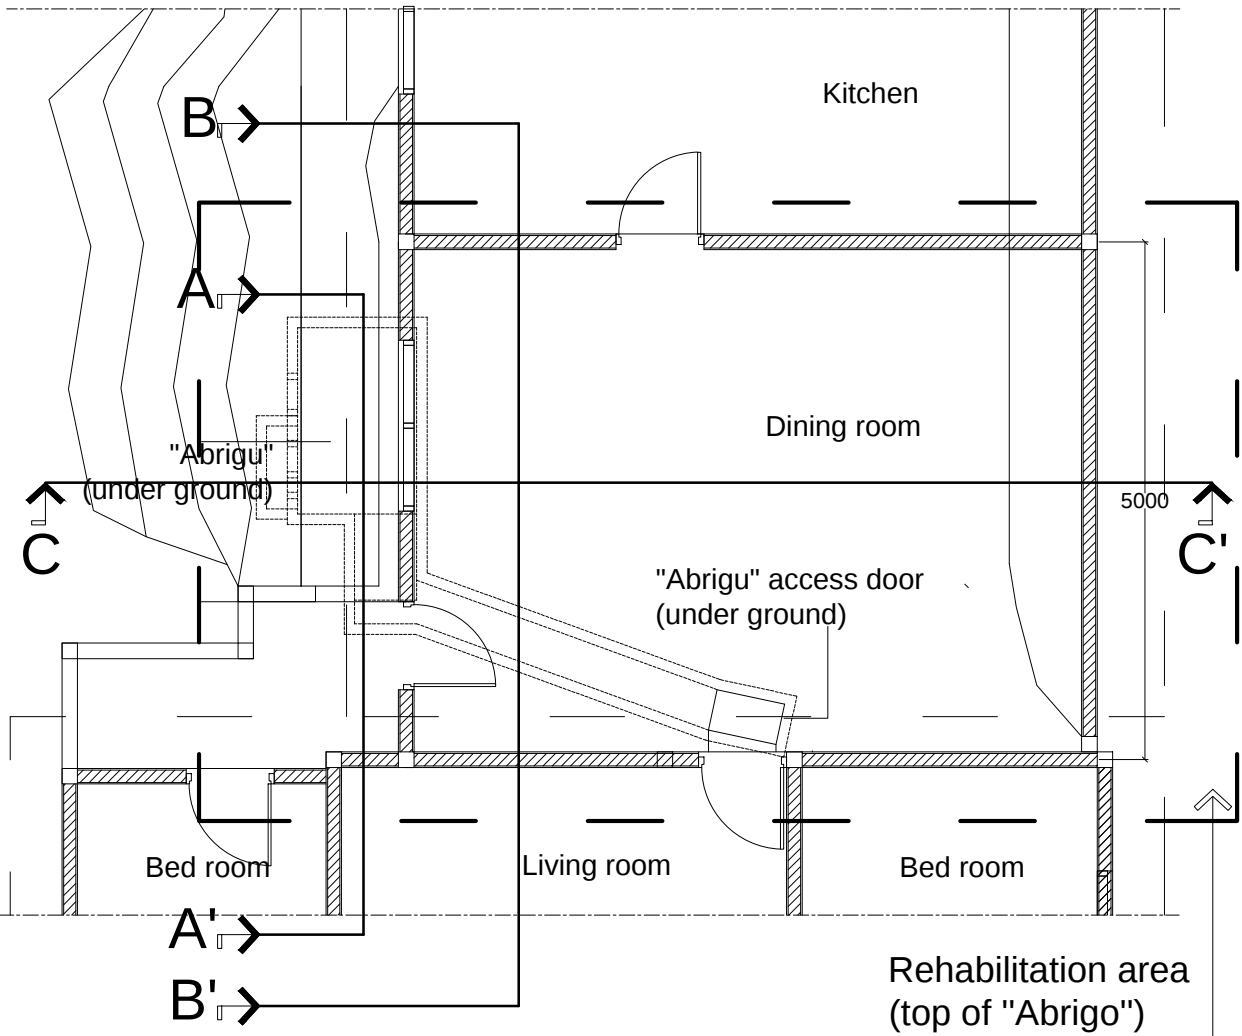

REHABILITATION PLAN




REMOVE AND REPLACE WALL (WL)

1:1500


CLIENT / PROJECT OWNER  ARQUIVO & MUSEU RESISTÊNCIA TIMORENSE INSTITUTO PÚBLICO REPÚBLICA DEMOCRÁTICA DE TIMOR LESTE Avenida Cidade de Lisboa, Dili, Timor Leste Phone: +670 - 77305782	PREPARED BY  ANGEL'AQUIRA Consultant, Unipessoal Lda. Architectural & Engineering Design, Supervision and Project Management Vila Verde, Dili, Timor - Leste, Phone: +670 - 7238140 E-mail: ino_neves@yahoo.com	PROJECT TITLE REHABILITAÇÃO DE ABRIGUS DA RESISTÊNCIA ABRIGU FATU META FATU META, DILI TIMOR LESTE LOCATION : DILI	DRAWING TITLE REMOVE AND REPLACE WALL SCALE : 1:1500	CONSULTANT DESIGN: A3R CONSULTANT		PROJECT OWNER APPROVED BY: Sr. Hamar Antoninho Baptista Alves Director e Presidente AMRT	DEMOCRATIC REPUBLIC OF TIMOR LESTE MINISTRY OF PUBLIC WORK, TRANSPORT AND COMMUNICATION GENERAL DIRECTORATE OF PUBLIC WORKS NATIONAL DIRECTORATE OF BUILDING				SHEET NO: 19 OF 29 DRAWING NO: ARCH 19 OF 29
				DRAWING BY:	APPROVED BY:		VERIFIED BY:	DATE	APPROVED BY:	DATE	
				Arch. Aquilino F. das Neves	Eng. Jesuino J.X. Neves		Eng. Octavio P. Marques, M.Eng. HEAD OF PROJECT DEPARTMENT		Arch. Rosa Amaral Vong Directress of DNE		

REHABILITATION ITEM FOR "ABRIGU" FATU META
TIMOR LESTE

NO	ITEM		
1.	Remove and replace roof sheets RS (dining room)	5.	Remove and replace wall (WL)
2.	Remove and replace ceiling	6.	Remove and replace ground floor (dining room)
3.	Remove and replace window (WD)	7.	Remove and replace beam under (WL)
4.	Remove and replace door (D)	8.	New foundation, column, top beam "abrigu"
		9.	Remove and replace "abrigu" top deck
		10.	Remove and replace wall block (CHB wall) W1,W2,W3,W4
		11.	Remove and replace electricity instalation

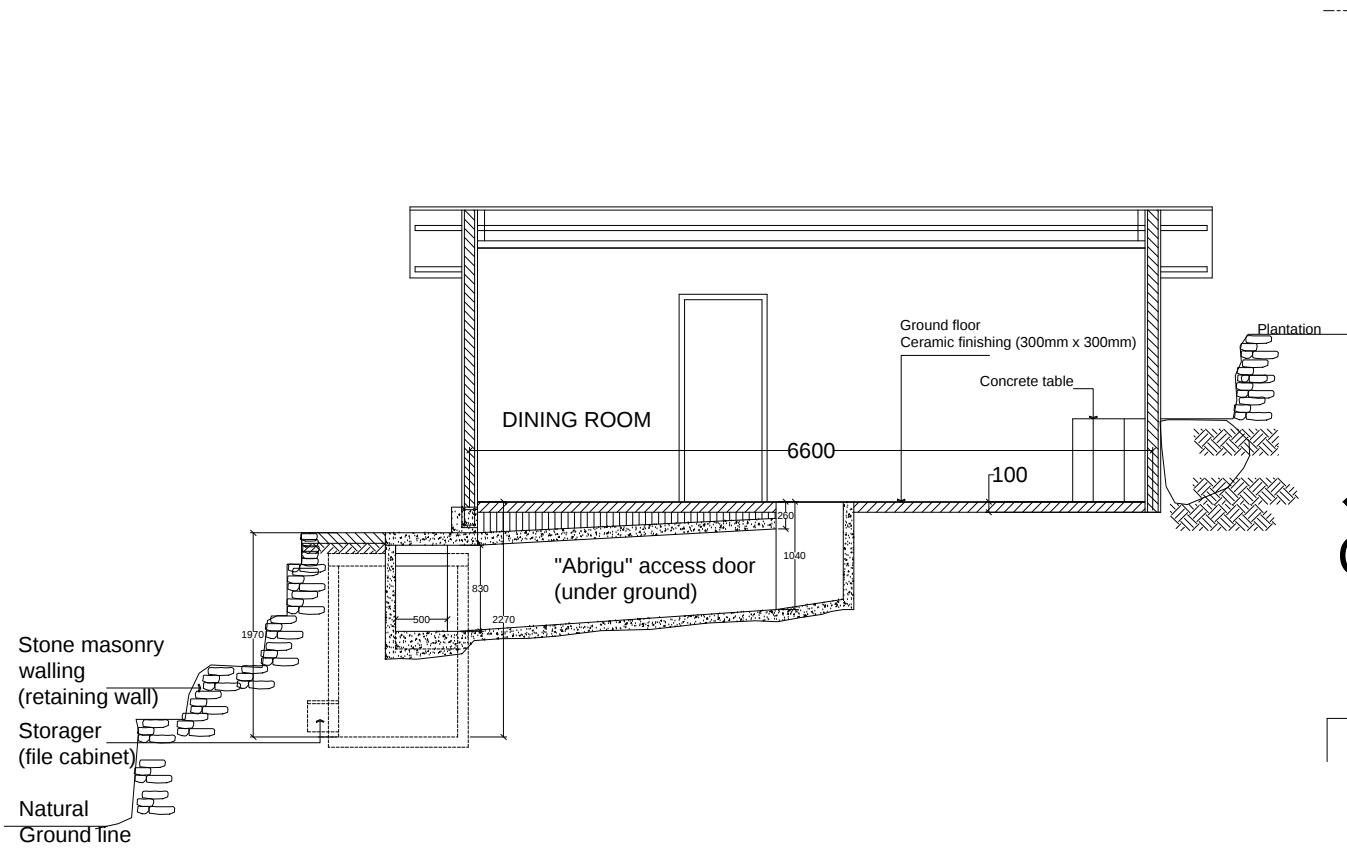

SECTION H-H

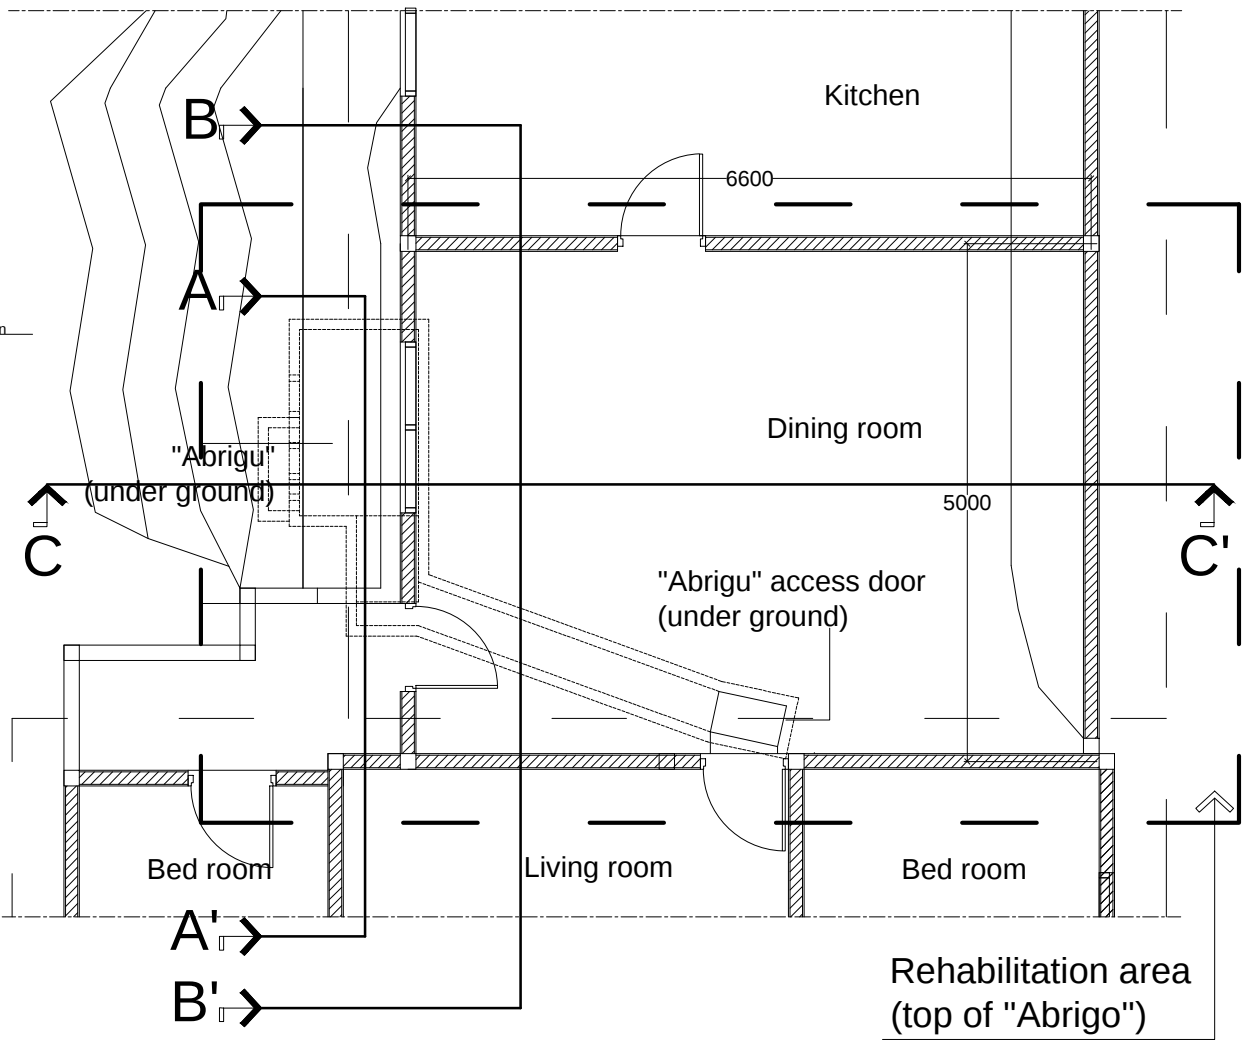

REHABILITATION PLAN





REMOVE AND REPLACE GROUND FLOOR
1:1500

CLIENT / PROJECT OWNER		PREPARED BY	PROJECT TITLE	DRAWING TITLE	CONSULTANT DESIGN: A3R CONSULTANT		PROJECT OWNER		DEMOCRATIC REPUBLIC OF TIMOR LESTE				SHEET NO:
 ARQUIVO & MUSEU RESISTÊNCIA TIMORENSE INSTITUTO PÚBLICO REPÚBLICA DEMOCRÁTICA DE TIMOR LESTE Avenida Cidade de Lisboa, Dili, Timor Leste Phone: +670 - 77305782		 ANGEL'AQUIRA Consultant, Unipessoal Lda. Architectural & Engineering Design, Supervision and Project Management Vila Verde, Dili, Timor - Leste, Phone: +670 - 7238140 E-mail: ino_neves@yahoo.com	REHABILITAÇÃO DE ABRIGUS DA RESISTÊNCIA ABRIGU FATU META FATU META, DILI TIMOR LESTE	REMOVE ANDE REPLACE GROUND FLOOR	DRAWING BY:		APPROVED BY:		APPROVED BY:		 MINISTRY OF PUBLIC WORK, TRANSPORT AND COMMUNICATION GENERAL DIRECTORATE OF PUBLIC WORKS NATIONAL DIRECTORATE OF BUILDING		20 OF 29
					Arch. Aquilino F. das Neves	Eng. Jesuino J.X. Neves	Sr. Hamar Antoninho Baptista Alves Director e Presidente AMRT						
								VERIFIED BY:	DATE	APPROVED BY:	DATE	Eng. Octavio P. Marques, M.Eng. HEAD OF PROJECT DEPARTMENT	Arch. Rosa Amaral Vong Directress of DNE
			LOCATION : DILI	SCALE : 1:1500	DATE :	DATE :	DATE :						

REHABILITATION ITEM FOR "ABRIGU" FATU META
TIMOR LESTE

NO	ITEM	5.	Remove and replace wall (WL)	8.	New foundation, column, top beam "abrigo"
1.	Remove and replace roof sheets (dining room)	6.	Remove and replace ground floor (dining room)	9.	Remove and replace "abrigo" top deck
2.	Remove and replace ceiling			10.	Remove and replace wall block (CHB wall) W1,W2,W3,W4
3.	Remove and replace window (WD)	7.	Remove and replace beam under (WL)	11.	Remove and replace electricity instalation
4.	Remove and replace door (D)				

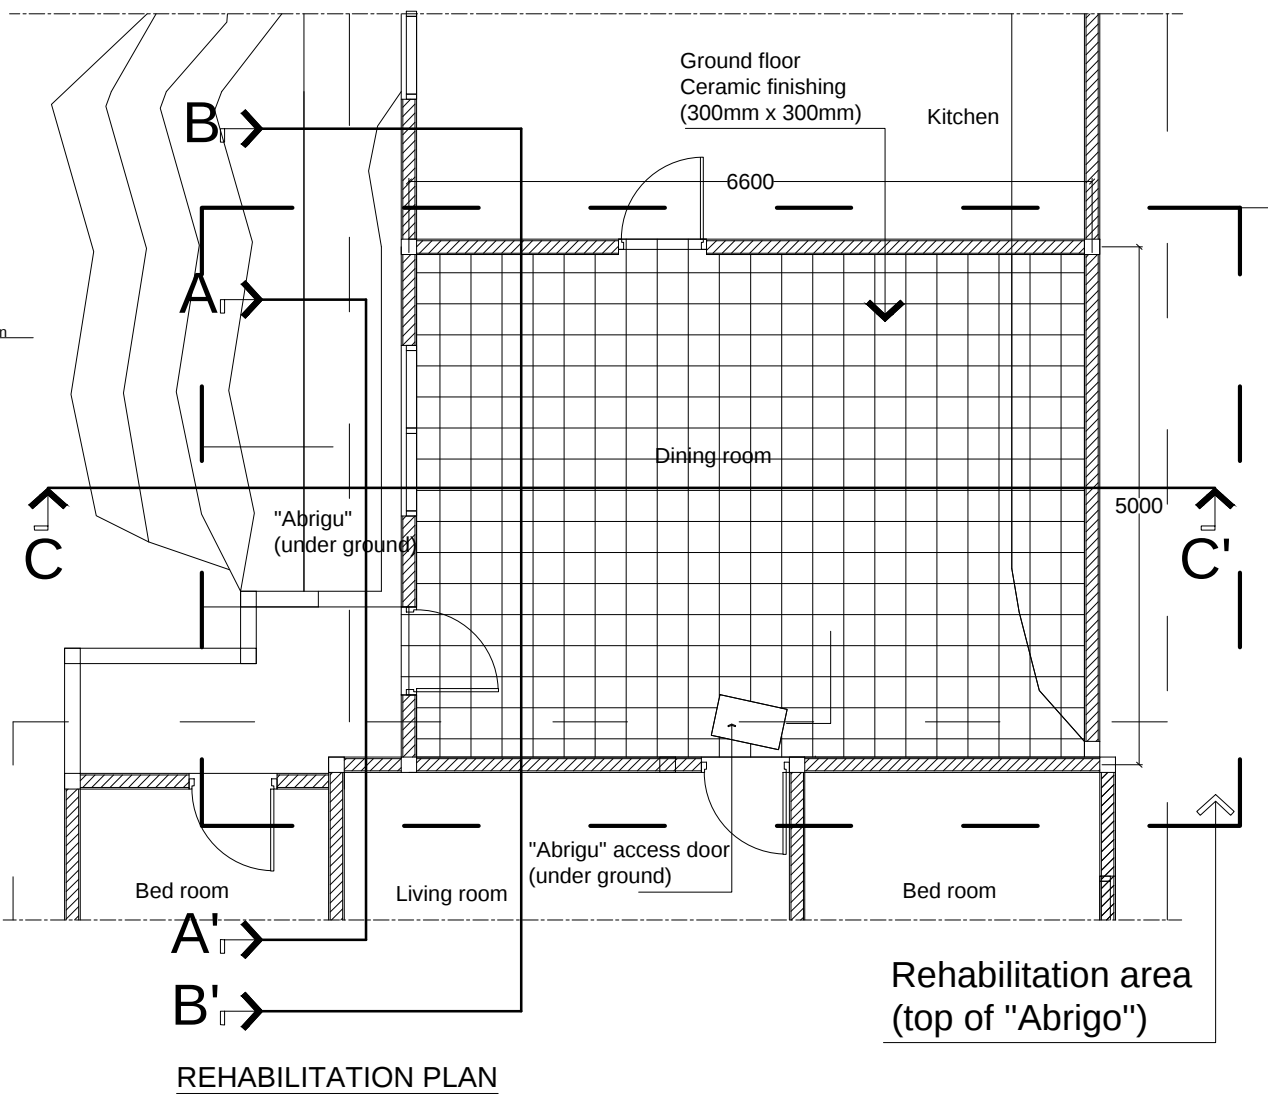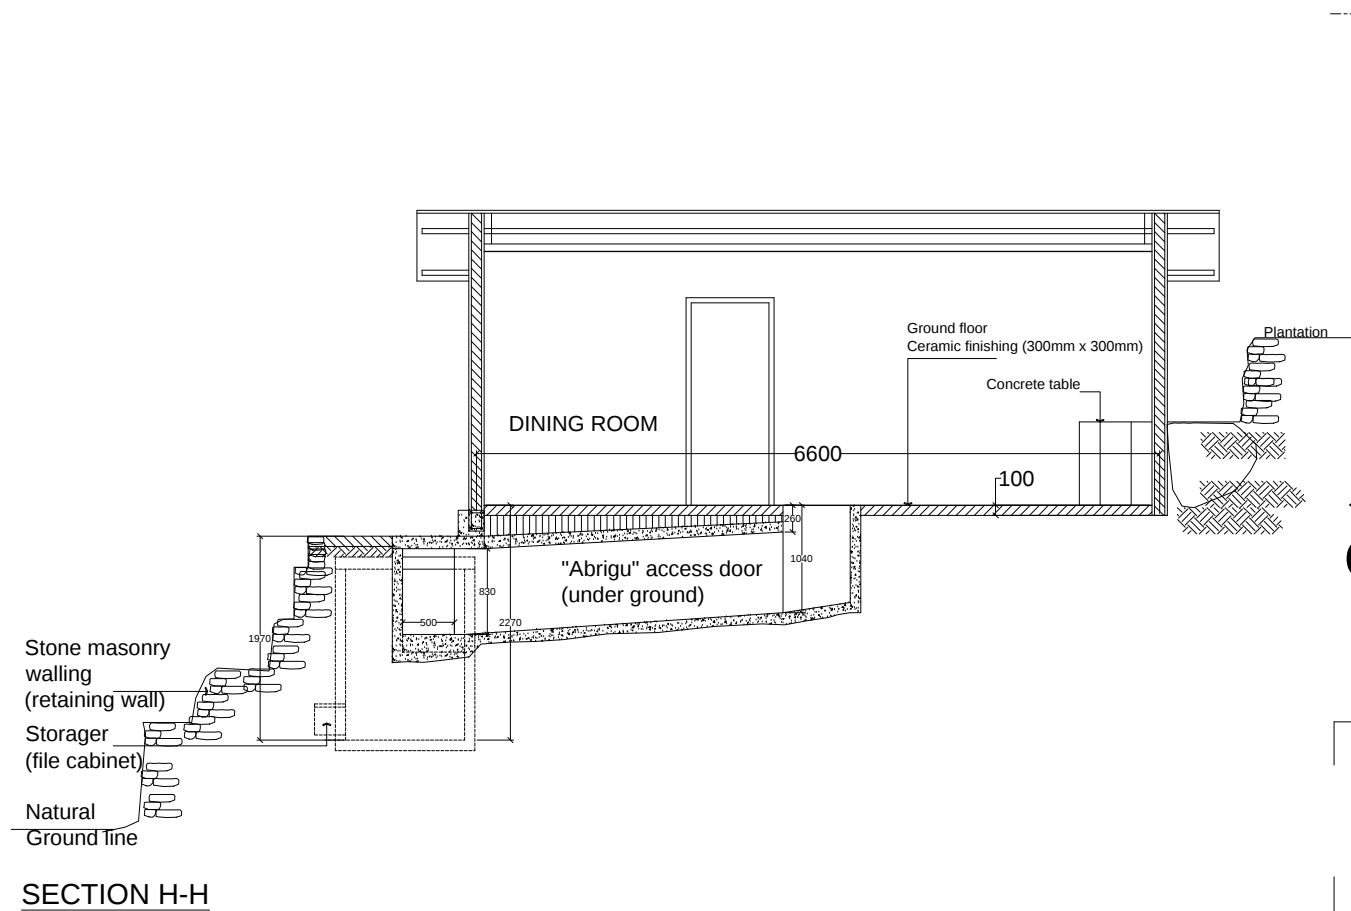


FLOOR PLAN (CERAMIC)
1:1500


CLIENT / PROJECT OWNER	PREPARED BY	PROJECT TITLE	DRAWING TITLE	CONSULTANT DESIGN: A3R CONSULTANT		PROJECT OWNER		 DEMOCRATIC REPUBLIC OF TIMOR LESTE MINISTRY OF PUBLIC WORK, TRANSPORT AND COMMUNICATION GENERAL DIRECTORATE OF PUBLIC WORKS NATIONAL DIRECTORATE OF BUILDING	SHEET NO:		
 ARQUIVO & MUSEU RESISTÊNCIA TIMORENSE INSTITUTO PÚBLICO REPÚBLICA DEMOCRÁTICA DE TIMOR LESTE Avenida Cidade de Lisboa, Dili, Timor Leste Phone: +670 - 77305782	 ANGEL'AQUIRA Consultant, Unipessoal Lda. Architectural & Engineering Design, Supervision and Project Management Vila Verde, Dili, Timor - Leste, Phone: +670 - 7238140 E-mail: ino_neves@yahoo.com	REHABILITAÇÃO DE ABRIGUS DA RESISTÊNCIA	FLOOR PLAN	DRAWING BY:	APPROVED BY:	APPROVED BY:	21 OF 29				
		ABRIGU FATU META		Arch. Aquilino F. das Neves	Eng. Jesuino J.X. Neves	Sr. Hamar Antoninho Baptista Alves Director e Presidente AMRT	VERIFIED BY:		DATE	APPROVED BY:	DATE
		FATU META, DILI TIMOR LESTE					Eng. Octavio P. Marques, M.Eng. HEAD OF PROJECT DEPARTMENT		Arch. Rosa Amaral Vong Directress of DNE	DRAWING NO: ARCH 21 OF 29	
LOCATION : DILI		SCALE : 1:1500		DATE :	DATE :	DATE :					

REHABILITATION ITEM FOR "ABRIGU" FATU META
TIMOR LESTE

NO	ITEM		
1.	Remove and replace roof sheets RS (dining room)	5.	Remove and replace wall (WL)
2.	Remove and replace ciling	6.	Remove and replace ground floor (dining room)
3.	Remove and replace window (WD)	7.	Remove and replace beam under (WL)
4.	Remove and replace door (D)	8.	New foundation, column, top beam "abrigu"
		9.	Remove and replace "abrigu" top deck
		10.	Remove and replace wall block (CHB wall) W1,W2,W3,W4
		11.	Remove and replace electricity instalation

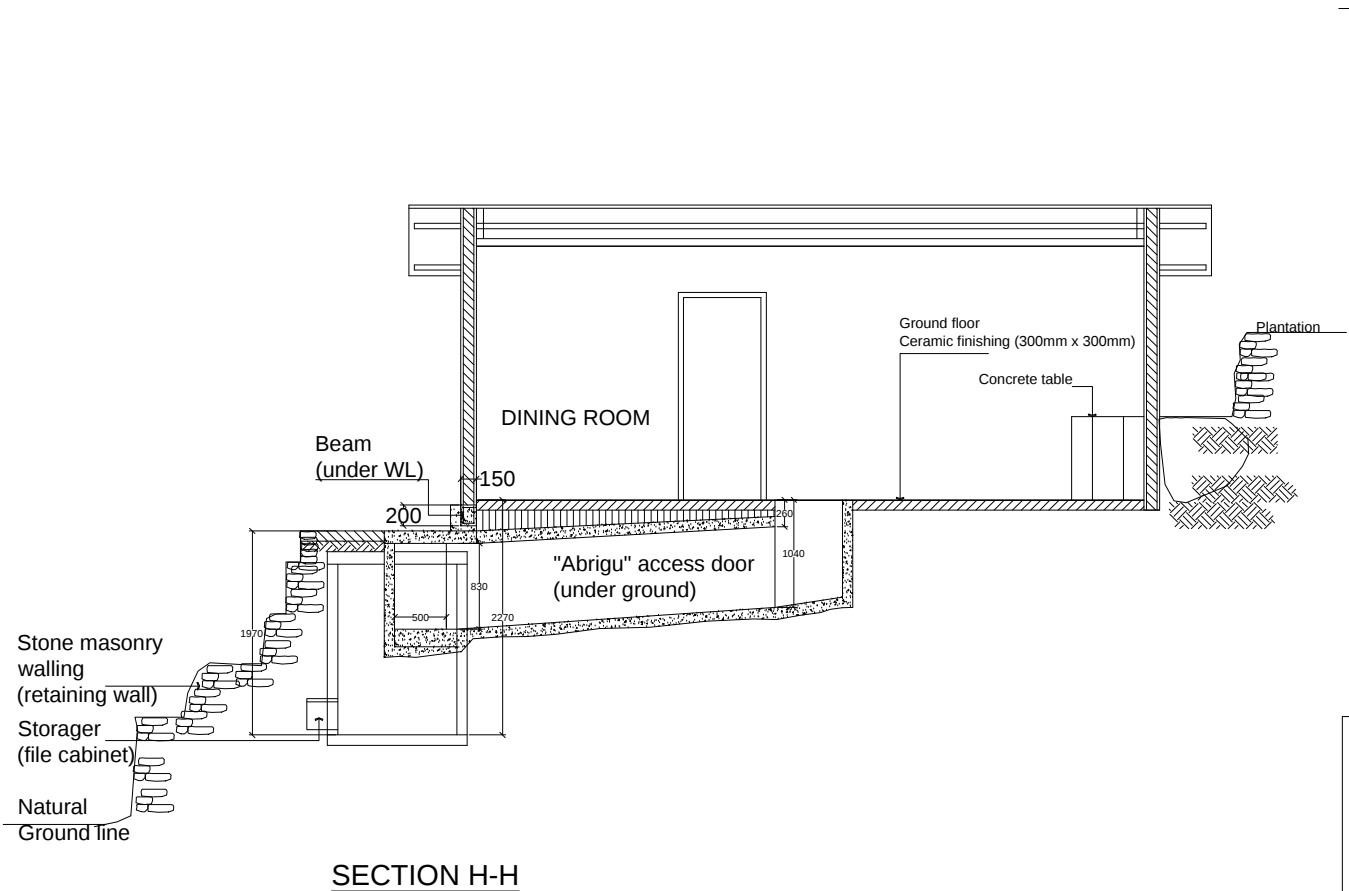

SECTION H-H

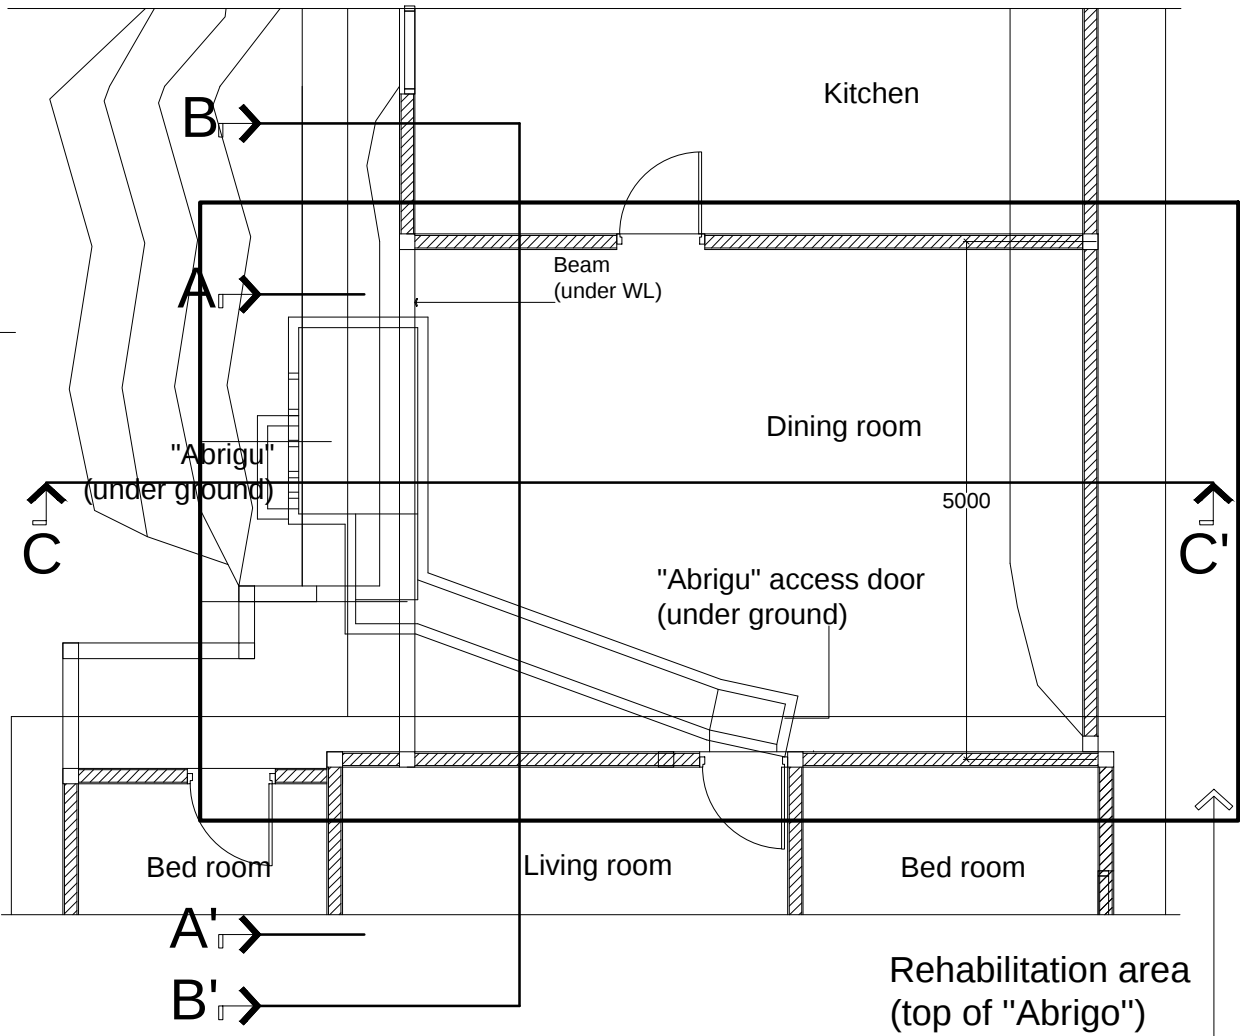

REHABILITATION PLAN


REMOVE AND REPLACE BEAM
1:1500

CLIENT / PROJECT OWNER		PREPARED BY	PROJECT TITLE	DRAWING TITLE	CONSULTANT DESIGN: A3R CONSULTANT		PROJECT OWNER	DEMOCRATIC REPUBLIC OF TIMOR LESTE				SHEET NO:
 ARQUIVO & MUSEU RESISTÊNCIA TIMORENSE INSTITUTO PÚBLICO REPÚBLICA DEMOCRÁTICA DE TIMOR LESTE Avenida Cidade de Lisboa, Dili, Timor Leste Phone: +670 - 77305782		 ANGEL'AQUIRA Consultant, Unipessoal Lda. Architectural & Engineering Design, Supervision and Project Management Vila Verde, Dili, Timor - Leste, Phone: +670 - 7238140 E-mail: ino_neves@yahoo.com	REHABILITAÇÃO DE ABRIGUS DA RESISTÊNCIA ABRIGU FATU META FATU META, DILI TIMOR LESTE	REMOVE AND REPLACE BEAM	DRAWING BY:	APPROVED BY:	APPROVED BY:	 MINISTRY OF PUBLIC WORK, TRANSPORT AND COMMUNICATION GENERAL DIRECTORATE OF PUBLIC WORKS NATIONAL DIRECTORATE OF BUILDING				22 OF 29
					Arch. Aquilino F. das Neves	Eng. Jesuino J.X. Neves	Sr. Hamar Antoninho Baptista Alves Director e Presidente AMRT	VERIFIED BY:	DATE	APPROVED BY:	DATE	
			LOCATION : DILI	SCALE : 1:1500	DATE :	DATE :	DATE :	Eng. Octavio P. Marques, M.Eng. HEAD OF PROJECT DEPARTMENT		Arch. Rosa Amaral Vong Directress of DNE		DRAWING NO: ARCH 22 OF 29


REHABILITATION ITEM FOR "ABRIGU" FATU META
TIMOR LESTE

NO ITEM

- | | | |
|--|--|--|
| 1. Remove and replace roof sheets RS (dining room) | 5. Remove and replace wall (WL) | 8. New foundation, column, top beam "abrigu" |
| 2. Remove and replace ceiling | 6. Remove and replace ground floor (dining room) | 9. Remove and replace "abrigu" top deck |
| 3. Remove and replace window (WD) | 7. Remove and replace beam under (WL) | 10. Remove and replace wall block (CHB wall) W1,W2,W3,W4 |
| 4. Remove and replace door (D) | | 11. Remove and replace electricity instalation |

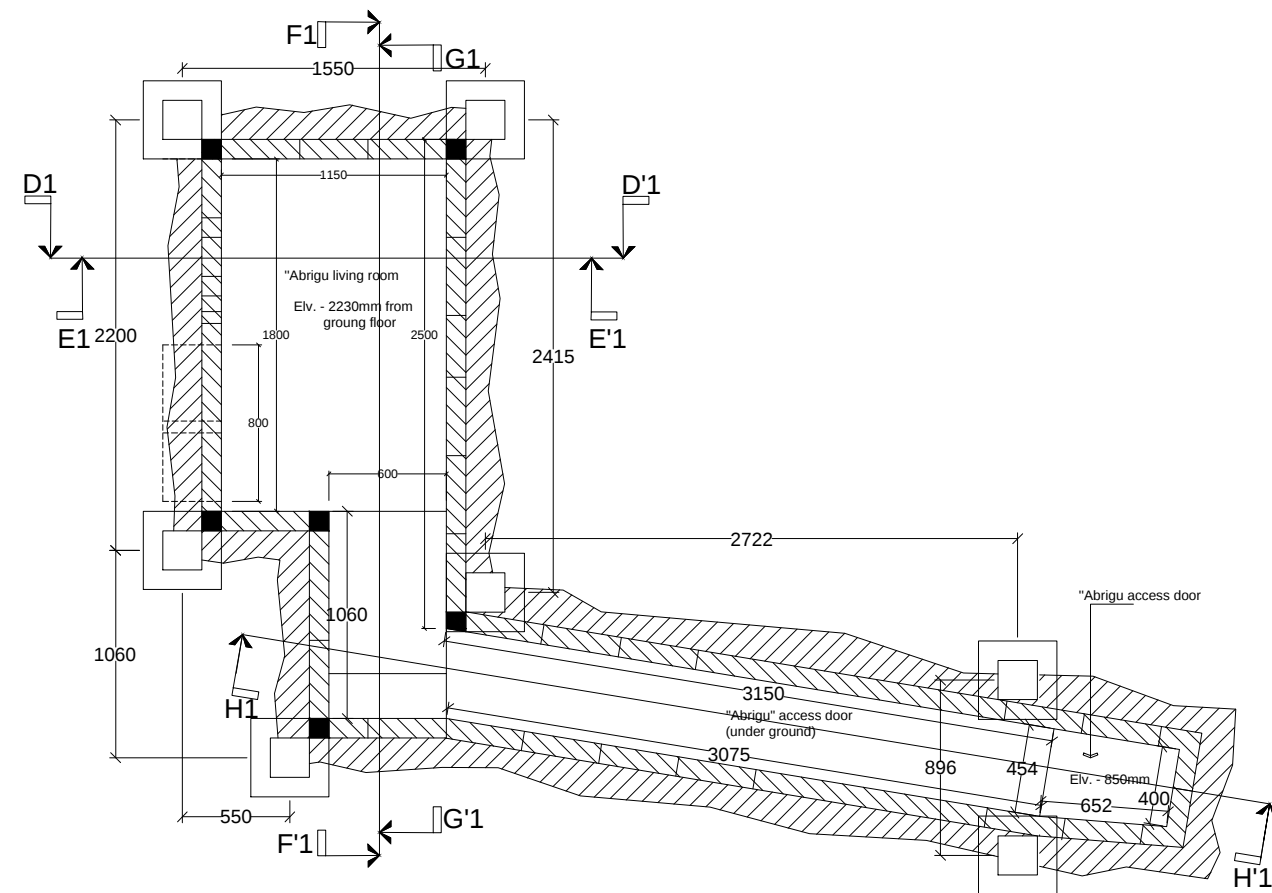

"ABRIGU" FOOT PLATE AND COLUMN PLAN

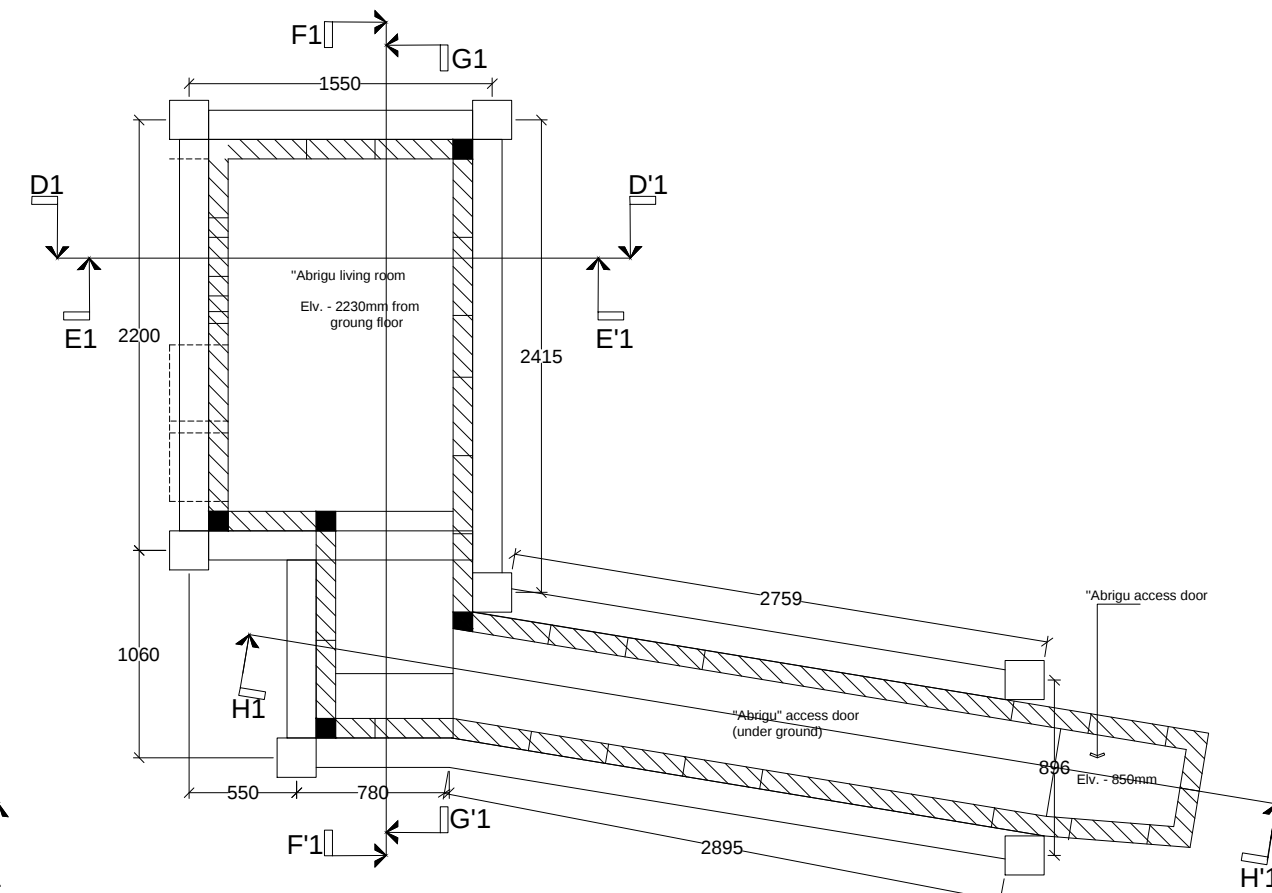

"ABRIGU" TOP BEAM PLAN




"ABRIGU" REINFORCEMENT PLAN

ARQUIVO & MUSEU RESISTÊNCIA TIMORENSE INSTITUTO PÚBLICO REPÚBLICA DEMOCRÁTICA DE TIMOR LESTE Avenida Cidade de Lisboa, Dili, Timor Leste Phone: +670 - 77305782	ANGEL'AQUIRA Consultant, Unipessoal Lda. Architectural & Engineering Design, Supervision and Project Management Vila Verde, Dili, Timor - Leste, Phone: +670 - 7238140 E-mail: ino_neves@yahoo.com	PROJECT TITLE REHABILITAÇÃO DE ABRIGUS DA RESISTÊNCIA ABRIGU FATU META FATU META, DILI TIMOR LESTE LOCATION : DILI	DRAWING TITLE "ABRIGU" REINFORCEMENT PLAN SCALE : 1:1000	CONSULTANT DESIGN: A3R CONSULTANT		PROJECT OWNER APPROVED BY: Sr. Hamar Antoninho Baptista Alves Director e Presidente AMRT DATE :	DEMOCRATIC REPUBLIC OF TIMOR LESTE MINISTRY OF PUBLIC WORK, TRANSPORT AND COMMUNICATION GENERAL DIRECTORATE OF PUBLIC WORKS NATIONAL DIRECTORATE OF BUILDING VERIFIED BY: DATE APPROVED BY: DATE Eng. Octavio P. Marques, M.Eng. HEAD OF PROJECT DEPARTMENT Arch. Rosa Amaral Vong Directress of DNE	SHEET NO: 23 OF 29 DRAWING NO: ARCH 23 OF 29
				DRAWING BY:	APPROVED BY:			
				Arch. Aquilino F. das Neves	Eng. Jesuino J.X. Neves			

REHABILITATION ITEM FOR "ABRIGU" FATU META
TIMOR LESTE

NO	ITEM
1.	Remove and replace roof sheets RS (dining room)
2.	Remove and replace ceiling
3.	Remove and replace window (WD)
4.	Remove and replace door (D)
5.	Remove and replace wall (WL)
6.	Remove and replace ground floor (dining room)
7.	Remove and replace beam under (WL)
8.	New foundation, column, top beam "abrigo"
9.	Remove and replace "abrigo" top deck
10.	Remove and replace wall block (CHB wall) W1,W2,W3,W4
11.	Remove and replace electricity instalation

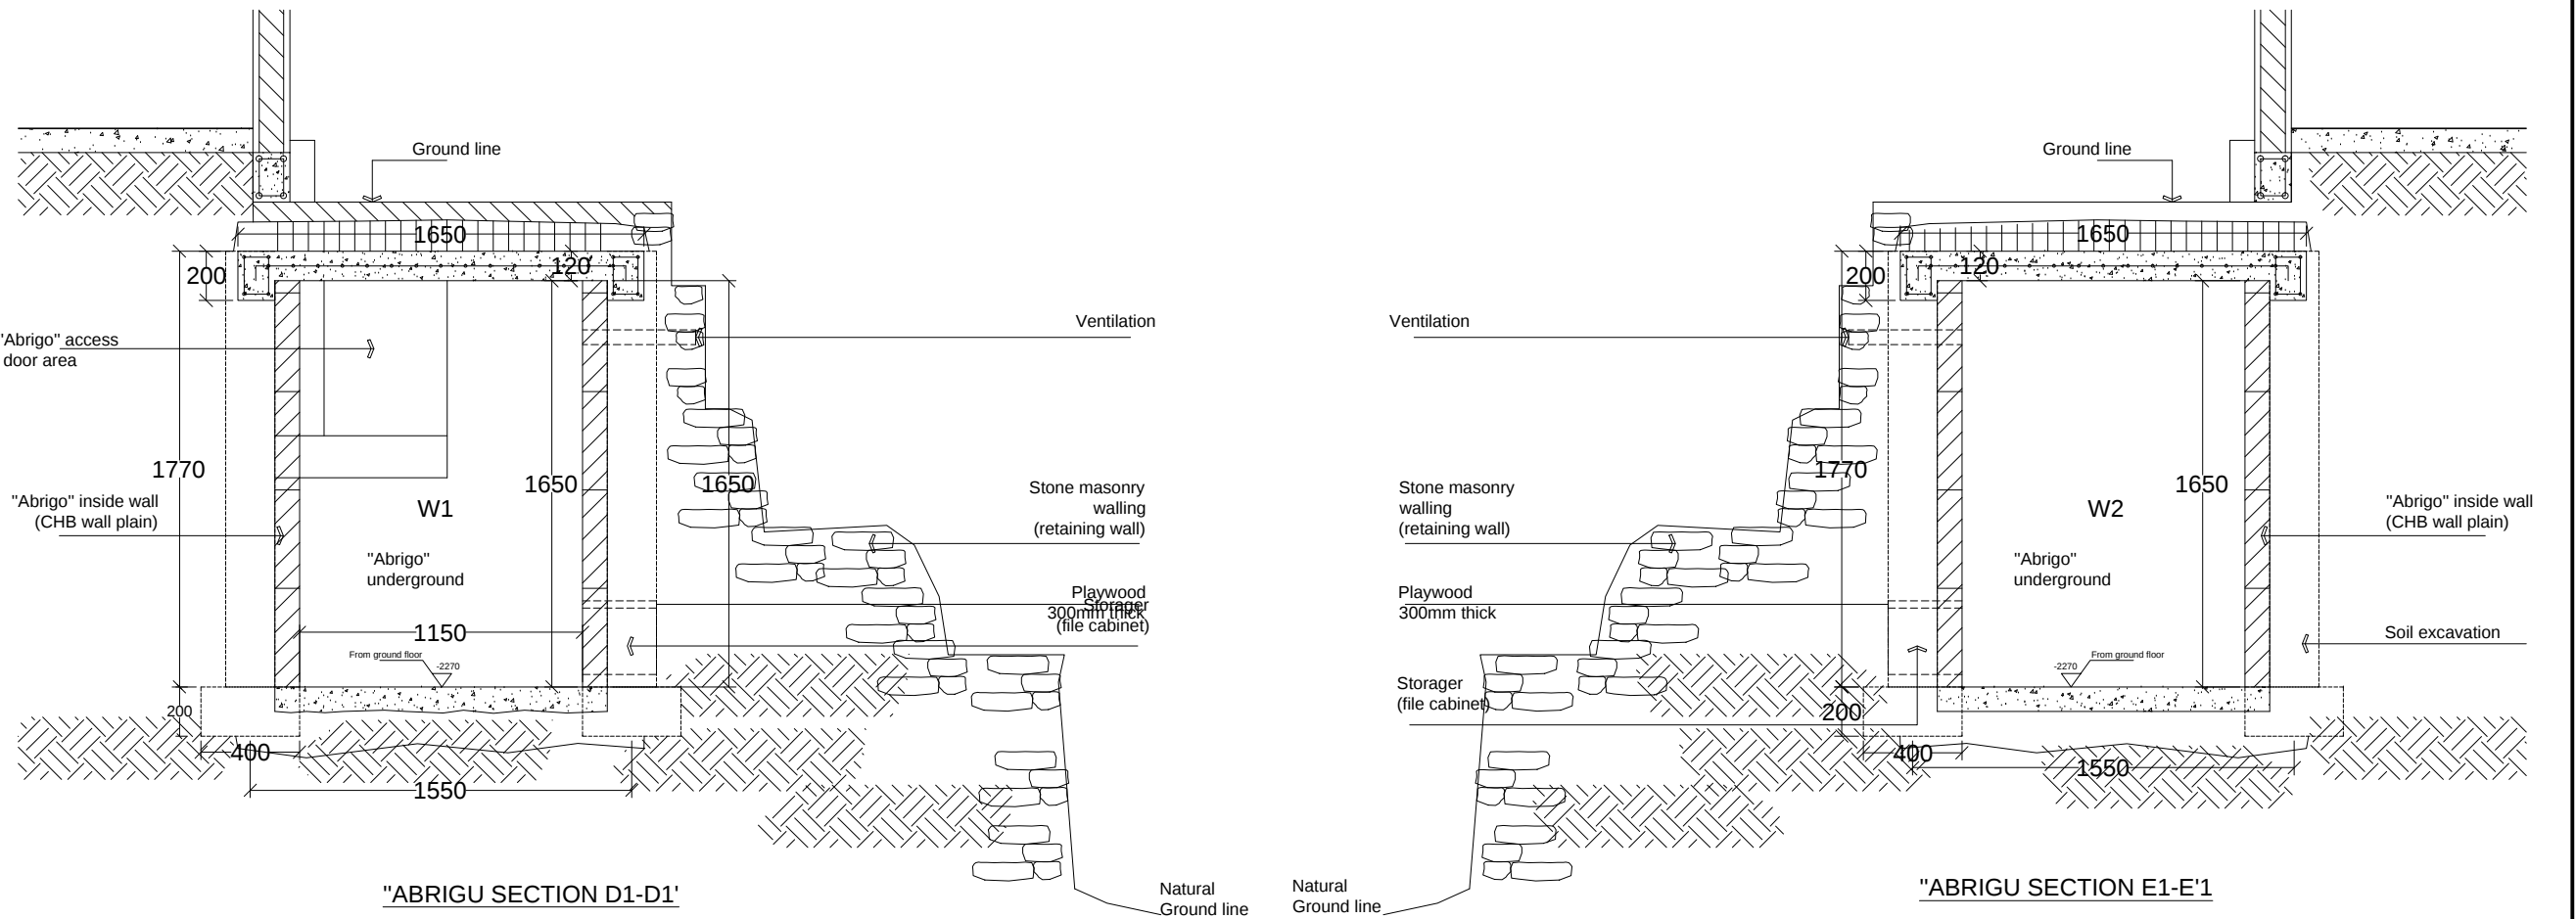

"ABRIGU" FOOTING, COLUMN BEAM, TOP DACK DETAILS
1:800

CLIENT / PROJECT OWNER	PREPARED BY	PROJECT TITLE	DRAWING TITLE	CONSULTANT DESIGN: A3R CONSULTANT	PROJECT OWNER	SHEET NO:
ARQUIVO & MUSEU RESISTÊNCIA TIMORENSE INSTITUTO PÚBLICO REPÚBLICA DEMOCRÁTICA DE TIMOR LESTE Avenida Cidade de Lisboa, Dili, Timor Leste Phone: +670 - 77305782	ANGEL'AQUIRA Consultant, Unipessoal Lda. Architectural & Engineering Design, Supervision and Project Management Vila Verde, Dili, Timor - Leste, Phone: +670 - 7238140 E-mail: ino_neves@yahoo.com	REHABILITAÇÃO DE ABRIGUS DA RESISTÊNCIA ABRIGU FATU META FATU META, DILI TIMOR LESTE	"ABRIGU" REINFORCEMENT LAY OUT	DRAWING BY: Arch. Aquilino F. das Neves	APPROVED BY: Eng. Jesuino J.X. Neves Sr. Hamar Antoninho Baptista Alves Director e Presidente AMRT	DEMOCRATIC REPUBLIC OF TIMOR LESTE MINISTRY OF PUBLIC WORK, TRANSPORT AND COMMUNICATION GENERAL DIRECTORATE OF PUBLIC WORKS NATIONAL DIRECTORATE OF BUILDING VERIFIED BY: DATE APPROVED BY: DATE Eng. Octavio P. Marques, M.Eng. HEAD OF PROJECT DEPARTMENT Arch. Rosa Amaral Vong Directress of DNE
		LOCATION : DILI	SCALE : 1:800	DATE :	DATE :	DATE :

DRAWING NO:
ARCH
24 OF 29

REHABILITATION ITEM FOR "ABRIGU" FATU META
TIMOR LESTE

NO ITEM

1. Remove and replace roof sheets RS (dining room)

2. Remove and replace ceiling


3. Remove and replace window (WD)

4. Remove and replace door (D)
5. Remove and replace wall (WL)


6. Remove and replace ground floor (dining room)

7. Remove and replace beam under (WL)

8. New foundation, column, top beam "abrigu"
9. Remove and replace "abrigu" top deck
10. Remove and replace wall block (CHB wall) W1,W2,W3,W4
11. Remove and replace electricity instalation

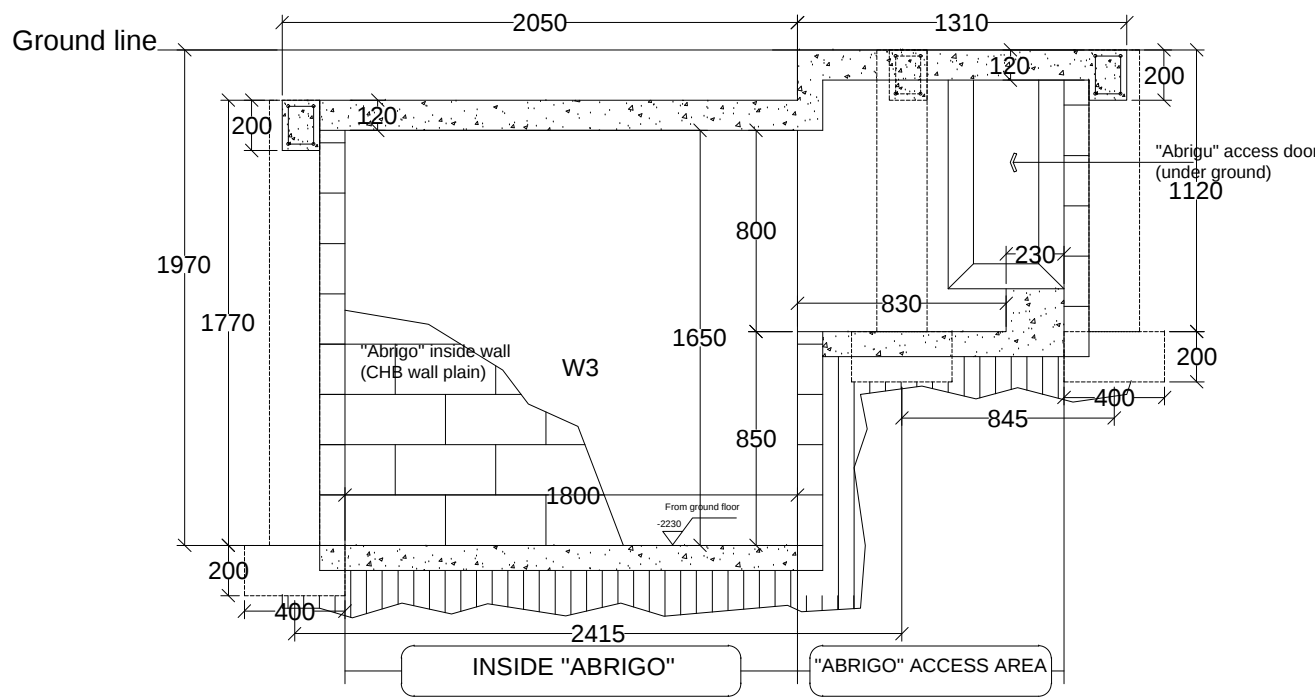

"ABRIGU SECTION F1-F'1
1:1000

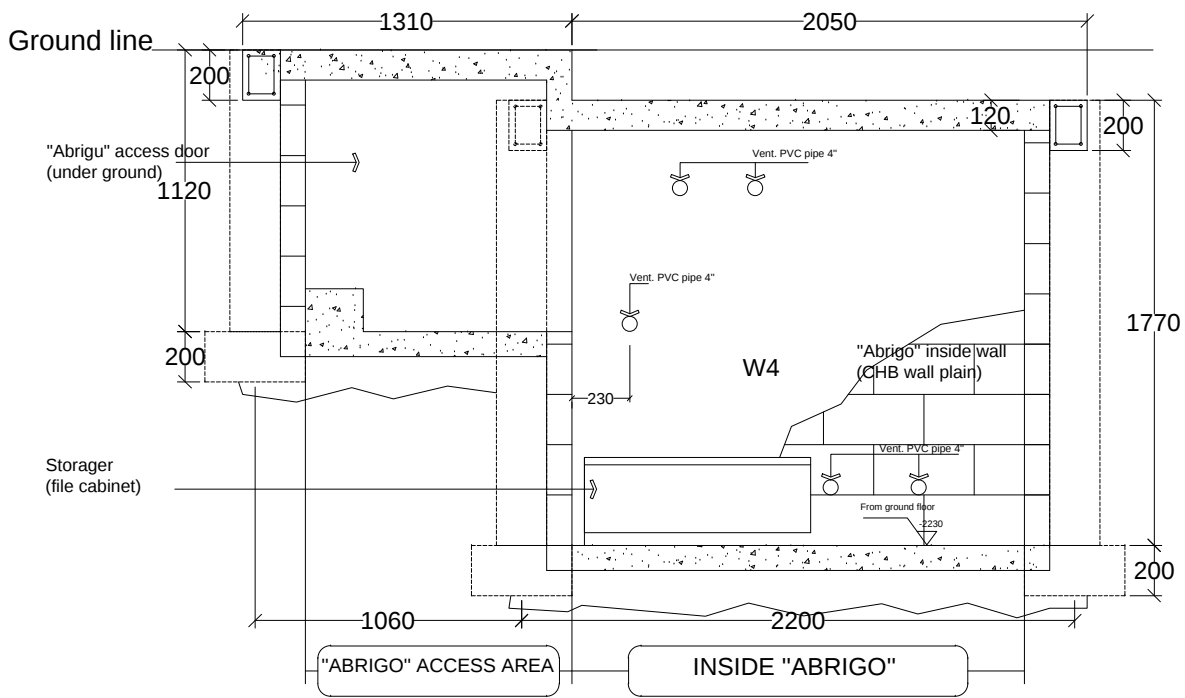


"ABRIGU SECTION G1-G'1
1:1000

"ABRIGU" FOOTING, COLUMN BEAM, TOP DACK DETAILS
1:800

CLIENT / PROJECT OWNER		PREPARED BY	PROJECT TITLE	DRAWING TITLE	CONSULTANT DESIGN: A3R CONSULTANT		PROJECT OWNER	DEMOCRATIC REPUBLIC OF TIMOR LESTE				SHEET NO:
 ARQUIVO & MUSEU RESISTÊNCIA TIMORENSE INSTITUTO PÚBLICO REPÚBLICA DEMOCRÁTICA DE TIMOR LESTE Avenida Cidade de Lisboa, Dili, Timor Leste Phone: +670 - 77305782		 ANGEL AQUIRA Consultant, Unipessoal Lda. Architectural & Engineering Design, Supervision and Project Management Vila Verde, Dili, Timor - Leste, Phone: +670 - 7238140 E-mail: ino_neves@yahoo.com	REHABILITAÇÃO DE ABRIGUS DA RESISTÊNCIA ABRIGU FATU META FATU META, DILI TIMOR LESTE LOCATION : DILI	"ABRIGU" REINFORCEMENT LAY OUT SCALE : 1:800	DRAWING BY:	APPROVED BY:	APPROVED BY:	 MINISTRY OF PUBLIC WORK, TRANSPORT AND COMMUNICATION GENERAL DIRECTORATE OF PUBLIC WORKS NATIONAL DIRECTORATE OF BUILDING				25 OF 29
					Arch. Aquilino F. das Neves	Eng. Jesuino J.X. Neves	Sr. Hamar Antoninho Baptista Alves Director e Presidente AMRT					
					DATE :	DATE :	DATE :	VERIFIED BY:	DATE	APPROVED BY:	DATE	DRAWING NO:
								Eng. Octavio P. Marques, M.Eng. HEAD OF PROJECT DEPARTMENT		Arch. Rosa Amaral Vong Directress of DNE		ARCH 25 OF 29


REHABILITATION ITEM FOR "ABRIGU" FATU META
TIMOR LESTE

- | | | | |
|----|---|--|--|
| NO | ITEM | 5. Remove and replace wall (WL) | 9. Remove and replace "abrigo" top deck |
| 1. | Remove and replace roof sheets RS (dining room) | 6. Remove and replace ground floor (dining room) | 10. Remove and replace wall block (CHB wall) W1,W2,W3,W4 |
| 2. | Remove and replace ceiling | 7. Remove and replace beam under (WL) | 11. Remove and replace electricity instalation |
| 3. | Remove and replace window (WD) | 8. New foundation, column, top beam "abrigo" | |
| 4. | Remove and replace door (D) | | |

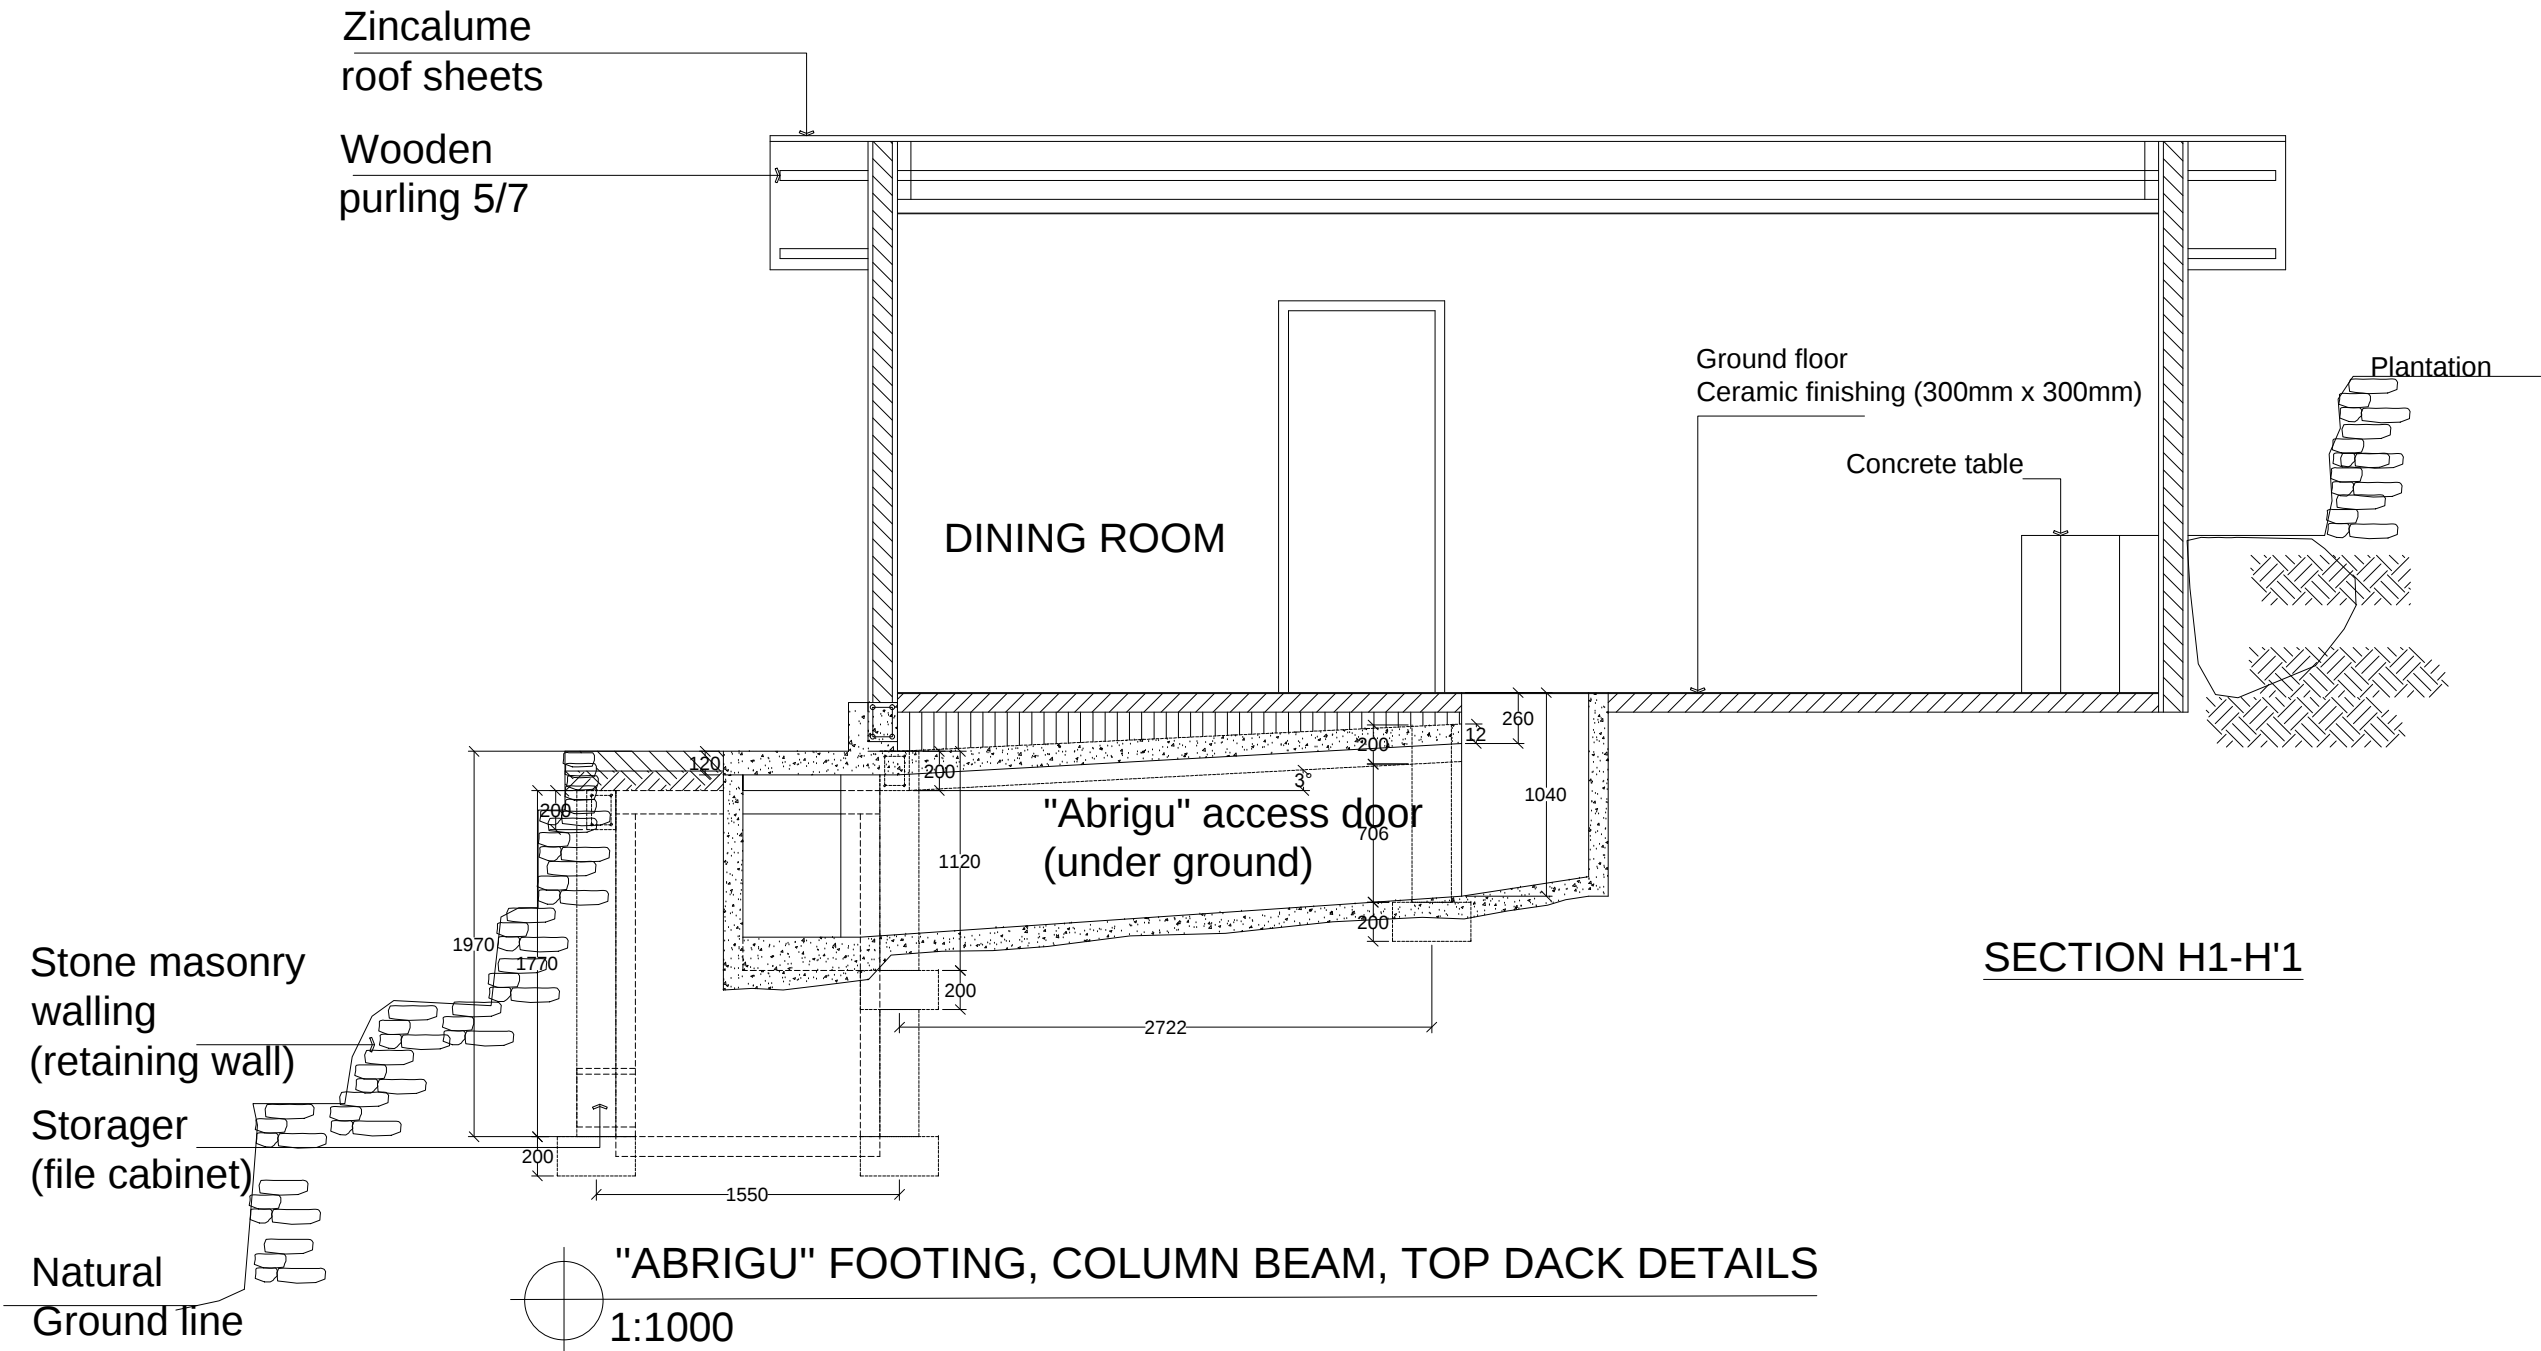

"ABRIGU" FOOTING, COLUMN BEAM, TOP DACK DETAILS
1:1000


CLIENT / PROJECT OWNER  ARQUIVO & MUSEU RESISTÊNCIA TIMORENSE INSTITUTO PÚBLICO REPÚBLICA DEMOCRÁTICA DE TIMOR LESTE Avenida Cidade de Lisboa, Dili, Timor Leste Phone: +670 - 77305782	PREPARED BY  ANGEL AQUIRA Consultant, Unipessoal Lda. Architectural & Engineering Design, Supervision and Project Management Vila Verde, Dili, Timor - Leste, Phone: +670 - 7238140 E-mail: ino_neves@yahoo.com	PROJECT TITLE REHABILITAÇÃO DE ABRIGOS DA RESISTÊNCIA ABRIGU FATU META FATU META, DILI TIMOR LESTE LOCATION : DILI	DRAWING TITLE "ABRIGU" REINFORCEMENT LAY OUT SCALE : 1:1000	CONSULTANT DESIGN: A3R CONSULTANT		PROJECT OWNER  DEMOCRATIC REPUBLIC OF TIMOR LESTE MINISTRY OF PUBLIC WORK, TRANSPORT AND COMMUNICATION GENERAL DIRECTORATE OF PUBLIC WORKS NATIONAL DIRECTORATE OF BUILDING VERIFIED BY: DATE APPROVED BY: DATE Eng. Octavio P. Marques, M.Eng. HEAD OF PROJECT DEPARTMENT	SHEET NO: 26 OF 29 DRAWING NO: ARCH 26 OF 29
				DRAWING BY:	APPROVED BY:		
				Arch. Aquilino F. das Neves	Eng. Jesuino J.X. Neves		

 [illegible]

- ## 11. Remove and replace electricity instalation



CLIENT / PROJECT OWNER		PREPARED BY		PROJECT TITLE		DRAWING TITLE		CONSULTANT DESIGN: A3R CONSULTANT		PROJECT OWNER		DEMOCRATIC REPUBLIC OF TIMOR LESTE MINISTRY OF PUBLIC WORK, TRANSPORT AND COMMUNICATION GENERAL DIRECTORATE OF PUBLIC WORKS NATIONAL DIRECTORATE OF BUILDING				SHEET NO:			
 ARQUIVO & MUSEU RESISTÊNCIA TIMORENSE INSTITUTO PÚBLICO REPÚBLICA DEMOCRÁTICA DE TIMOR LESTE Avenida Cidade de Lisboa, Dili, Timor Leste Phone: +670 - 77305782		 ANGEL/AQUIRA Consultancy, Unipessoal Lda. Architectural & Engineering Design, Supervision and Project Management Vila Verde, Dili, Timor - Leste. Phone: +670 - 7238140 E-mail: ino_neves@yahoo.com		REHABILITAÇÃO DE ABRIGOS DA RESISTÊNCIA ABRIGU FATU META FATU META, DILI TIMOR LESTE		"ABRIGU TOP DACK LAY OUT		DRAWING BY:		APPROVED BY:		APPROVED BY:		 Eng. Octavio P. Marques, M.Eng. HEAD OF PROJECT DEPARTMENT		Arch. Rosa Amaral Vong Directress of DNE		DRAWING NO: ARCH 27 OF 29	
				LOCATION : DILI		SCALE : 1:500		DATE :		DATE :		DATE :							

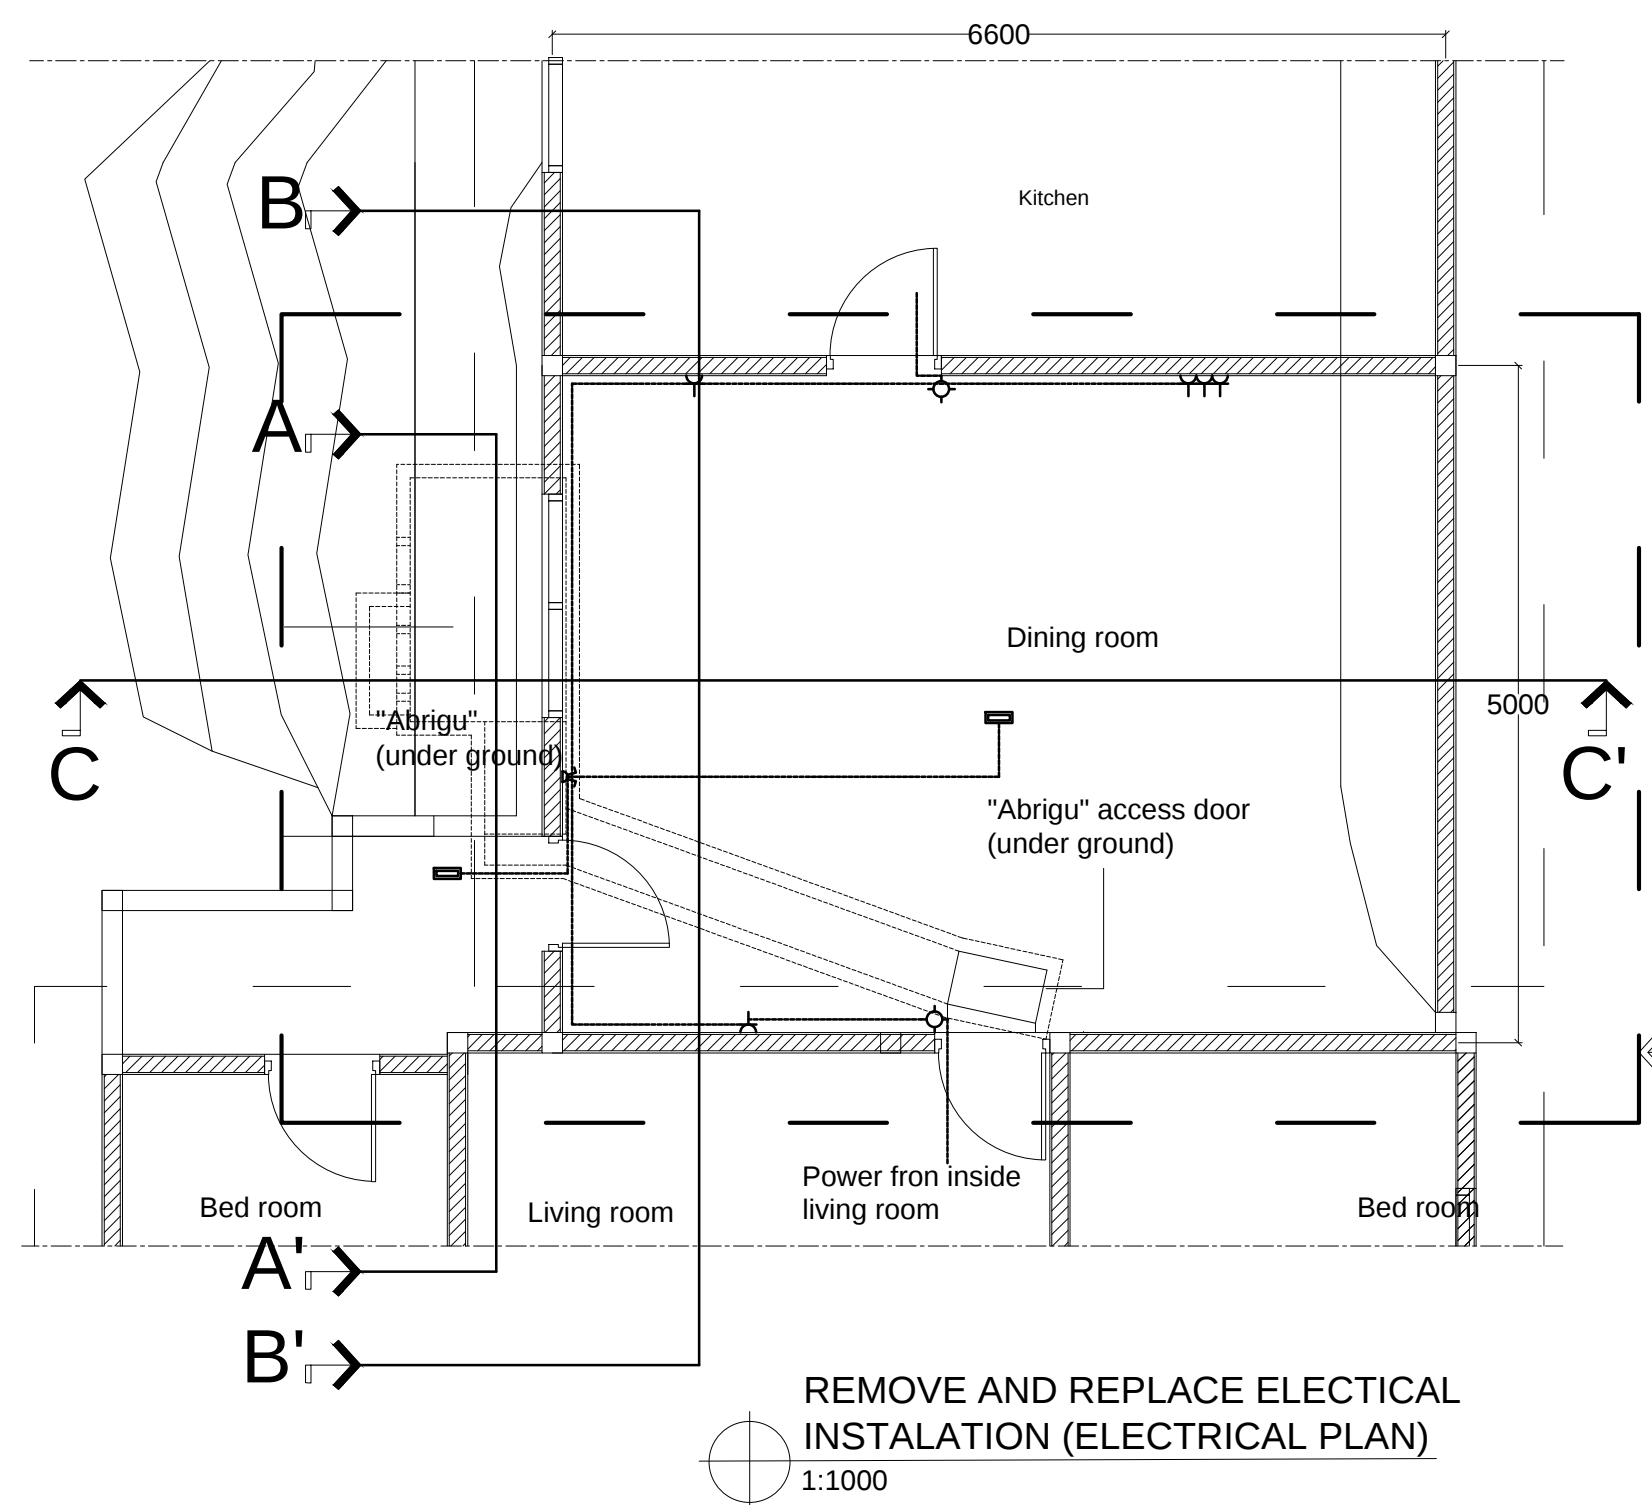

REHABILITATION ITEM FOR "ABRIGU" FATU META
TIMOR LESTE

NO	ITEM
1.	Remove and replace roof sheets RS (dining room)
2.	Remove and replace ceiling
3.	Remove and replace window (WD)
4.	Remove and replace door (D)
5.	Remove and replace wall (WL)
6.	Remove and replace ground floor (dining room)
7.	Remove and replace beam under (WL)
8.	New foundation, column, top beam "abrigu"
9.	Remove and replace "abrigu" top deck
10.	Remove and replace wall block (CHB wall) W1,W2,W3,W4
11.	Remove and replace electricity instalation

Rehabilitation area
(top of "Abrigo")




Note :

⬢	: Flourecent Lamp 40w
⌘	: Double Saklar
⌘	: Single Saklar
⌘	: Stop Contact
⊕	: Terminal
—	: Electical Instalation
—	: EDTL Main Power


REMOVE AND REPLACE ELECTICAL
INSTALATION (ELECTRICAL PLAN)

1:1000

CLIENT / PROJECT OWNER	PREPARED BY	PROJECT TITLE	DRAWING TITLE	CONSULTANT DESIGN: A3R CONSULTANT	PROJECT OWNER	SHEET NO:
ARQUIVO & MUSEU RESISTÊNCIA TIMORENSE INSTITUTO PÚBLICO REPÚBLICA DEMOCRÁTICA DE TIMOR LESTE Avenida Cidade de Lisboa, Dili, Timor Leste Phone: +670 - 77305782	ANGEL/AQUIRA Consultant, Unipessoal Lda. Architectural & Engineering Design, Supervision and Project Management Vila Verde, Dili, Timor - Leste, Phone: +670 - 7238140 E-mail: ino_neves@yahoo.com	REHABILITAÇÃO DE ABRIGUS DA RESISTÊNCIA ABRIGU FATU META FATU META, DILI TIMOR LESTE	REMOVE AND REPLACE ELECTRICAL INSTALATION	DRAWING BY: Arch. Aquilino F. das Neves	APPROVED BY: Eng. Jesuino J.X. Neves Sr. Hamar Antoninho Baptista Alves Director e Presidente AMRT	DEMOCRATIC REPUBLIC OF TIMOR LESTE MINISTRY OF PUBLIC WORK, TRANSPORT AND COMMUNICATION GENERAL DIRECTORATE OF PUBLIC WORKS NATIONAL DIRECTORATE OF BUILDING VERIFIED BY: DATE APPROVED BY: DATE Eng. Octavio P. Marques, M.Eng. HEAD OF PROJECT DEPARTMENT Arch. Rosa Amaral Vong Directress of DNE
LOCATION : DILI		SCALE : 1:1000		DATE :	DATE :	DRAWING NO: ARCH 28 OF 29

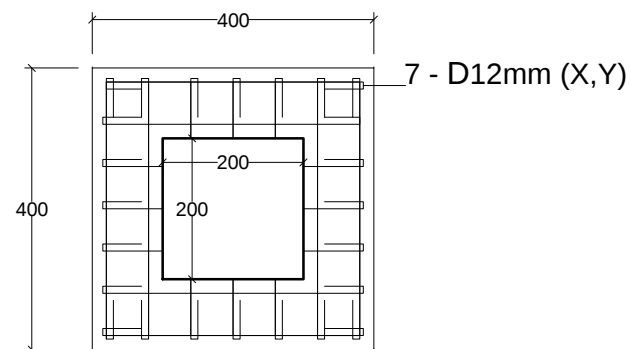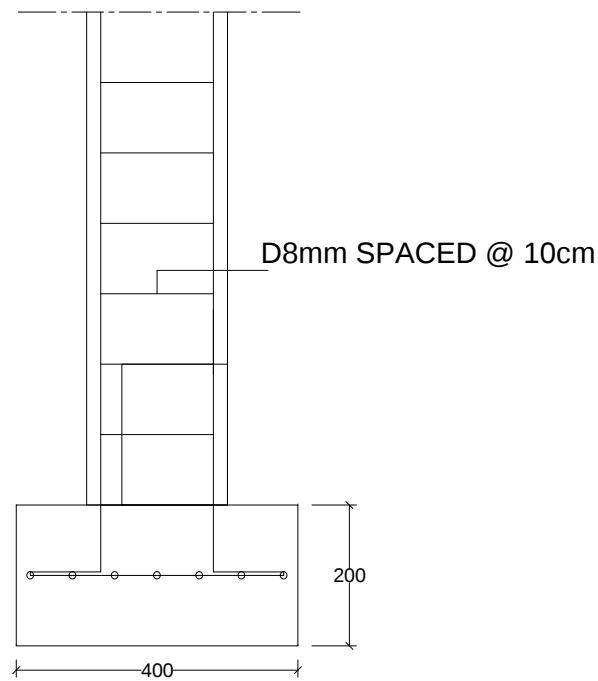
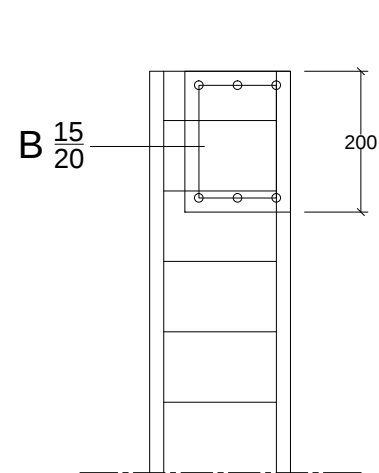


FOOT PLATE & COLUMN

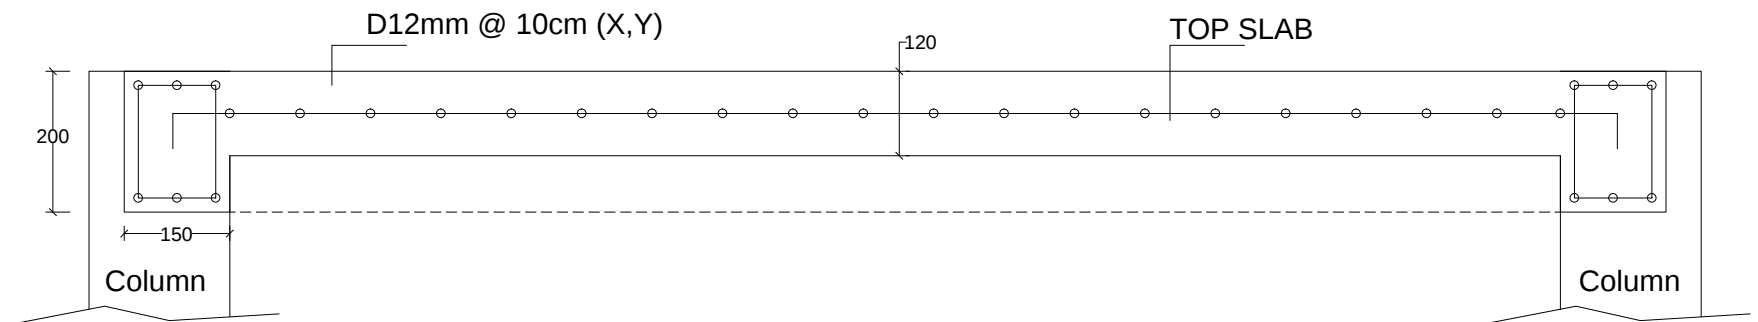

"ABRIGU" TOP SLAB AND BEAM

REINFORCEMENT

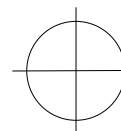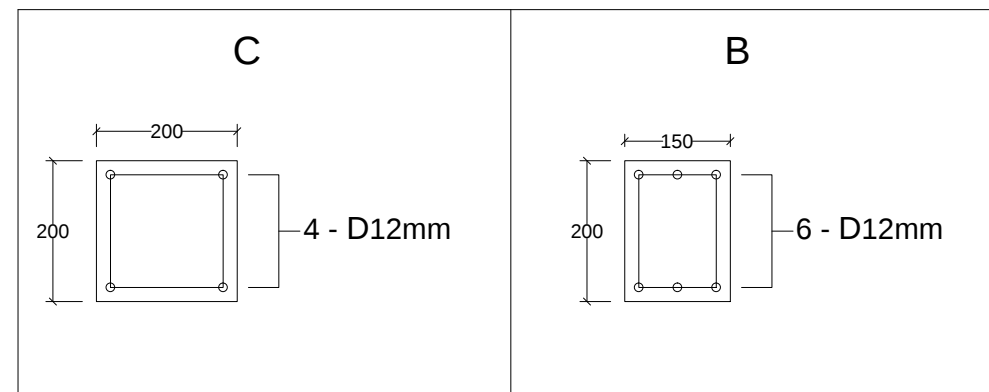

REINFORCEMENT DETAILS

1:300

CLIENT / PROJECT OWNER		PREPARED BY	PROJECT TITLE	DRAWING TITLE	CONSULTANT DESIGN: A3R CONSULTANT		PROJECT OWNER	DEMOCRATIC REPUBLIC OF TIMOR LESTE				SHEET NO:
 ARQUIVO & MUSEU RESISTÊNCIA TIMORENSE INSTITUTO PÚBLICO REPÚBLICA DEMOCRÁTICA DE TIMOR LESTE Avenida Cidade de Lisboa, Dili, Timor Leste Phone: +670 - 77305782		 ANGEL/AQUIRA Consultant, Unipessoal Lda. Architectural & Engineering Design, Supervision and Project Management Vila Verde, Dili, Timor - Leste, Phone: +670 - 7238140 E-mail: ino_neves@yahoo.com	REHABILITAÇÃO DE ABRIGUS DA RESISTÊNCIA ABRIGU FATU META FATU META, DILI TIMOR LESTE	REINFORCEMENT DETAIL	DRAWING BY:	APPROVED BY:	APPROVED BY:	 MINISTRY OF PUBLIC WORK, TRANSPORT AND COMMUNICATION GENERAL DIRECTORATE OF PUBLIC WORKS NATIONAL DIRECTORATE OF BUILDING				29 OF 29
					Arch. Aquilino F. das Neves	Eng. Jesuino J.X. Neves	Sr. Hamar Antoninho Baptista Alves Director e Presidente AMRT	VERIFIED BY:	DATE	APPROVED BY:	DATE	DRAWING NO: ARCH 29 OF 29
			LOCATION : DILI	SCALE : 1:300	DATE :	DATE :	DATE :	Eng. Octavio P. Marques, M.Eng. HEAD OF PROJECT DEPARTMENT		Arch. Rosa Amaral Vong Directress of DNE		